



**PELAN KONSEP**

RUJ. IBU PEJABAT LAP: LAP S/4/1-1661  
 RUJ. WILAYAH TENGAH I LAP: LAP W.TGH.1 3-1/2/336

Kegunaan L.A.P.:

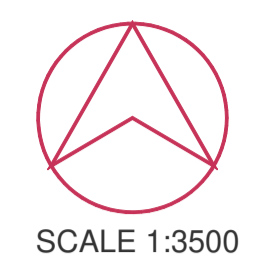

SCALE 1:3500

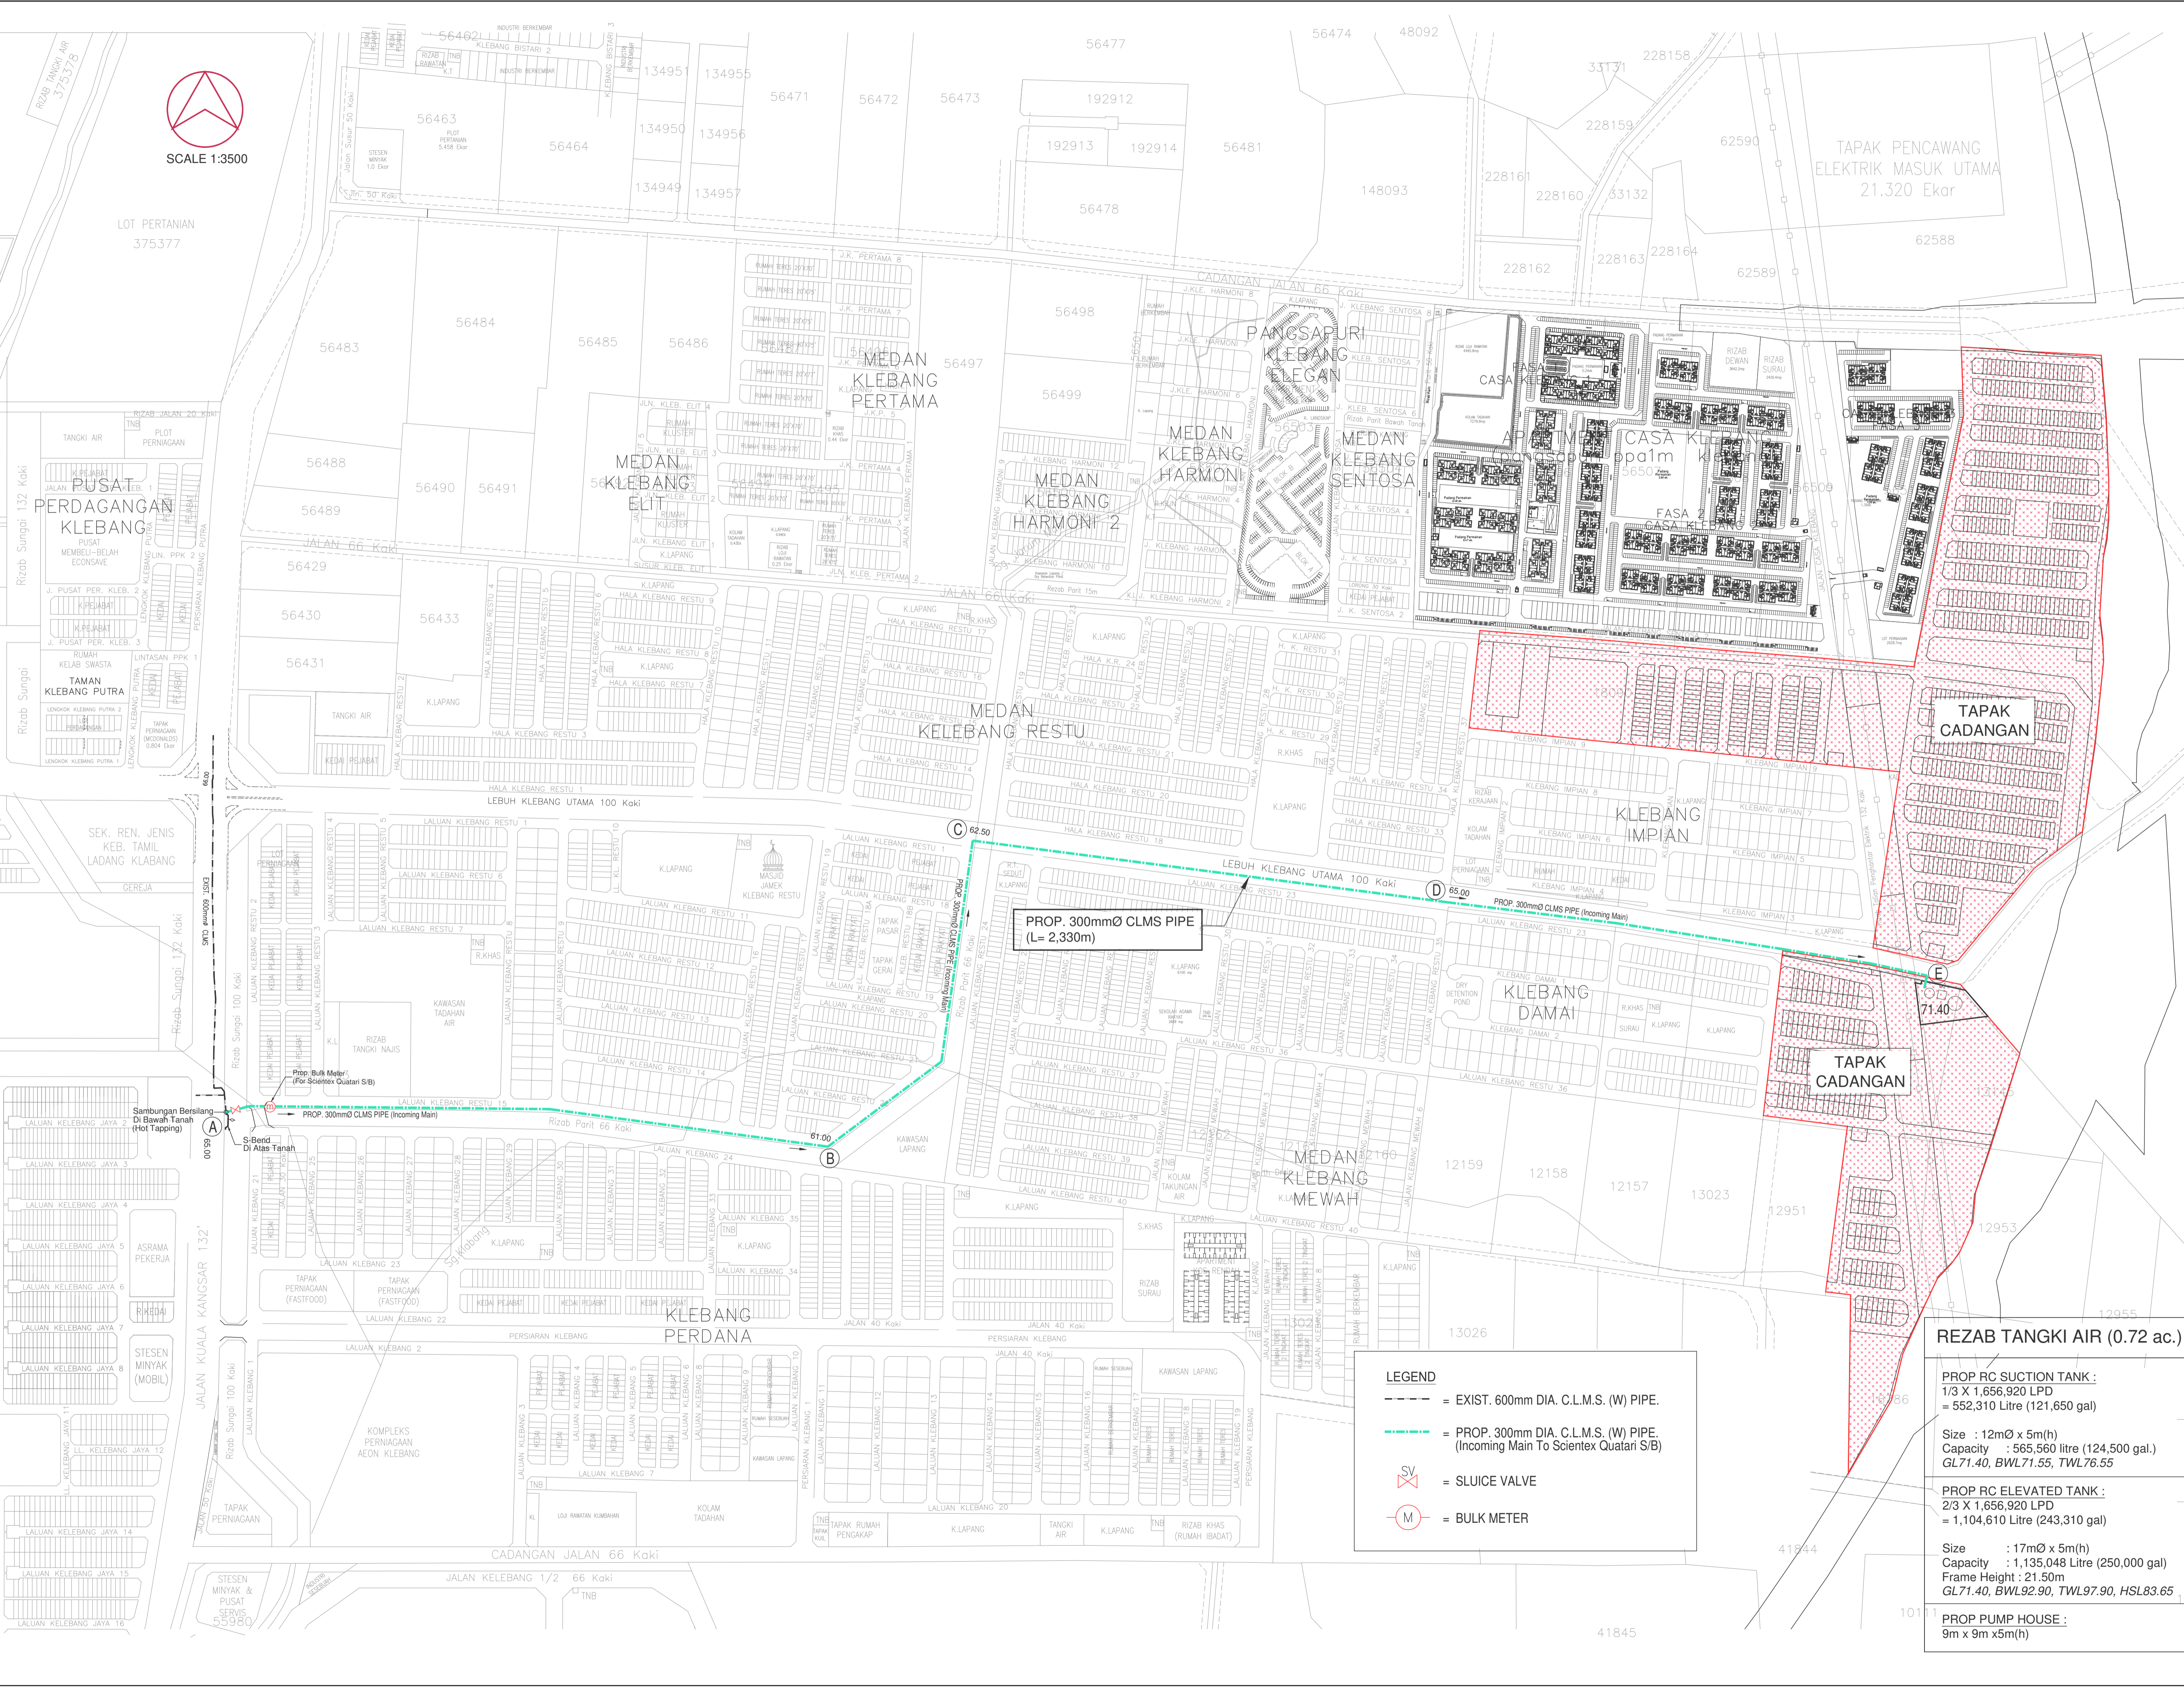

PROP. 300mmØ CLMS PIPE  
(L= 2,330m)

**LEGEND**

- = EXIST. 600mm DIA. C.L.M.S. (W) PIPE.
- = PROP. 300mm DIA. C.L.M.S. (W) PIPE. (Incoming Main To Scientex Quatari S/B)
- SV = SLUICE VALVE
- M = BULK METER

**REZAB TANGKI AIR (0.72 ac.)**

PROP RC SUCTION TANK :  
 1/3 X 1,656,920 LPD  
 = 552,310 Litre (121,650 gal)

Size : 12mØ x 5m(h)  
 Capacity : 565,560 litre (124,500 gal.)  
 GL71.40, BWL71.55, TWL76.55

PROP RC ELEVATED TANK :  
 2/3 X 1,656,920 LPD  
 = 1,104,610 Litre (243,310 gal)

Size : 17mØ x 5m(h)  
 Capacity : 1,135,048 Litre (250,000 gal)  
 Frame Height : 21.50m  
 GL71.40, BWL92.90, TWL97.90, HSL83.65

PROP PUMP HOUSE :  
 9m x 9m x 5m(h)

Date	Ref.	Amendment
05/05/2025	A	Revised Of Cross Connection Location

Developer's Signature :

**DATUK ALEX KHAW GIET THYE**  
 (Chief Operating Officer)  
 680919-03-5025

**SCIENTEX QUATARI SDN BHD**  
 (Incorporated in Malaysia)  
 Scientex Ipoh Sales Gallery,  
 Lot 512916, Hala Klebang Restu 37,  
 Medan Klebang Restu,  
 31200, Chemor, Perak.  
 Tel: 05-525 2216 Fax: 05-525 2836

Project Title :

**CADANGAN RETIKULASI AIR UNTUK  
 CADANGAN SKIM PERUMAHAN, SELUAS  
 73.50 EKAR (29,7443 HEKTAR), DI ATAS  
 LOT 12950 (GRN 26746), LOT 12961 (GRN 26853),  
 LOT 512911 (GRN 181788), LOT 512916 (GRN 164630),  
 LOT 512967 (GRN 164204), LOT 512968 (GRN 164206)  
 DAN LOT 512969 (GRN 164209), MUKIM HULU KINTA,  
 DAERAH KINTA, PERAK DARUL RIDZUAN.**

UNTUK TETAPAN: SCIENTEX QUATARI SDN. BHD.  
 LOKASI : KLEBANG (4)

[Pindaan Kepada Kelulusan Pelan Konsep Sistem Bekalan  
 Air Yang Bertarikh : 28/05/2024 Dengan No. Rujukan :  
 LAP S/4/1-1661(3)]

Sub Title :

**SITE PLAN**

Engineer's Signature :

I hereby certify that these details are in accordance with the water supply enactment and bye laws and accept full responsibility for the design and supervision of the works.

**PERUNDING MANH SDN BHD** (133245-W)  
 CONSULTING ENGINEERS / JURUTERA PERUNDING  
 No. 10, Jalan Chew Boon Juan,  
 30250 Ipoh, Perak Darul Ridzuan.  
 Tel / Fax : 05-210 0818  
 E-mail: manh.jp@yahoo.com  
 SST: A10-2001-32100003

DESIGNED BY	DATE	SCALE
DRAWN BY	05-05-2025	1 : 3500
CHECKED BY	Ir. Ma W. L.	
DRAWG NO:	SQ/2242/HS/CONCEPT -1A	