
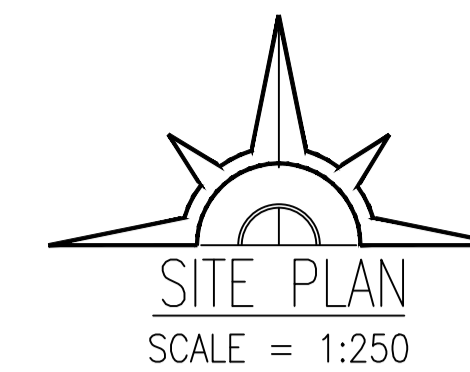


LEGEND:

- INDIVIDUAL SEPTIC TANK (ECOSEPT P-12)
- 150mm ϕ VCP PIPE
- 200mm ϕ UPVC PIPE
- 1 UNIT BENGKEL (LOT 18380)

NOTE:
ALL LEVEL ARE IN METER

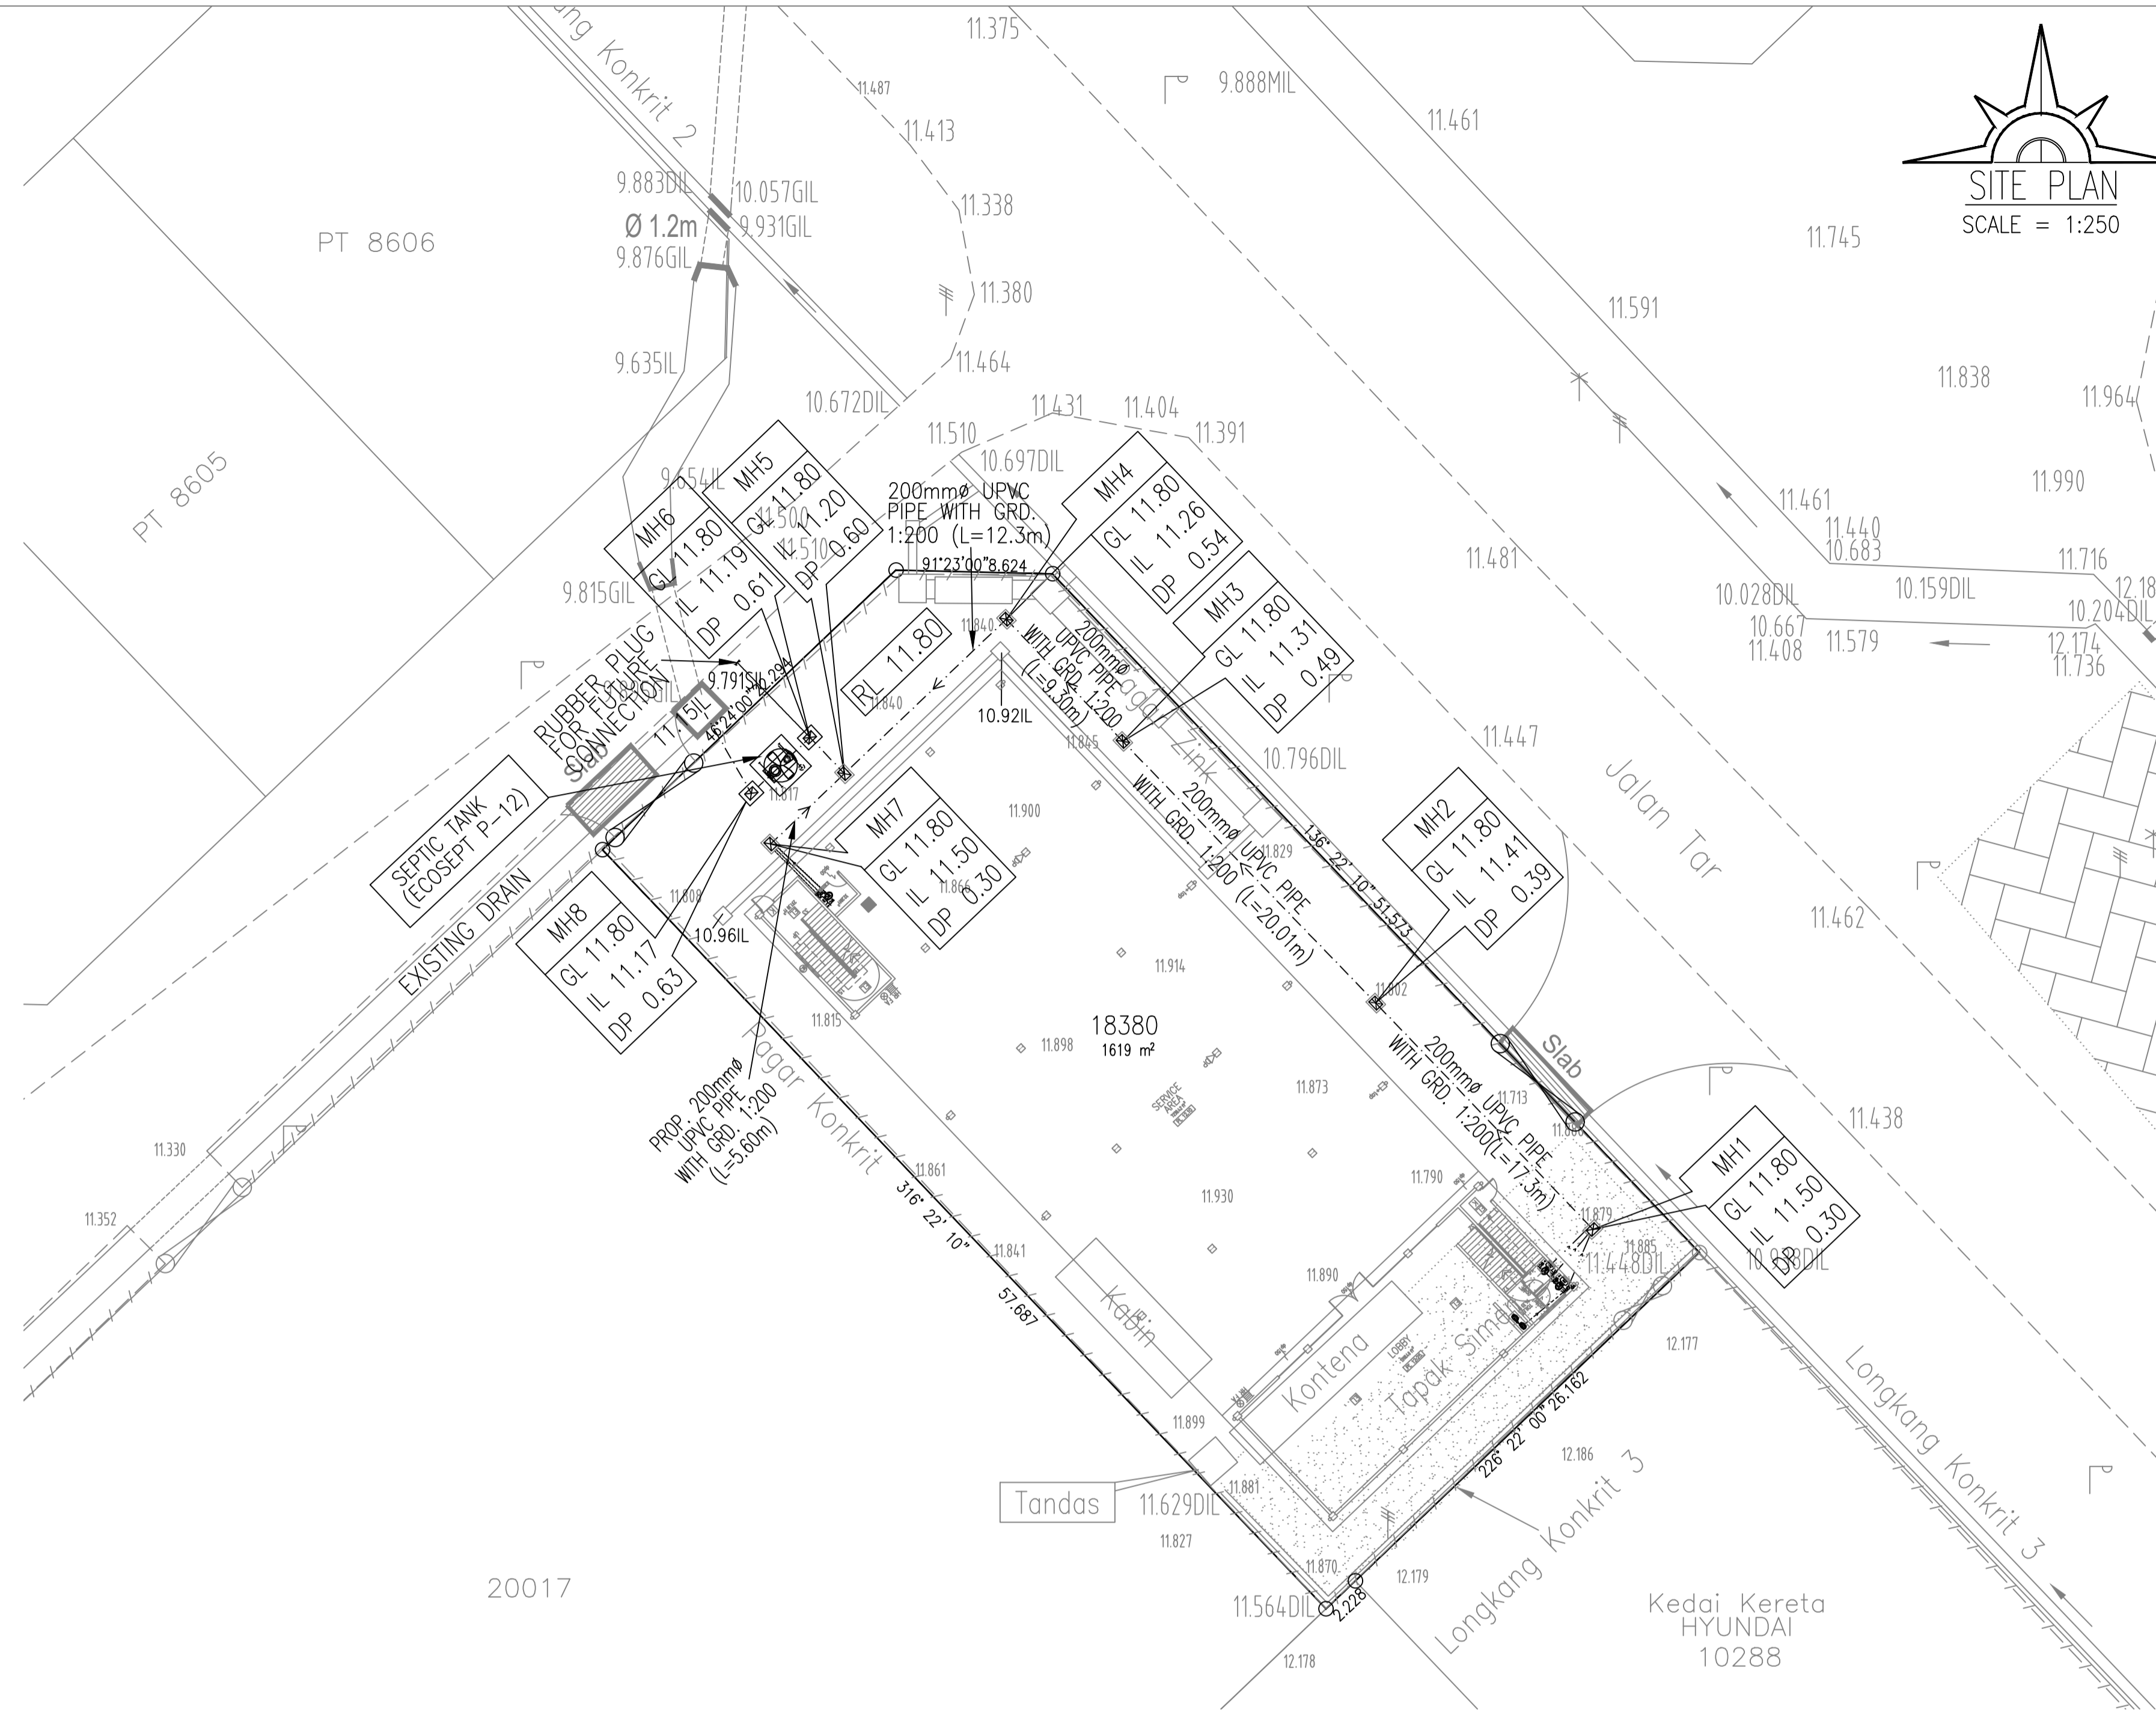

NOTES:

NO	AMENDMENT	DATE	BY

APPROVED BUILDING PLAN NO.:

LAND & BUILDING OWNER'S SIGNATURE & ADDRESS:

CHUAN SENG AUTO SERVICES SDN. BHD.
(945056-D)

ALAMAT : LOT 10288 & LOT 23834, BATU 2 1/2, JALAN SIMPANG, TAIPING, 34000 PERAK

PROJECT:
CADANGAN PINDAAN KEPADA PELAN BANGUNAN YANG TELAH DILULUSKAN FAIL M.P.T (BIL. (08) DLM.MPT. G3/D/12/2021) BERTARIKH 18 OKTOBER 2022 BAGI CADANGAN MEMBINA SEBUAH BENGKEL DI ATAS LOT 18380, MUKIM ASAM KUMBANG, DAERAH LARUT & MATANG, PERAK DARUL RIDZUAN.

FOR:
CHUAN SENG AUTO SERVICES SDN. BHD.

DRAWING:
SEWERAGE (AS-BUILT)
KEY PLAN
LOCATION PLAN
SITE PLAN

I hereby certify that the design calculations and plans have been prepared by me and comply with the requirements of MS 1228 "Code of Practice for Design and Installation of Sewerage Systems" and I accept full responsibility for the design, calculations and plans.

CCY PERUNDING

(No. No. : 1000-SP-6501)

ENGINEERING CONSULTANT
CIVIL & STRUCTURAL ENGINEERING
WATER SUPPLY ENGINEERING
PROJECT MANAGEMENT

I hereby certify that these works have been designed by me in accordance with sound engineering practice and that I take full responsibility for the design and proper performance of the same

ADDRESS : No. 12, Tingkat Atas, Jalan Raja Sulong, Medan Taiping, 34000 Taiping, Perak.
E-MAIL : pmk.taiping@yahoo.com.my
TEL : 05-8072949, FAX : 05-8072924, H/PHONE : 019-5775103

SCALE: AS SHOWN

DRAWN: AZIM	DATE: JULY 2024
DESIGNED: AZIM	PROJECT NO.
CHECKED: CCY	CCY/0409/19/SEW (AS-BUILT)
AMENDMENT :	DWG. NO. 1