


**(DAERAH HULU TERENGGANU)  
SEKOLAH KEBANGSAAN KAMPONG TAYOR**

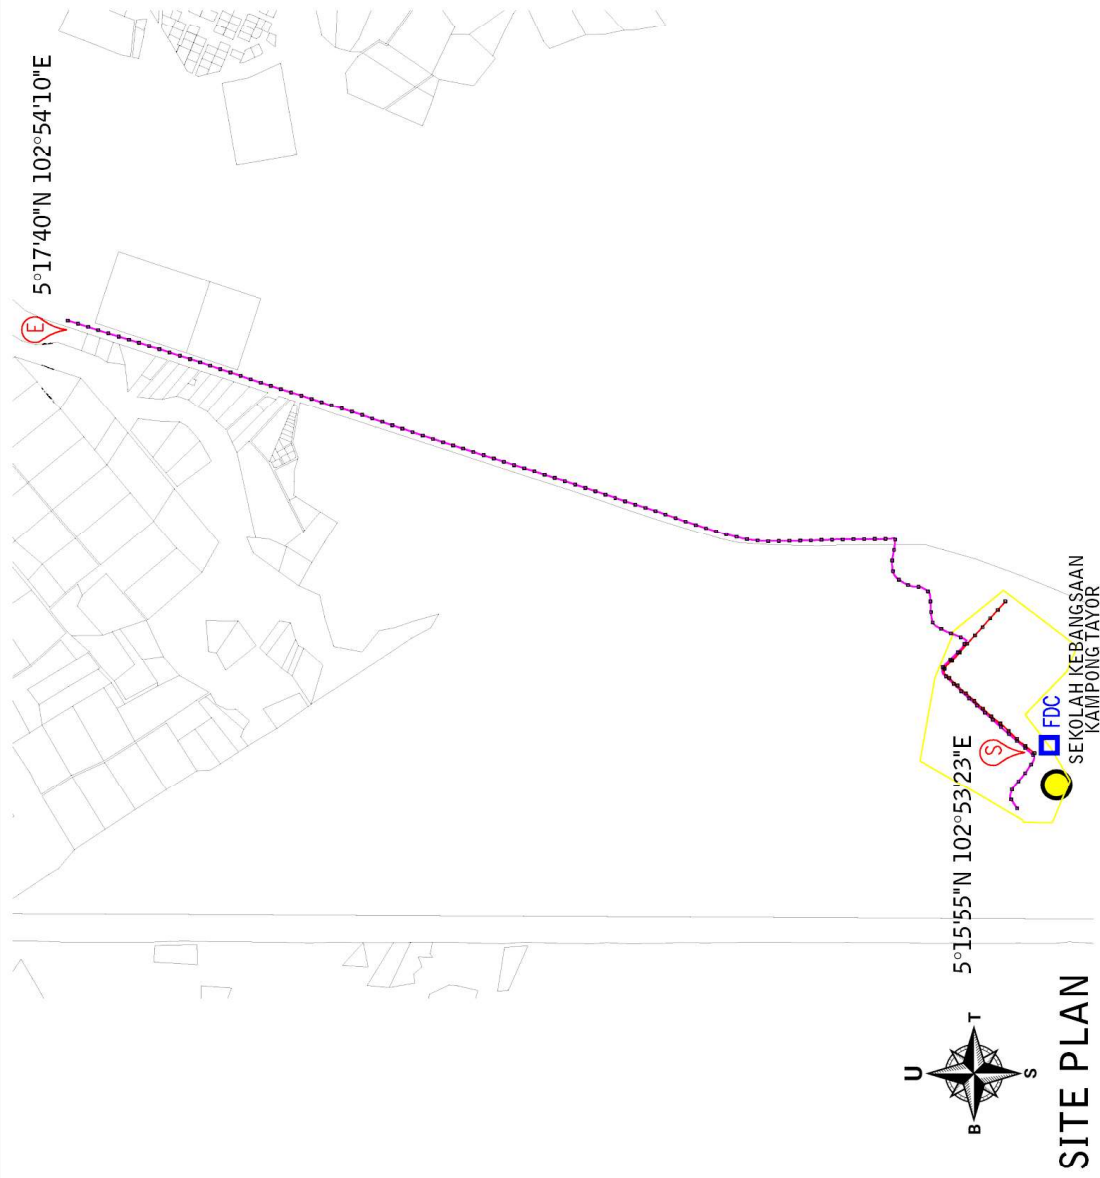

- total length = 720.82mm  
- post = 20 nos  
- distance post = 35m

- total length = 4120.17m  
- post = 117 nos  
- distance post = 35m

 
**TOTAL POST = 137 NOS**

**LEGEND :**

- GPON CABLE
- BACKHAUL CABLE
- FIBRE DISTRIBUTION CABINET
- START
- END
- SCHOOL

FDC

**SITE PLAN**

DRAWN BY: Polyar	CHKD BY:	STATE: TERENGGANU	ENDORSE BY:	KORIDOR UTILITI TEKNOLOGI TERENGGANU (Telan Infrastruktur Utiliti)	NOTE:	SHEET
		DATE: DEC 2024				
DATE: DEC 2024	DWG. NO.: NAYAR/24/11	SCALE: NOT TO SCALE	VERSION: 1			
						09-09

*(Signature)*  
AHMAD FARID BIN MOHAMAD  
AZIMAT TELCO SDN BHD  
(1367371-U)