



**(DAERAH HULU TERENGGANU)  
SEKOLAH KEBANGSAAN BUKIT MUNDOK**

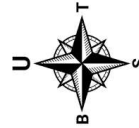

**SITE PLAN**

- total length = 2,010.06m  
- post = 57 nos  
- distance post = 35m

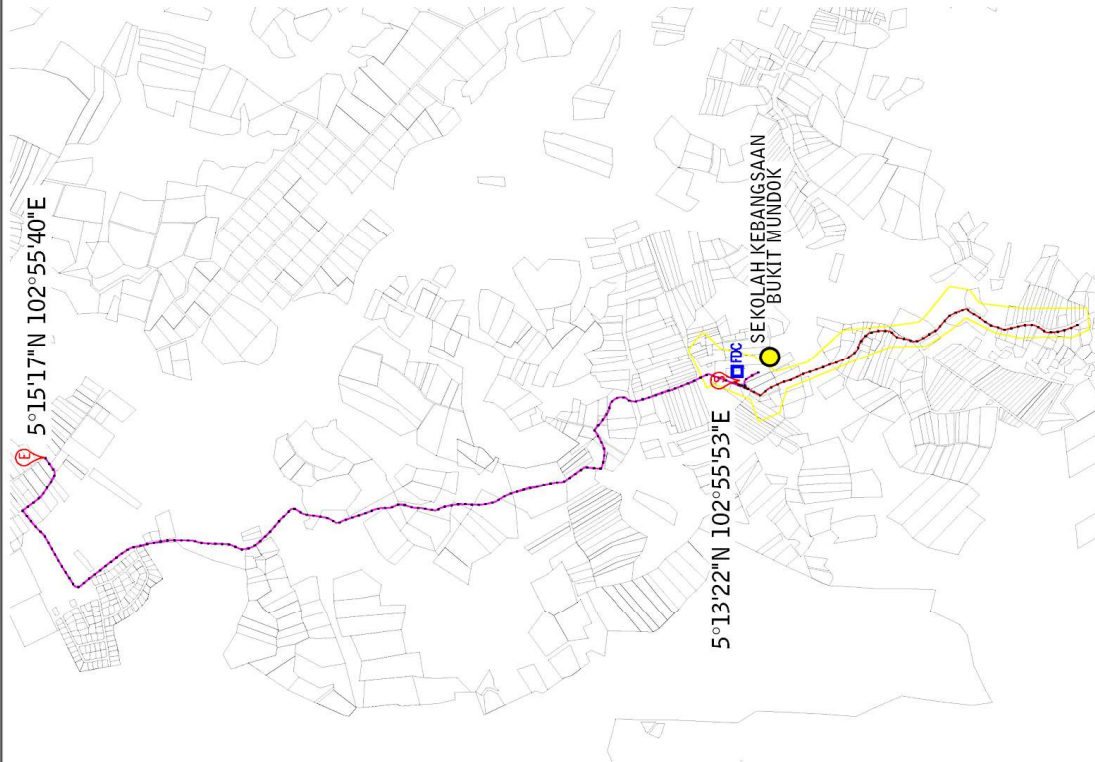

- total length = 5,050.46m  
- post = 144 nos  
- distance post = 35m



**TOTAL POST = 201 NOS**

**LEGEND :**

- GPON CABLE
  - BACKHAUL CABLE
  - FIBRE DISTRIBUTION CABINET
  - START
  - END
  - SCHOOL
- FDC

DRAWN BY: Polyar CHKD BY: DATE: DEC 2024 DWG. NO.: NAYAR/24/11	CLUSTER NAME : HULU TERENGGANU	ENDORSE BY:	NOTE: KORIDOR UTILITI TEKNOLOGI TERENGGANU (Telan Infrastruktur Utiliti)	SHEET 08-09
	STATE: TERENGGANU SCALE: NOT TO SCALE VERSION: 1	PROJECT TITLE: PENYALAMAN DAN PENYELANGKAPAN LALU LINTAS FIBER OPTIK & PENYALAMAN YANG BERTAMBAH BAGI PERAKHONAN LALU LINTAS PROFESIONAL DAN PENYELANGKAPAN POINT OF PRESENCE (POP) HUBUNGAN STRUKTUR GENTIAN OPTIK PERKAMPARAN BERKUALITI BERKUALITI SERTA SERTANYA KELEHAKMENTERIAN KOMUNIKASI DAN MULTIMEDIA (K-KOM)		SIGNATURE: AHMAD FARID BIN MOHAMAD AZIMAT TELCO SDN BHD (1367371-U)