


PELAN LUARAN TELAH DISEMAK DAN DILULUSKAN OLEH:
TM TECHNOLOGY SERVICES SB

DISEMAK OLEH:
Pegawai Teknik
Integrated Planning
Network Perak
Aras: 4, Bangunan TM
Jalan Jajang, 30020 IPOH

DILULUSKAN OLEH:
SHAWAN BIN
Assistant Manager
Integrated Planning
Network Perak
Aras: 4, Bangunan TM
Jalan Jajang, 30020 IPOH

DATE: 19/07/2024
BY: [Signature]

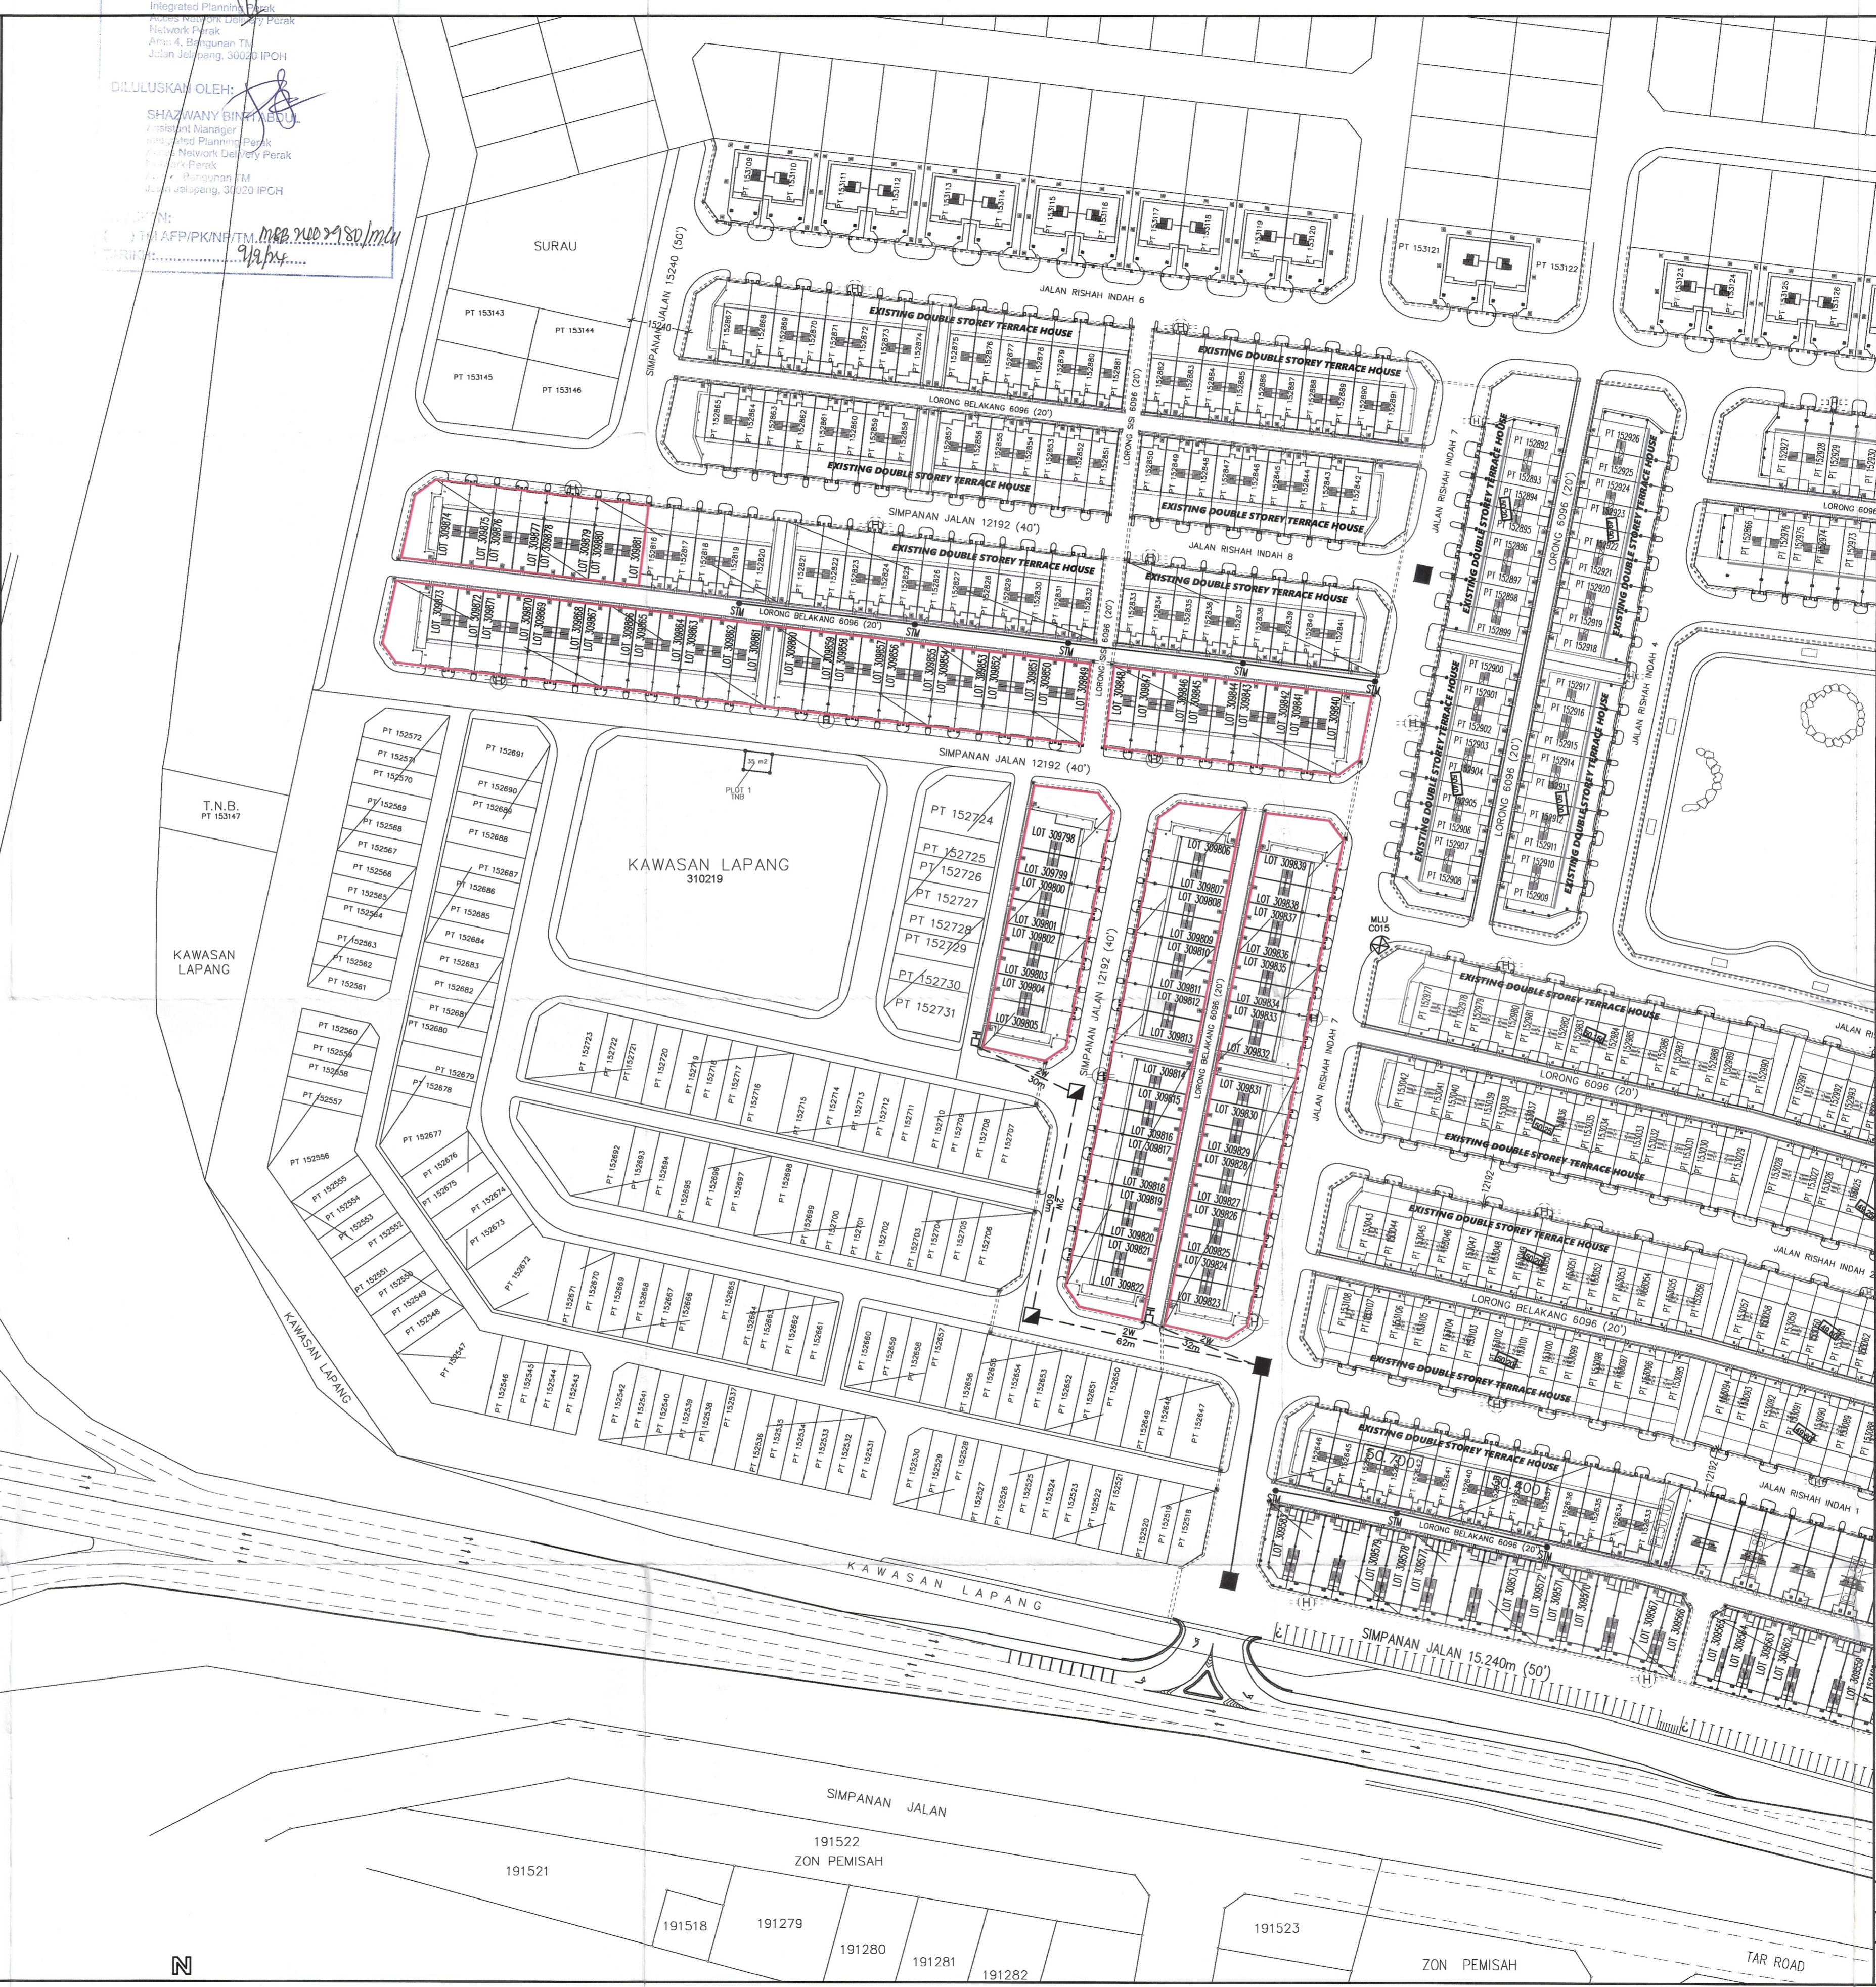

- #### LEGEND
- PROPOSED JRC7 (M) TEL. MANHOLE C/W HEAVY DUTY COVER
 - PROPOSED 30"x18"x30" TEL. JOINTING PIT B30 C/W HEAVY DUTY COVER AND STUMP
 - PROPOSED 2 NOS. 100mm PVC UNDERGROUND DUCTS ROUTE
 - EXISTING TELEPHONE MANHOLE
 - EXISTING TELEPHONE CABINET
 - EXISTING TELEPHONE POLE

TITLE
KEY, LOCATION AND SITE PLAN
-EXTERNAL TELEPHONE LAYOUT

PROJECT
CADANGAN MEMBINA SKIM PERUMAHAN YANG MENDUNGI:
FASA 1: 42 UNIT RUMAH TERES DUA TINGKAT DI ATAS LOT 309798 -LOT 309839 DAN
FASA 2: 42 UNIT RUMAH TERES DUA TINGKAT DI ATAS LOT 309840 -LOT 309881,
DESA RISHAH INDAH, IPOH, MUKIM HULU KINTA, DAERAH KINTA, PERAK DARUL RIDZUAN
UNTUK TETUAN :

ASSOCIATED BUILDERS AND CONTRACTORS SDN BHD

JURUTERA PERUNDING :
KYS PERUNDING KYS SDN. BHD.
(Company no. 1278815-T)
(MECHANICAL & ELECTRICAL CONSULTING ENGINEERS)

UNIT NO: A-3-1, (3RD FLOOR),
JALAN MEDAN IPOH 2,
BANDAR BARU MEDAN IPOH,
31400 IPOH, PERAK DARUL RIDZUAN.
TEL : 05-5483322 & 05-5483399
FAX : 05-5499250
E-MAIL ADDRESS : perundingkys@gmail.com

APPROVED

CHECKED : MR. LIM	DRAWN : IKA
SCALE : AS SHOWN	DATE : JULY 2024
DRAWING NO. ABC/24-12/T1	