


KELULUSAN PLAN

Local Authorities:-

CONFIDENTIALITY

These drawings and details are and shall remain the property of TT dotCom Sdn Bhd. Both are issued in strict confidence and shall not be reproduced, copied or used in any manner without specific written permission from the owner.

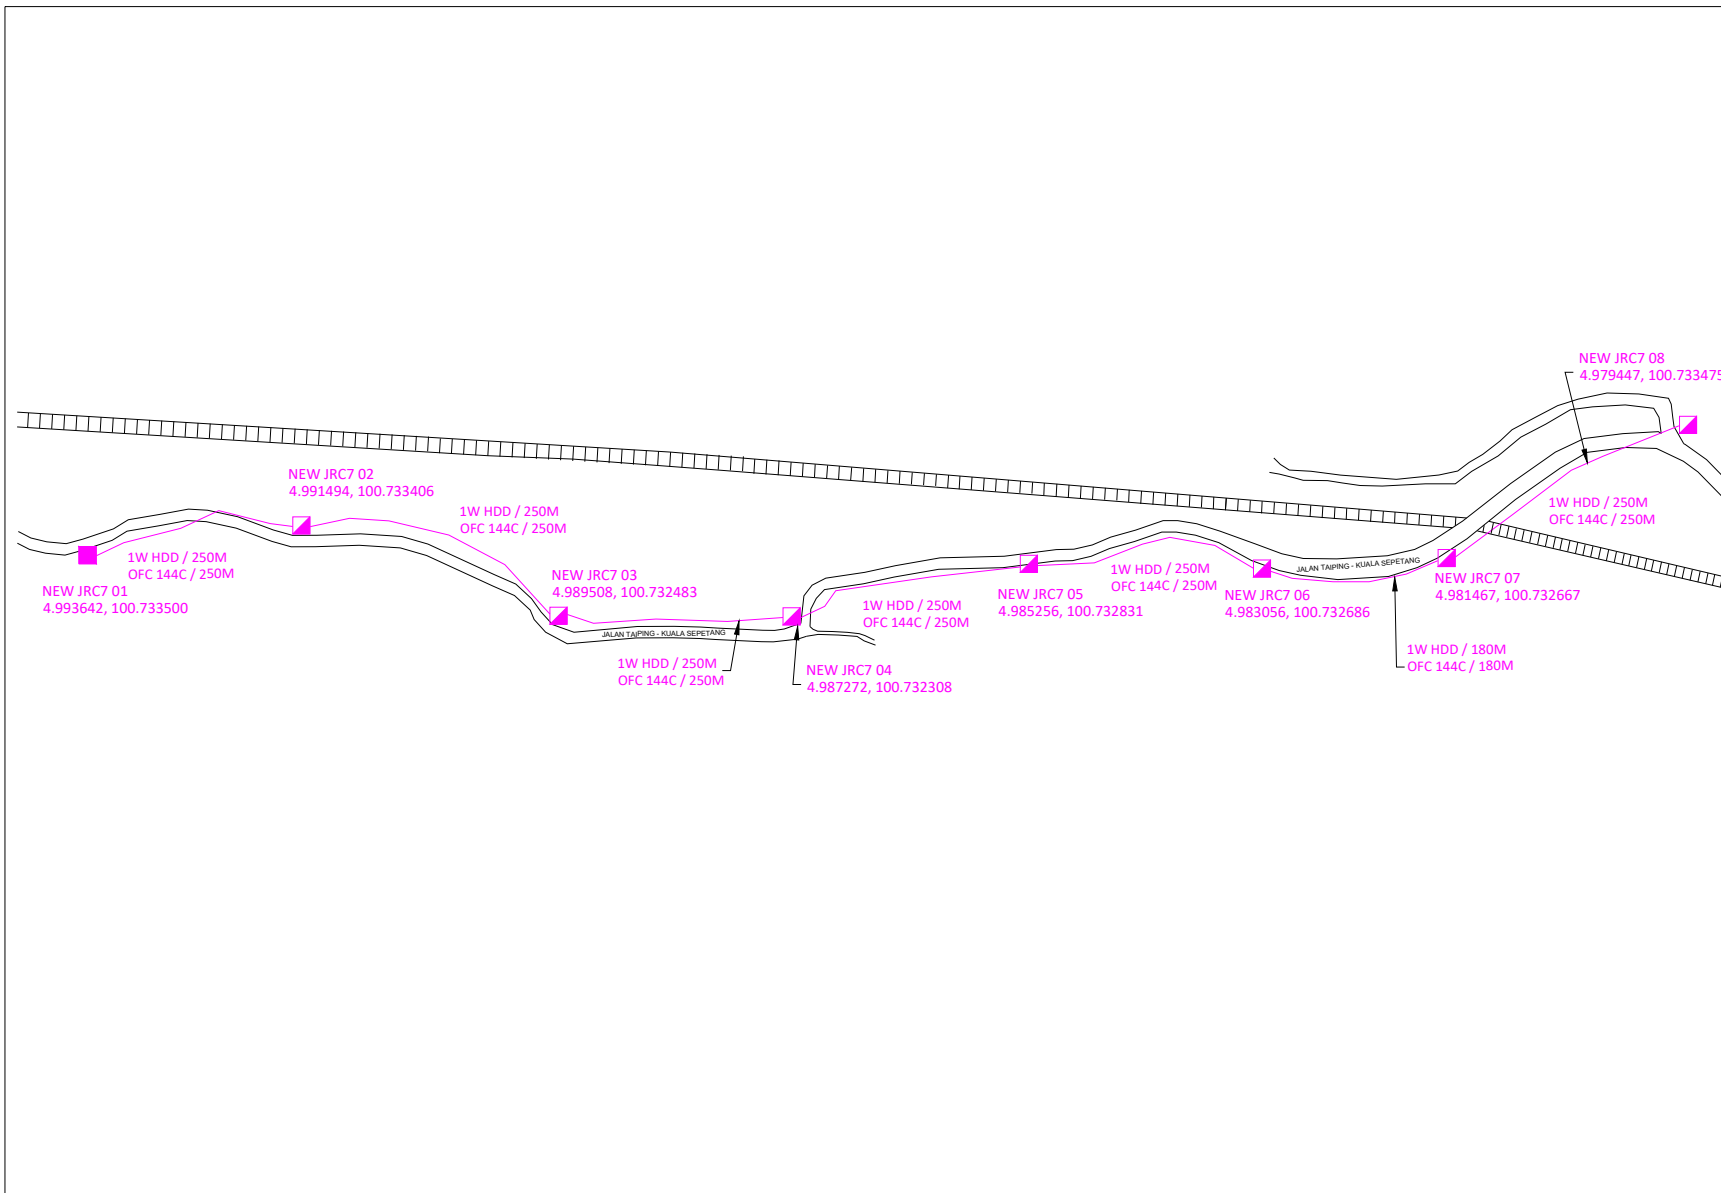

LEGEND :- OUTSIDE PLANT


- = PROPOSED MANHOLE
- = EXISTING TDC MANHOLE
- = 100MM GI PIPE
- = BUILDING MANHOLE
- 1W / 2W = 1 WAY OR 2 WAY DUCT
- GI = GALVANISED IRON DUCT
- PVC = PVC DUCT
- = HIDDEN DRAIN
- = VISIBLE DRAIN
- = TREES AND PLANTS
- = PROPOSED DUCT ROUTE
- = OFC 144C

SCHEDULE OF QUANTITY

SYMBOL	DESCRIPTION	QTY
	NEW JRC7	40

REV. NO.	REV. DATE	REV. BY

CONTRACTOR:



HOMEBASE NETWORK SDN BHD (1190247-H)
 No. D-02-03, Third Floor, Garden Shoppe @ One City,
 Jalan Usj 25/1A,
 47650 Subang Jaya, Selangor Darul Ehsan, Malaysia.



TT dotCom Sdn Bhd (52371-A)
 No 14, Jalan Majistret U1/26,
 Hicom Glenmarie Industrial Park
 40150 Shah Alam, Selangor Darul Ehsan, Malaysia.
 Tel: +60 3 5032 6000
 Website: www.time.com.my

PROJECT TITLE:
Kulim - Padang Rengas Package 2

DRAWING TITLE:
 SITE PLAN DRAWING
 (TECHNICAL PROPOSAL (TP) FOR LAST MILE LINK
 AND BUILDING ACCESS)

DRAWING NO: 0|0|0|0|0|0 SHEET NO: 1 of 1

DRAWING SCALE: N.T.S	DRAWING UNITS: METER
PREPARED BY: HOMEBASE	INITIAL & DATE: 18-7-2023
DESIGNED BY:	INITIAL & DATE: -
CHECKED BY: -	INITIAL & DATE: -
APPROVED BY:	INITIAL & DATE: -










KELULUSAN PLAN

Local Authorities:-


CONFIDENTIALITY


These drawings and details are and shall remain the property of TT dotCom Sdn Bhd. Both are issued in strict confidence and shall not be reproduced, copied or used in any manner without specific written permission from the owner.

LEGEND :- OUTSIDE PLANT

-  = PROPOSED MANHOLE
-  = EXISTING TDC MANHOLE
-  = 100MM GI PIPE
-  = BUILDING MANHOLE
- 1W / 2W = 1 WAY OR 2 WAY DUCT
- GI = GALVANISED IRON DUCT
- PVC = PVC DUCT
-  = HIDDEN DRAIN
-  = VISIBLE DRAIN
-  = TREES AND PLANTS
-  = PROPOSED DUCT ROUTE
-  = OFC 144C


SCHEDULE OF QUANTITY

SYMBOL	DESCRIPTION	QTY
	NEW JRC7	40

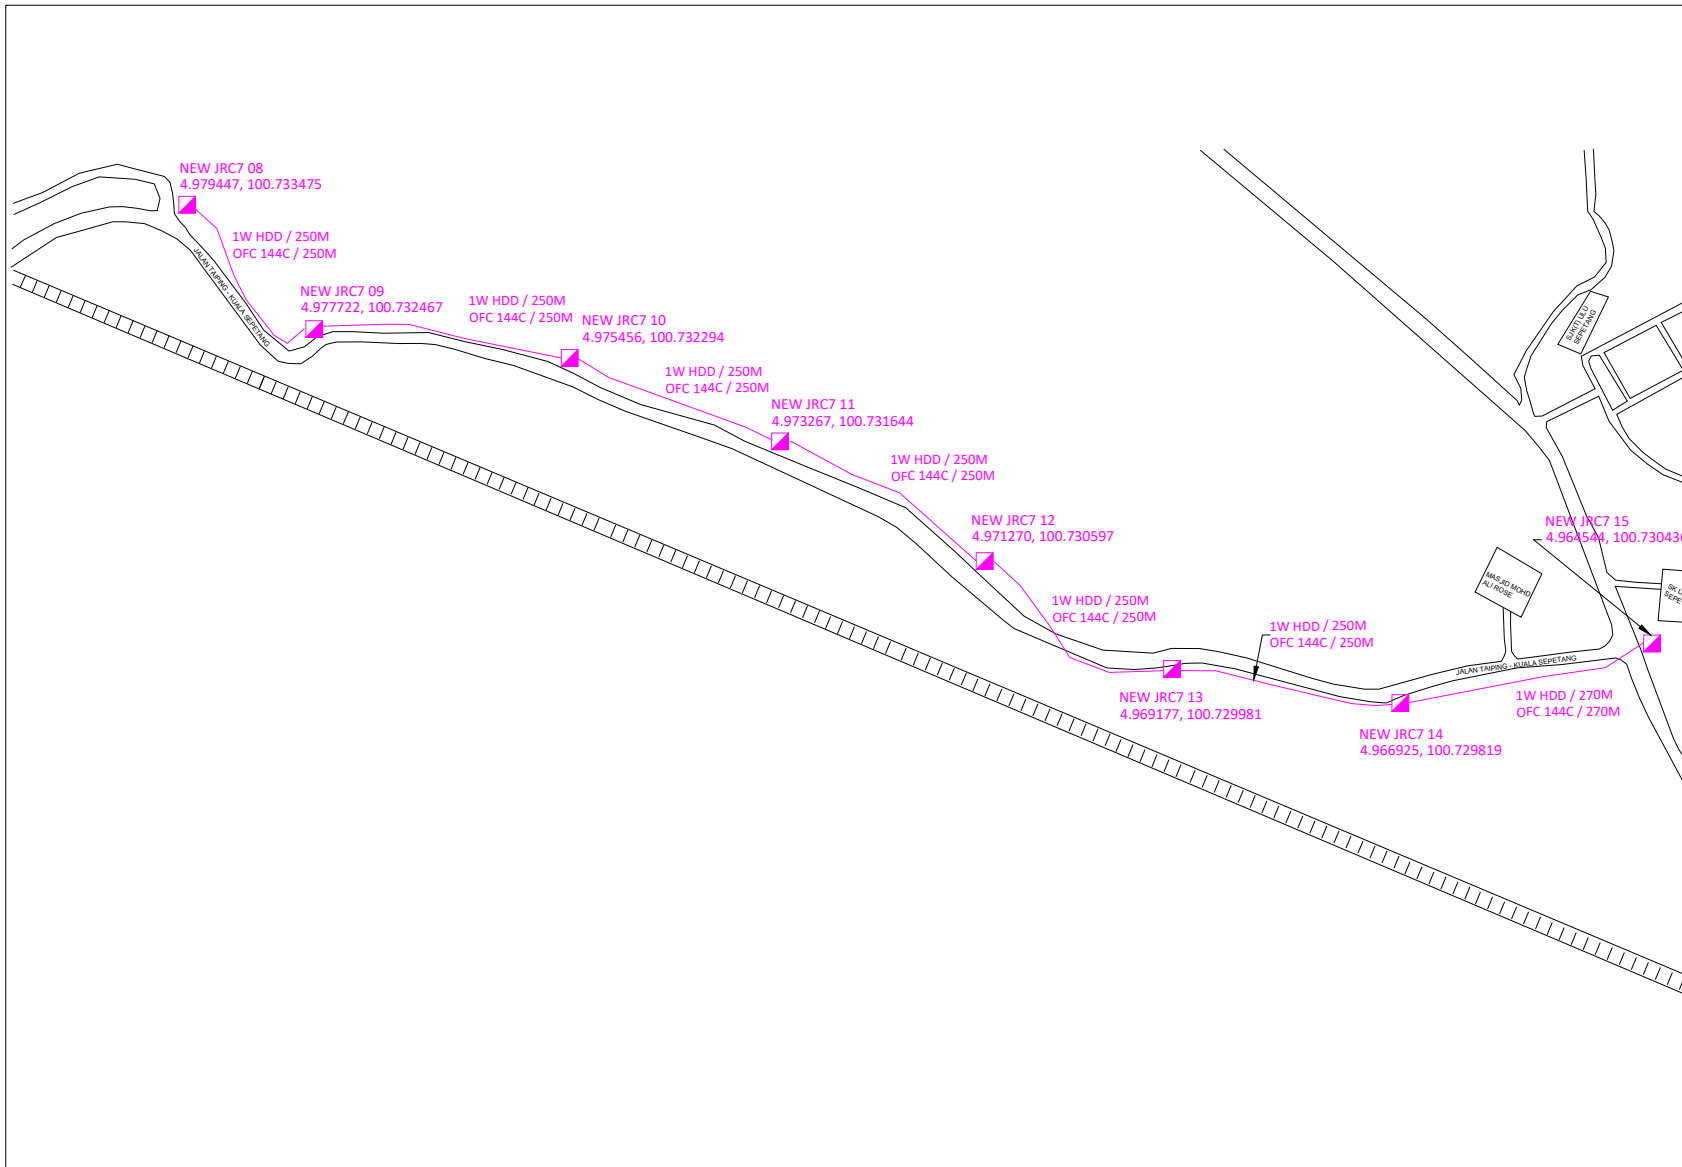

REV. NO.	REV. DATE	REV. BY

CONTRACTOR:



HOMEBASE NETWORK SDN BHD (1190247-H)
 No. D-02-03, Third Floor, Garden Shoppe @ One City,
 Jalan Usj 25/1A,
 47650 Subang Jaya, Selangor Darul Ehsan, Malaysia.



TT dotCom Sdn Bhd (52371-A)
 No 14, Jalan Majistret U1/26,
 Hicom Glenmarie Industrial Park
 40150 Shah Alam, Selangor Darul Ehsan, Malaysia.
 Tel: +60 3 5032 6000
 Website: www.time.com.my

PROJECT TITLE:
Kulim - Padang Rengas Package 2

DRAWING TITLE:
**SITE PLAN DRAWING
 (TECHNICAL PROPOSAL (TP) FOR LAST MILE LINK
 AND BUILDING ACCESS)**

DRAWING NO: 000000 SHEET NO: 1 OF 1

DRAWING SCALE: N.T.S	DRAWING UNITS: METER
PREPARED BY: HOMEBASE	INITIAL & DATE: 18-7-2023
DESIGNED BY:	INITIAL & DATE: -
CHECKED BY: -	INITIAL & DATE: -
APPROVED BY:	INITIAL & DATE: -










KELULUSAN PLAN

Local Authorities:-


CONFIDENTIALITY


These drawings and details are and shall remain the property of TT dotCom Sdn Bhd. Both are issued in strict confidence and shall not be reproduced, copied or used in any manner without specific written permission from the owner.

LEGEND :- OUTSIDE PLANT

-  = PROPOSED MANHOLE
-  = EXISTING TDC MANHOLE
-  = 100MM GI PIPE
-  = BUILDING MANHOLE
- 1W / 2W = 1 WAY OR 2 WAY DUCT
- GI = GALVANISED IRON DUCT
- PVC = PVC DUCT
-  = HIDDEN DRAIN
-  = VISIBLE DRAIN
-  = TREES AND PLANTS
-  = PROPOSED DUCT ROUTE
-  = OFC 144C

SCHEDULE OF QUANTITY

SYMBOL	DESCRIPTION	QTY
	NEW JRC7	40

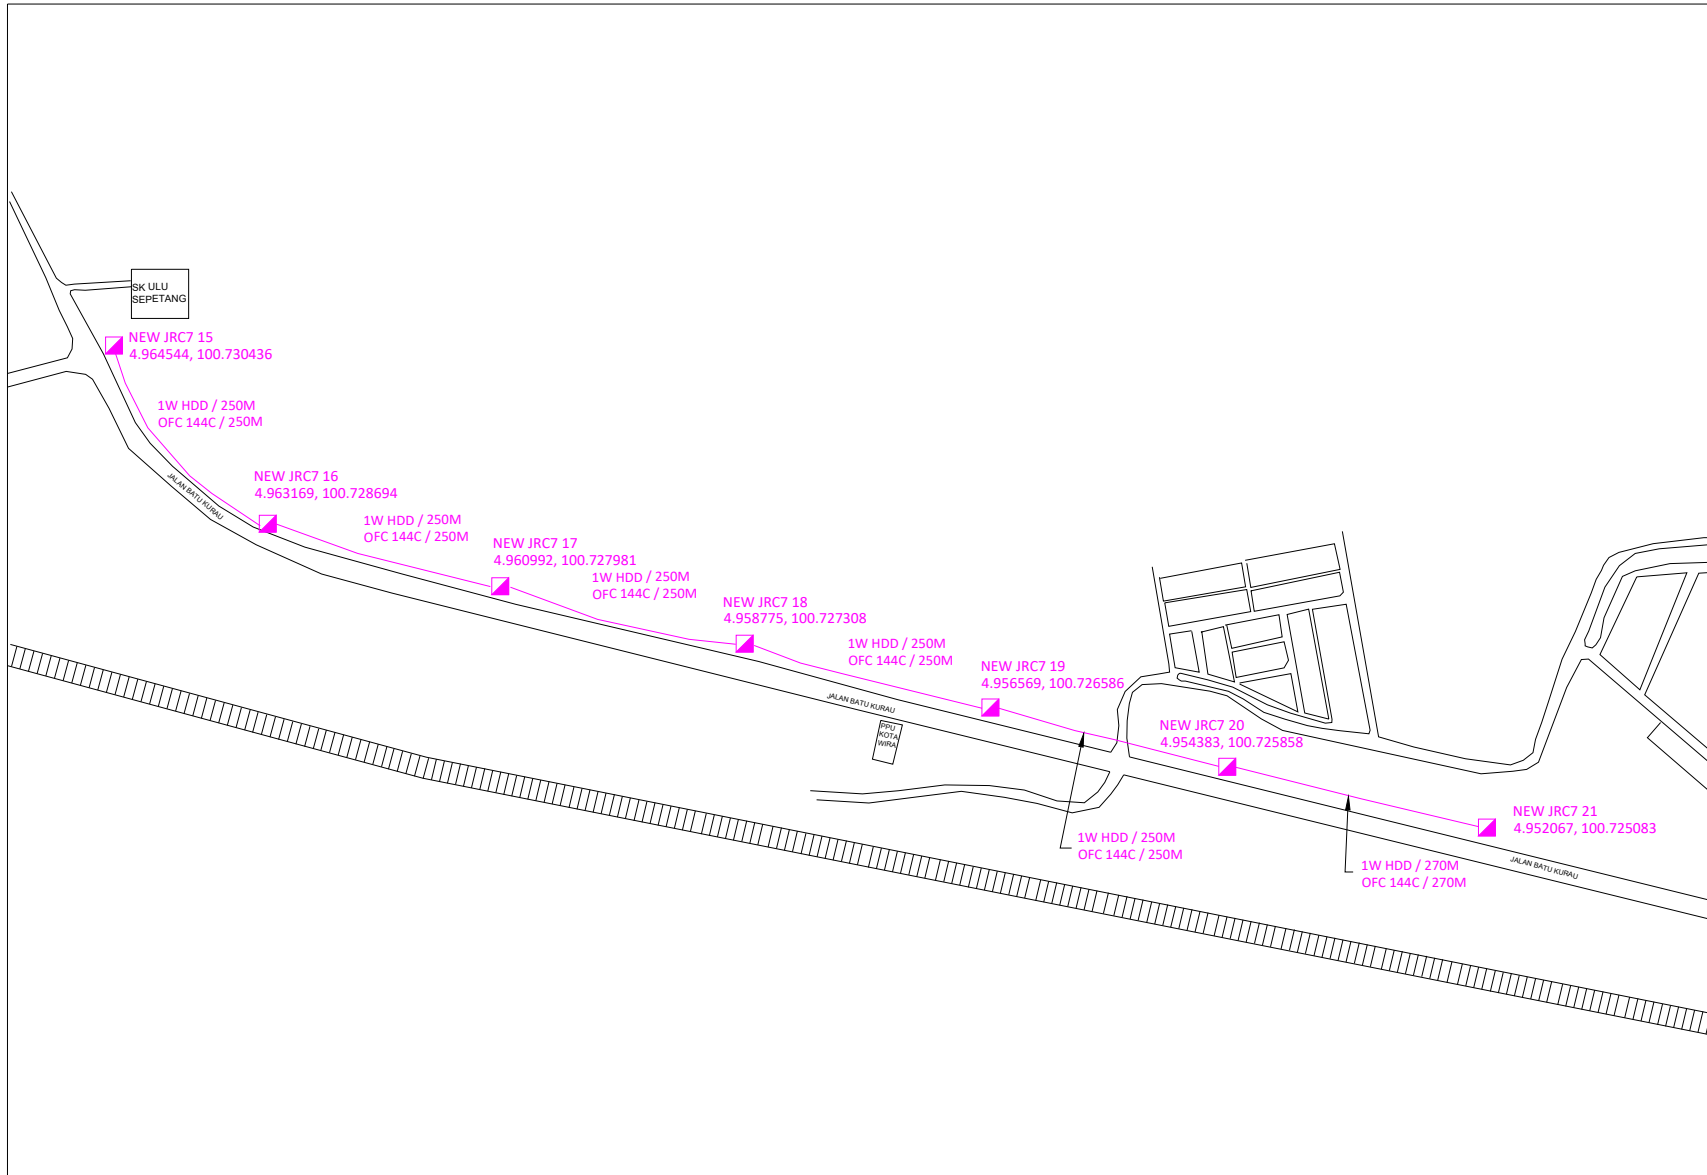

REV. NO.	REV. DATE	REV. BY

CONTRACTOR:



HOMEBASE NETWORK SDN BHD (1190247-H)
 No. D-02-03, Third Floor, Garden Shoppe @ One City,
 Jalan Usj 25/1A,
 47650 Subang Jaya, Selangor Darul Ehsan, Malaysia.



TT dotCom Sdn Bhd (52371-A)
 No 14, Jalan Majistret U1/26,
 Hicom Glenmarie Industrial Park
 40150 Shah Alam, Selangor Darul Ehsan, Malaysia.
 Tel: +60 3 5032 6000
 Website: www.time.com.my

PROJECT TITLE:
Kulim - Padang Rengas Package 2

DRAWING TITLE:
 SITE PLAN DRAWING
 (TECHNICAL PROPOSAL (TP) FOR LAST MILE LINK
 AND BUILDING ACCESS)

DRAWING NO: 00000 SHEET NO: 1 OF 1

DRAWING SCALE: N.T.S	DRAWING UNITS: METER
PREPARED BY: HOMEBASE	INITIAL & DATE: 18-7-2023
DESIGNED BY:	INITIAL & DATE: -
CHECKED BY: -	INITIAL & DATE: -
APPROVED BY:	INITIAL & DATE: -










KELULUSAN PLAN

Local Authorities:--


CONFIDENTIALITY


These drawings and details are and shall remain the property of TT dotCom Sdn Bhd. Both are issued in strict confidence and shall not be reproduced, copied or used in any manner without specific written permission from the owner.

LEGEND :- OUTSIDE PLANT

-  = PROPOSED MANHOLE
-  = EXISTING TDC MANHOLE
-  = 100MM GI PIPE
-  = BUILDING MANHOLE
- 1W / 2W = 1 WAY OR 2 WAY DUCT
- GI = GALVANISED IRON DUCT
- PVC = PVC DUCT
-  = HIDDEN DRAIN
-  = VISIBLE DRAIN
-  = TREES AND PLANTS
-  = PROPOSED DUCT ROUTE
-  = OFC 144C


SCHEDULE OF QUANTITY

SYMBOL	DESCRIPTION	QTY
	NEW JRC7	40

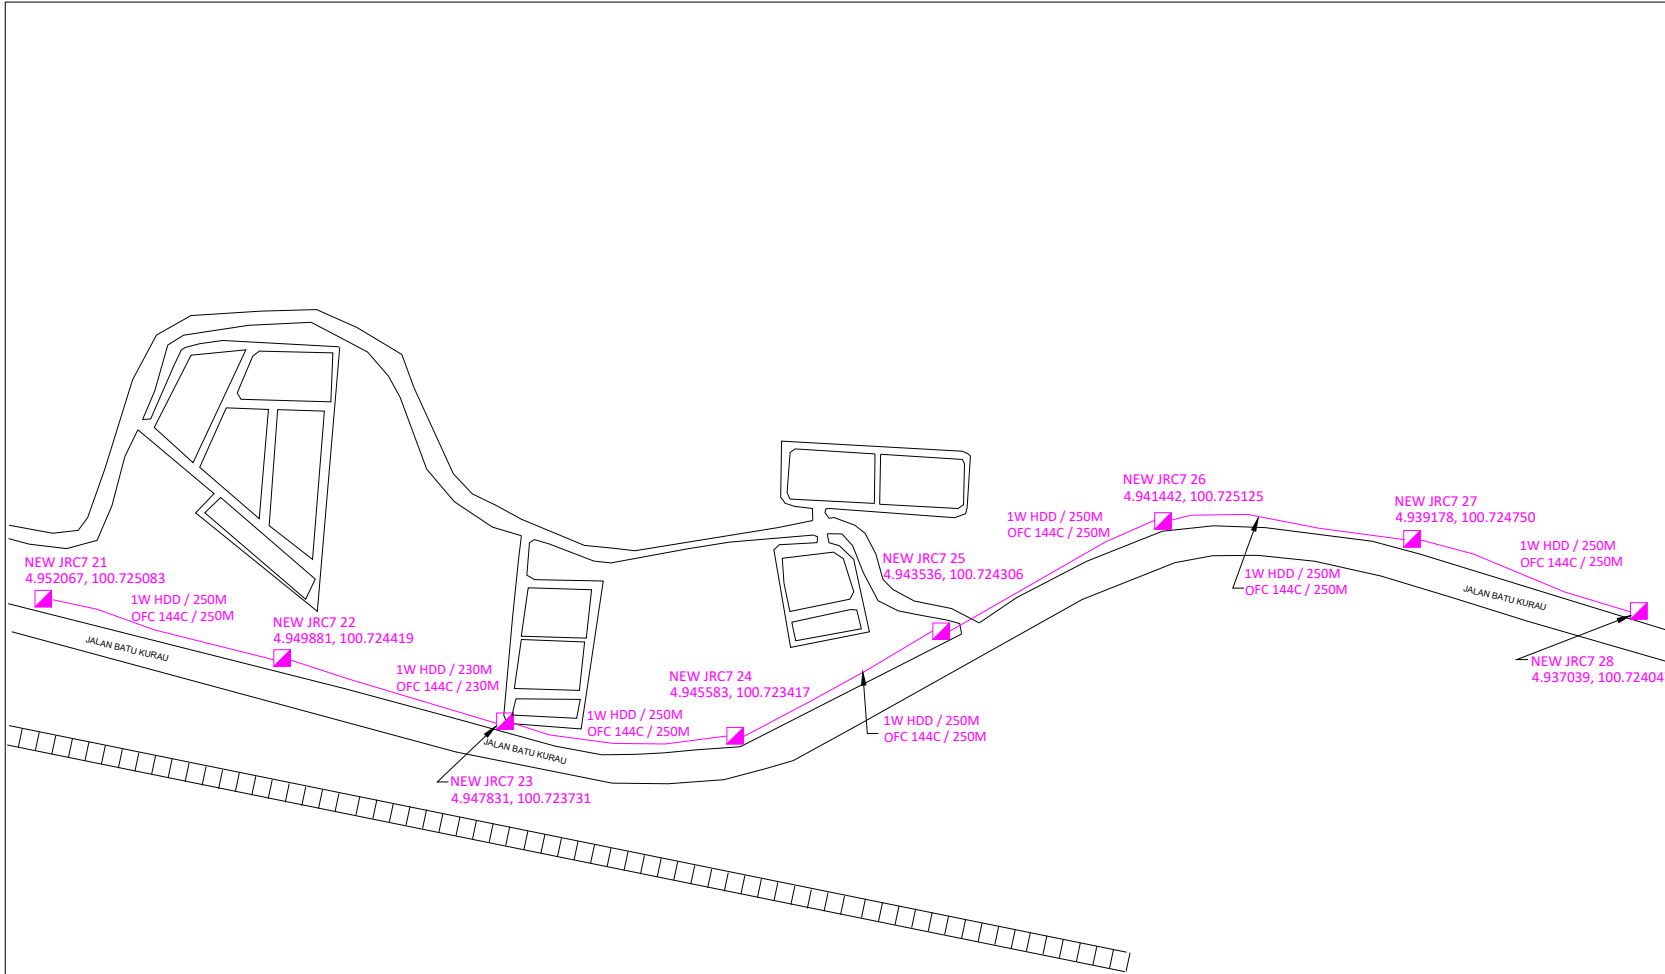

REV. NO.	REV. DATE	REV. BY

CONTRACTOR:



HOMEBASE NETWORK SDN BHD (1190247-H)
 No. D-02-03, Third Floor, Garden Shoppe @ One City,
 Jalan Usj 25/1A,
 47650 Subang Jaya, Selangor Darul Ehsan, Malaysia.



TT dotCom Sdn Bhd (52371-A)
 No 14, Jalan Majistret U1/26,
 Hicom Glenmarie Industrial Park
 40150 Shah Alam, Selangor Darul Ehsan, Malaysia.
 Tel: +60 3 5032 6000
 Website: www.time.com.my

PROJECT TITLE:
Kulim - Padang Rengas Package 2

DRAWING TITLE:
 SITE PLAN DRAWING
 (TECHNICAL PROPOSAL (TP) FOR LAST MILE LINK
 AND BUILDING ACCESS)

DRAWING NO: 00000 SHEET NO: 1 OF 1


DRAWING SCALE: N.T.S	DRAWING UNITS: METER
PREPARED BY: HOMEBASE	INITIAL & DATE: 18-7-2023
DESIGNED BY:	INITIAL & DATE: -
CHECKED BY: -	INITIAL & DATE: -
APPROVED BY:	INITIAL & DATE: -

KELULUSAN PLAN

Local Authorities:-

CONFIDENTIALITY

These drawings and details are and shall remain the property of TT dotCom Sdn Bhd. Both are issued in strict confidence and shall not be reproduced, copied or used in any manner without specific written permission from the owner.

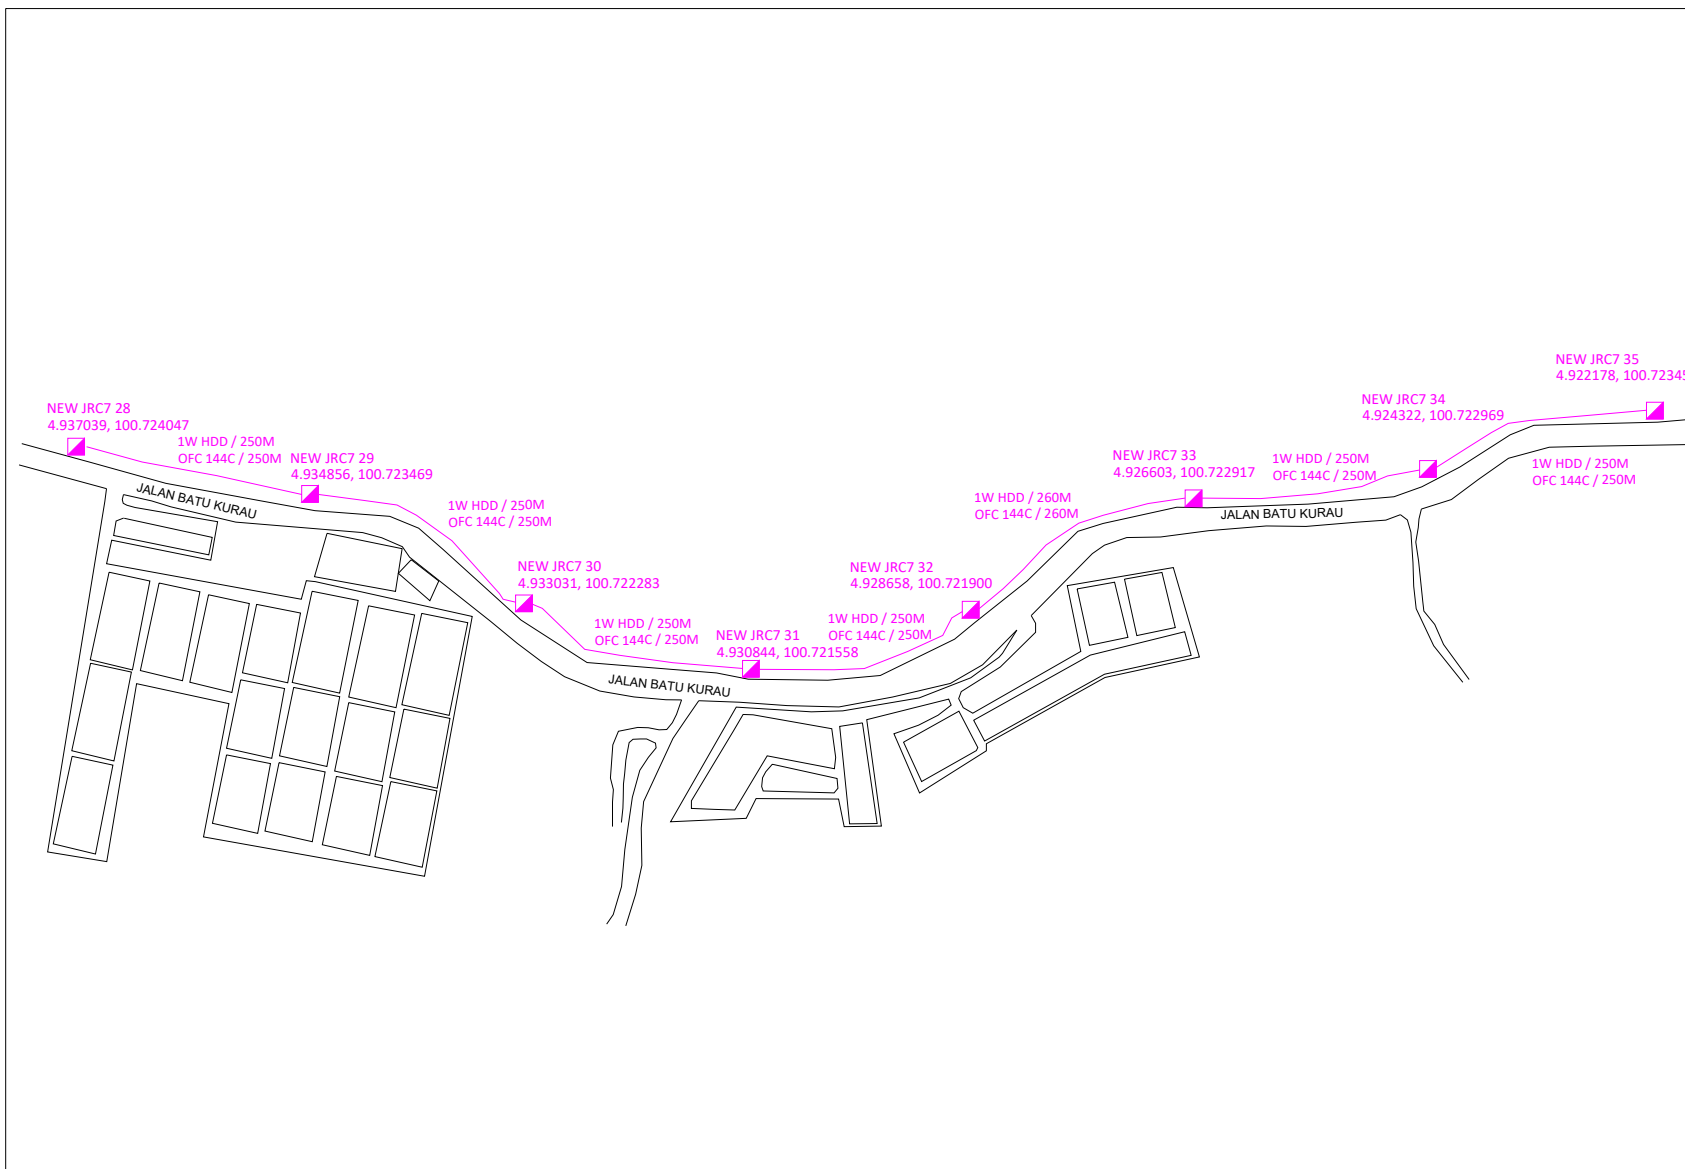

LEGEND :- OUTSIDE PLANT

- = PROPOSED MANHOLE
- = EXISTING TDC MANHOLE
- = 100MM GI PIPE
- = BUILDING MANHOLE
- 1W / 2W = 1 WAY OR 2 WAY DUCT
- GI = GALVANISED IRON DUCT
- PVC = PVC DUCT
- = HIDDEN DRAIN
- = VISIBLE DRAIN
- = TREES AND PLANTS
- = PROPOSED DUCT ROUTE
- = OFC 144C

SCHEDULE OF QUANTITY

SYMBOL	DESCRIPTION	QTY
	NEW JRC7	40

REV. NO.	REV. DATE	REV. BY

CONTRACTOR:



HOMEBASE NETWORK SDN BHD (1190247-H)
 No. D-02-03, Third Floor, Garden Shoppe @ One City,
 Jalan Usj 25/1A,
 47650 Subang Jaya, Selangor Darul Ehsan, Malaysia.

time™

TT dotCom Sdn Bhd (52371-A)
 No 14, Jalan Majistret U1/26,
 Hicom Glenmarie Industrial Park
 40150 Shah Alam, Selangor Darul Ehsan, Malaysia.
 Tel: +60 3 5032 6000
 Website: www.time.com.my

PROJECT TITLE:
Kulim - Padang Rengas Package 2

DRAWING TITLE:
 SITE PLAN DRAWING
 (TECHNICAL PROPOSAL (TP) FOR LAST MILE LINK
 AND BUILDING ACCESS)

DRAWING NO: 00000 | SHEET NO: 1 OF 1

DRAWING SCALE: N.T.S	DRAWING UNITS: METER
PREPARED BY: HOMEBASE	INITIAL & DATE: 18-7-2023
DESIGNED BY:	INITIAL & DATE: -
CHECKED BY:	INITIAL & DATE: -
APPROVED BY:	INITIAL & DATE: -










KELULUSAN PLAN

Local Authorities:-


CONFIDENTIALITY


These drawings and details are and shall remain the property of TT dotCom Sdn Bhd. Both are issued in strict confidence and shall not be reproduced, copied or used in any manner without specific written permission from the owner.

LEGEND :- OUTSIDE PLANT

-  = PROPOSED MANHOLE
-  = EXISTING TDC MANHOLE
-  = 100MM GI PIPE
-  = BUILDING MANHOLE
- 1W / 2W = 1 WAY OR 2 WAY DUCT
- GI = GALVANISED IRON DUCT
- PVC = PVC DUCT
-  = HIDDEN DRAIN
-  = VISIBLE DRAIN
-  = TREES AND PLANTS
-  = PROPOSED DUCT ROUTE
-  = OFC 144C

SCHEDULE OF QUANTITY

SYMBOL	DESCRIPTION	QTY
	NEW JRC7	40

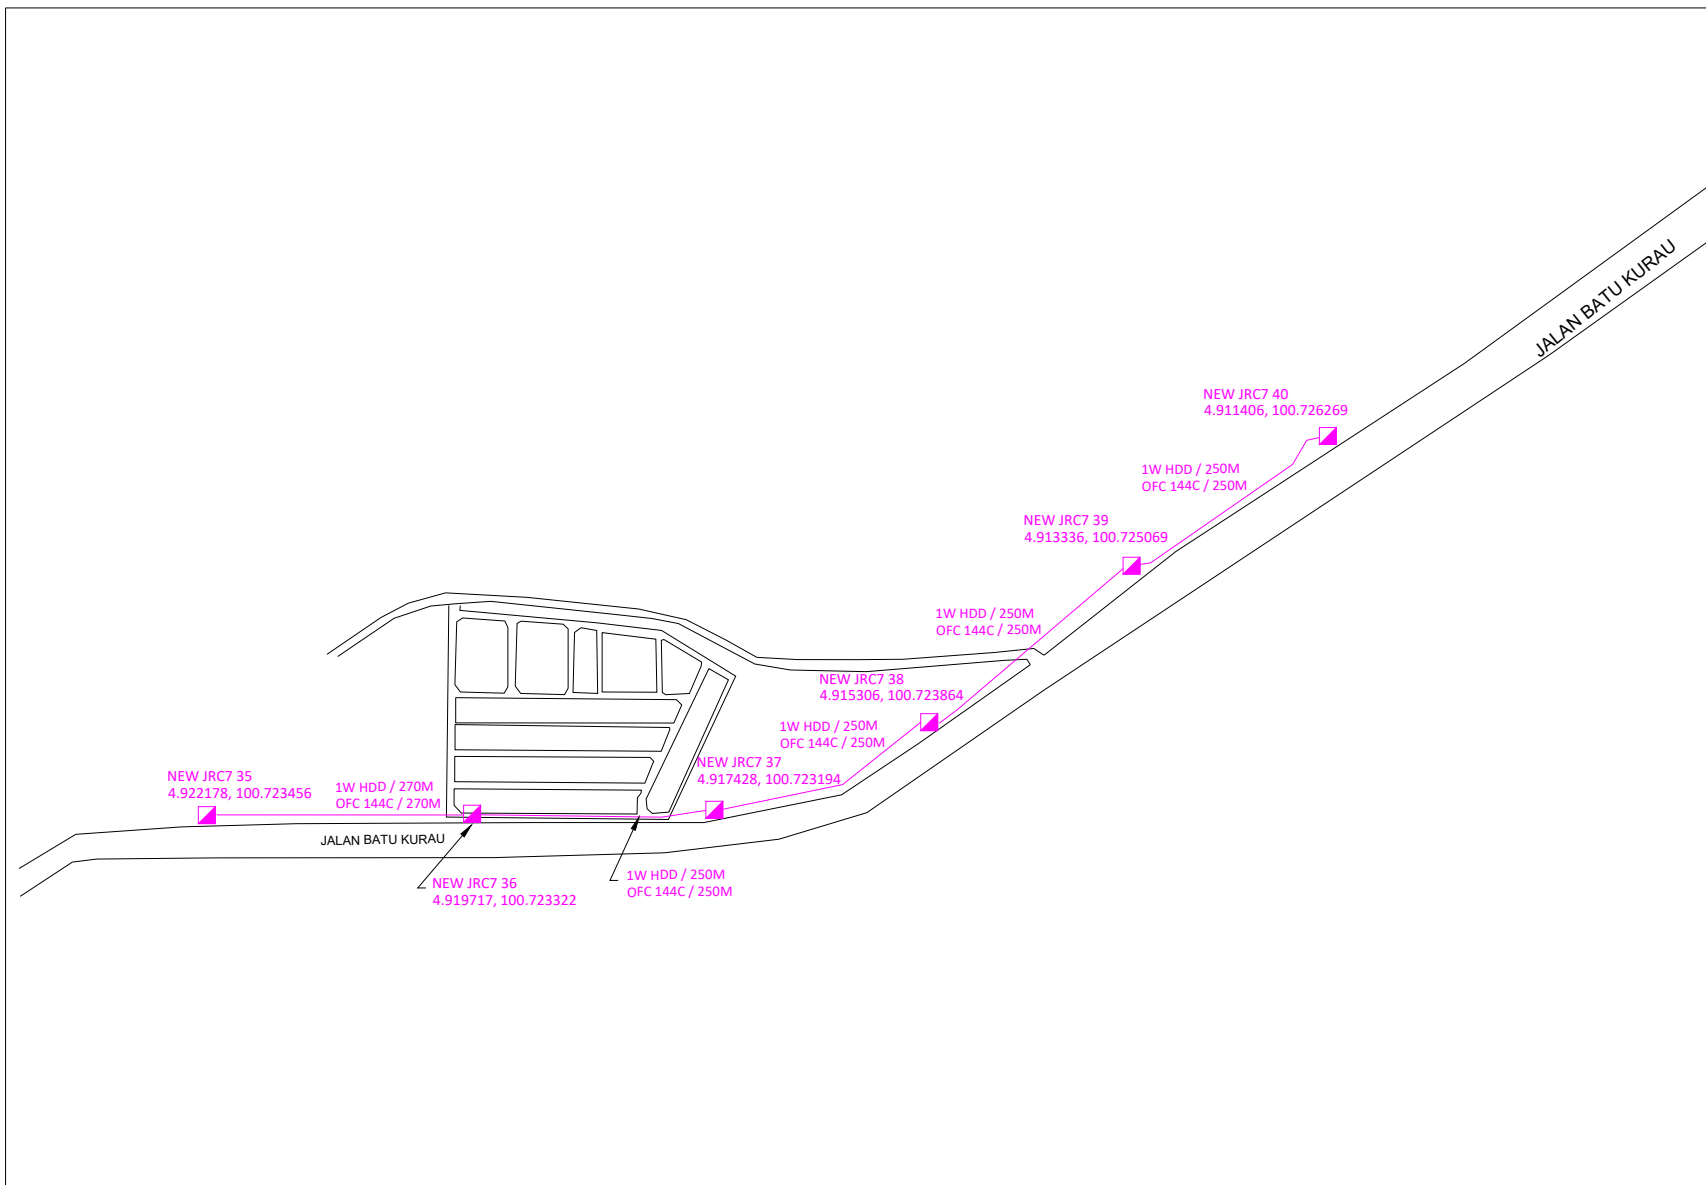

REV. NO.	REV. DATE	REV. BY

CONTRACTOR:



HOMEBASE NETWORK SDN BHD (1190247-H)
 No. D-02-03, Third Floor, Garden Shoppe @ One City,
 Jalan Usj 25/1A,
 47650 Subang Jaya, Selangor Darul Ehsan, Malaysia.



TT dotCom Sdn Bhd (52371-A)
 No 14, Jalan Majistret U1/26,
 Hicom Glenmarie Industrial Park
 40150 Shah Alam, Selangor Darul Ehsan, Malaysia.
 Tel: +60 3 5032 6000
 Website: www.time.com.my

PROJECT TITLE: Kulim - Padang Rengas Package 2
DRAWING TITLE: SITE PLAN DRAWING (TECHNICAL PROPOSAL (TP) FOR LAST MILE LINK AND BUILDING ACCESS)
DRAWING NO: 000000 SHEET NO: 1 OF 1

DRAWING SCALE: N.T.S	DRAWING UNITS: METER
PREPARED BY: HOMEBASE	INITIAL & DATE: 18-7-2023
DESIGNED BY:	INITIAL & DATE: -
CHECKED BY: -	INITIAL & DATE: -
APPROVED BY:	INITIAL & DATE: -