


 **MAXIS BROADBAND SDN BHD**
 Tingkat 8, Block 1A, Plaza Central,
 Jalan Stesen Central 5,
 Kuala Lumpur Central,
 50470 Kuala Lumpur.

TITLE:
 SITE PLAN
 KIPC, KERTEH

Designed by:
Prepared by:
Job No:

Approved by:
Sheet No:
Rev:

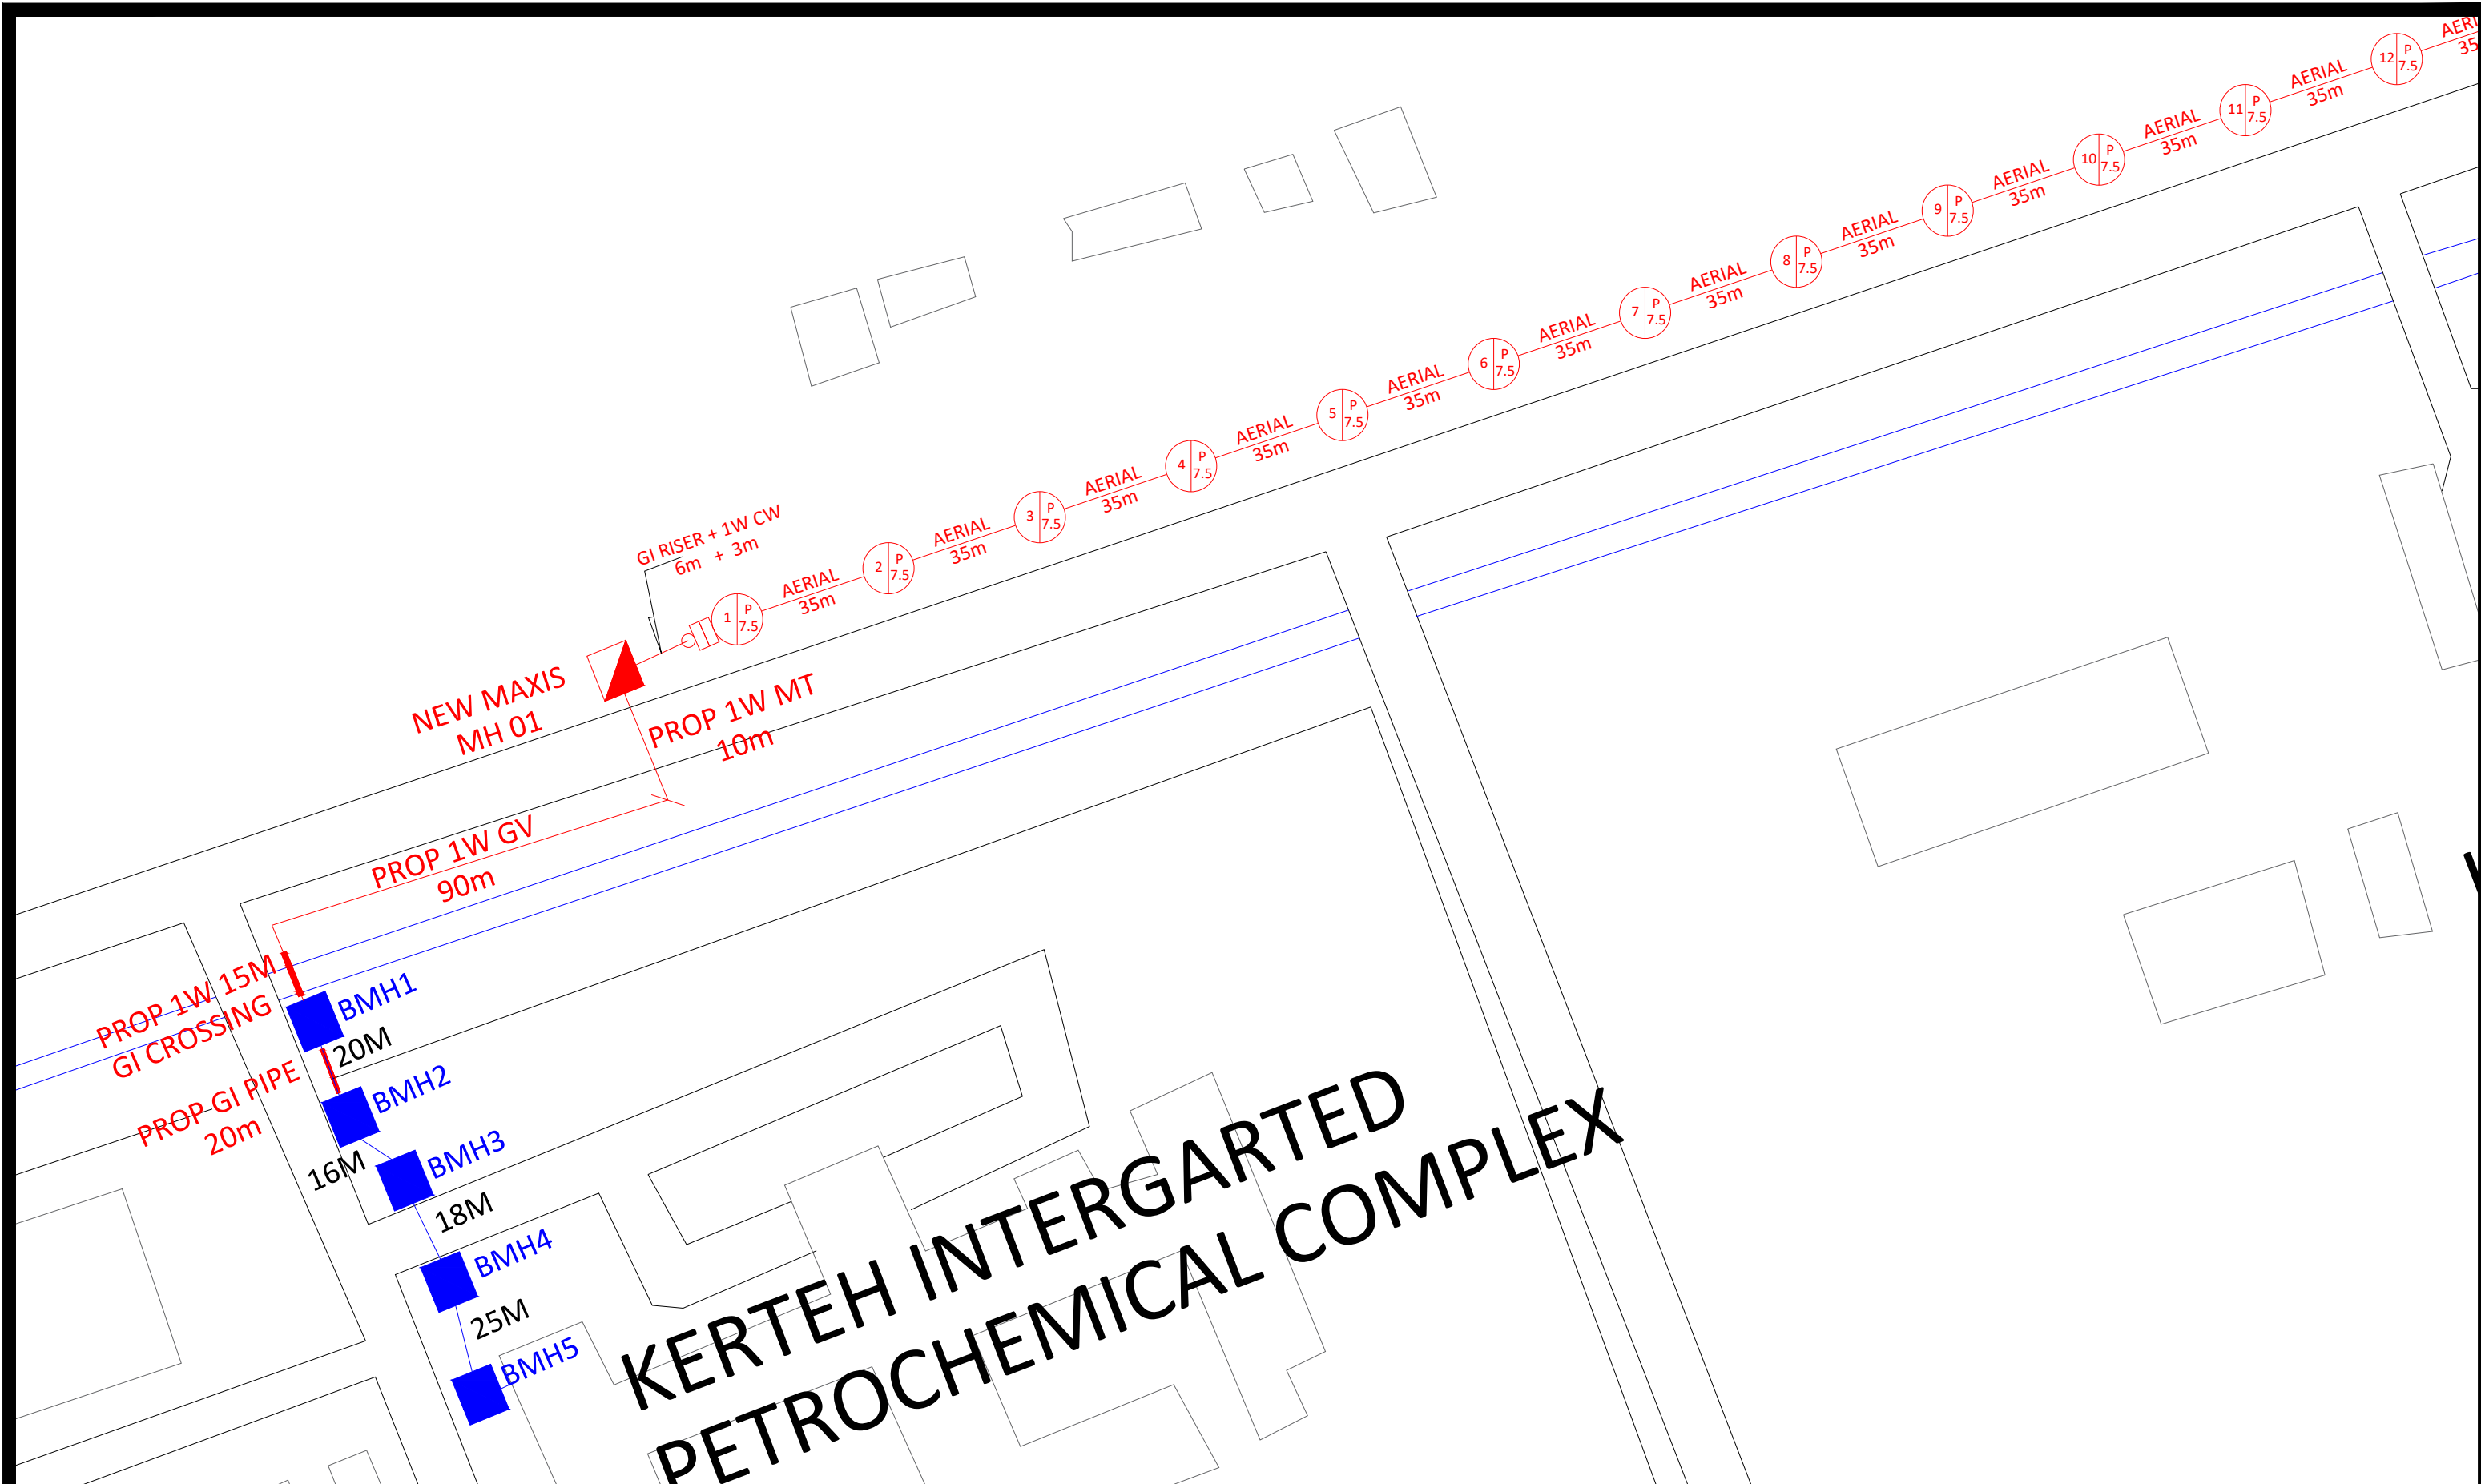

KERTEH INTERGARTED PETROCHEMICAL COMPLEX




MAXIS BROADBAND SDN BHD
 Tingkat 8, Block 1A, Plaza Central,
 Jalan Stesen Central 5,
 Kuala Lumpur Central,
 50470 Kuala Lumpur.

TITLE:
 SITE PLAN
 KIPC, KERTEH

Designed by:
Prepared by:
Job No:

Approved by:
Sheet No:
Rev:

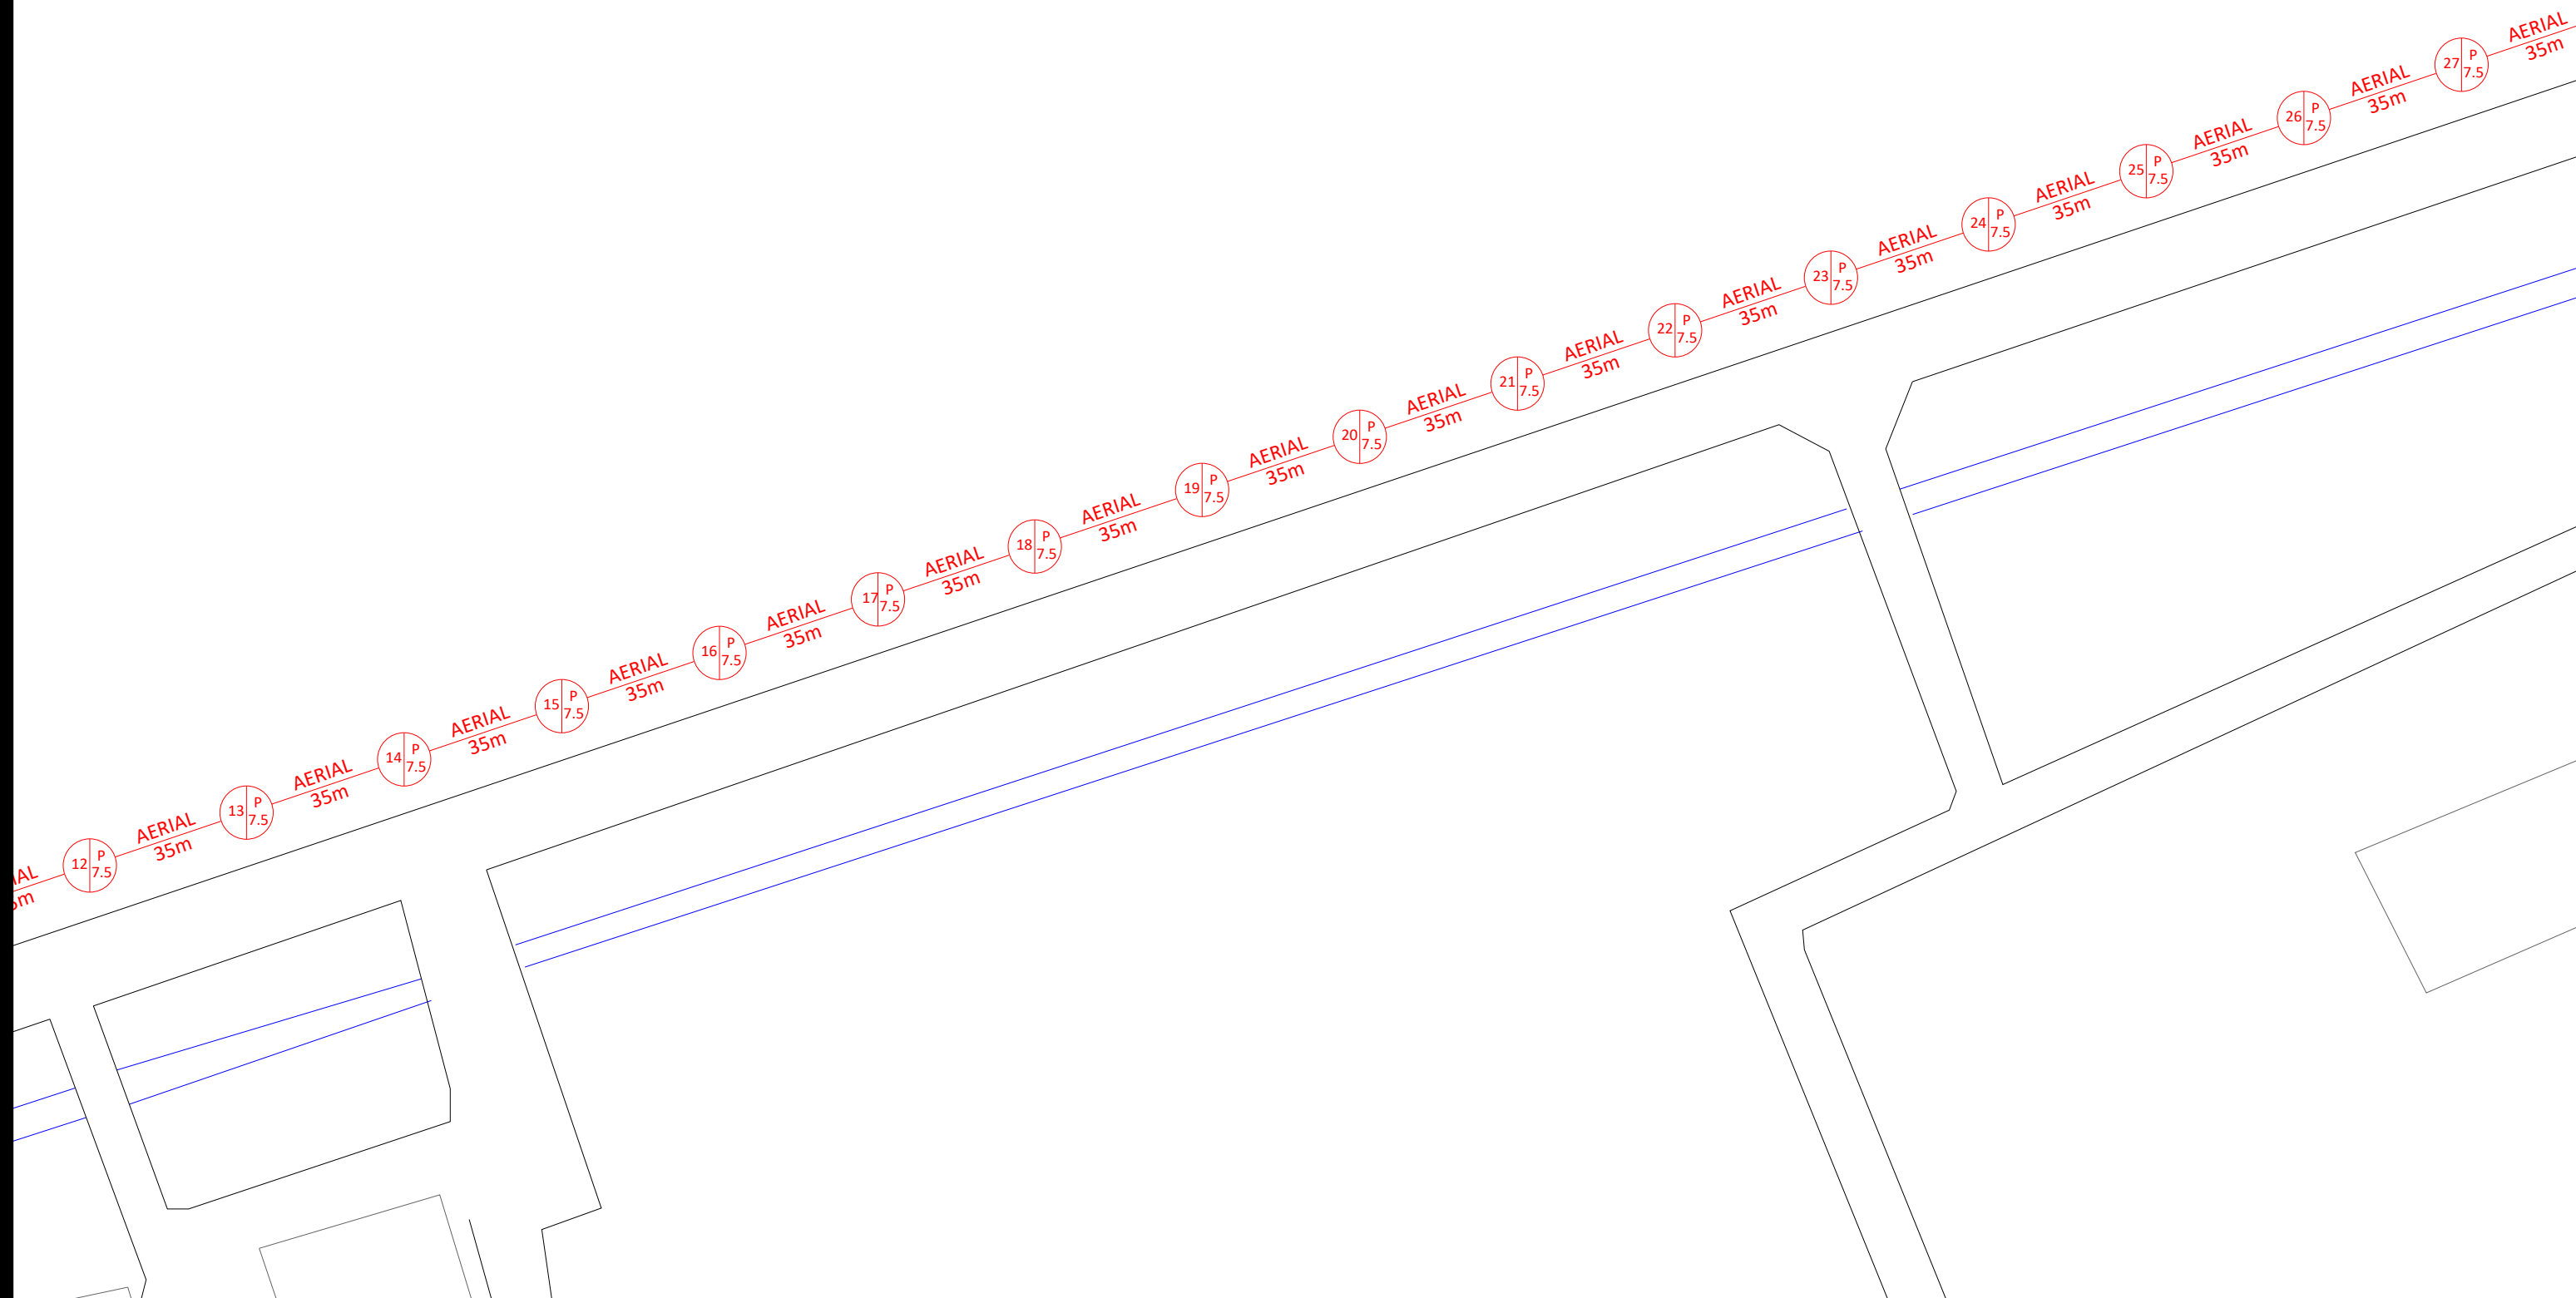

MAXIS BROADBAND SDN BHD
 Tingkat 8, Block 1A, Plaza Central,
 Jalan Stesen Central 5,
 Kuala Lumpur Central,
 50470 Kuala Lumpur.

TITLE:
 SITE PLAN
 KIPC, KERTEH

Designed by:


Prepared by:

Job No:

Approved by:

Sheet No:

Rev:

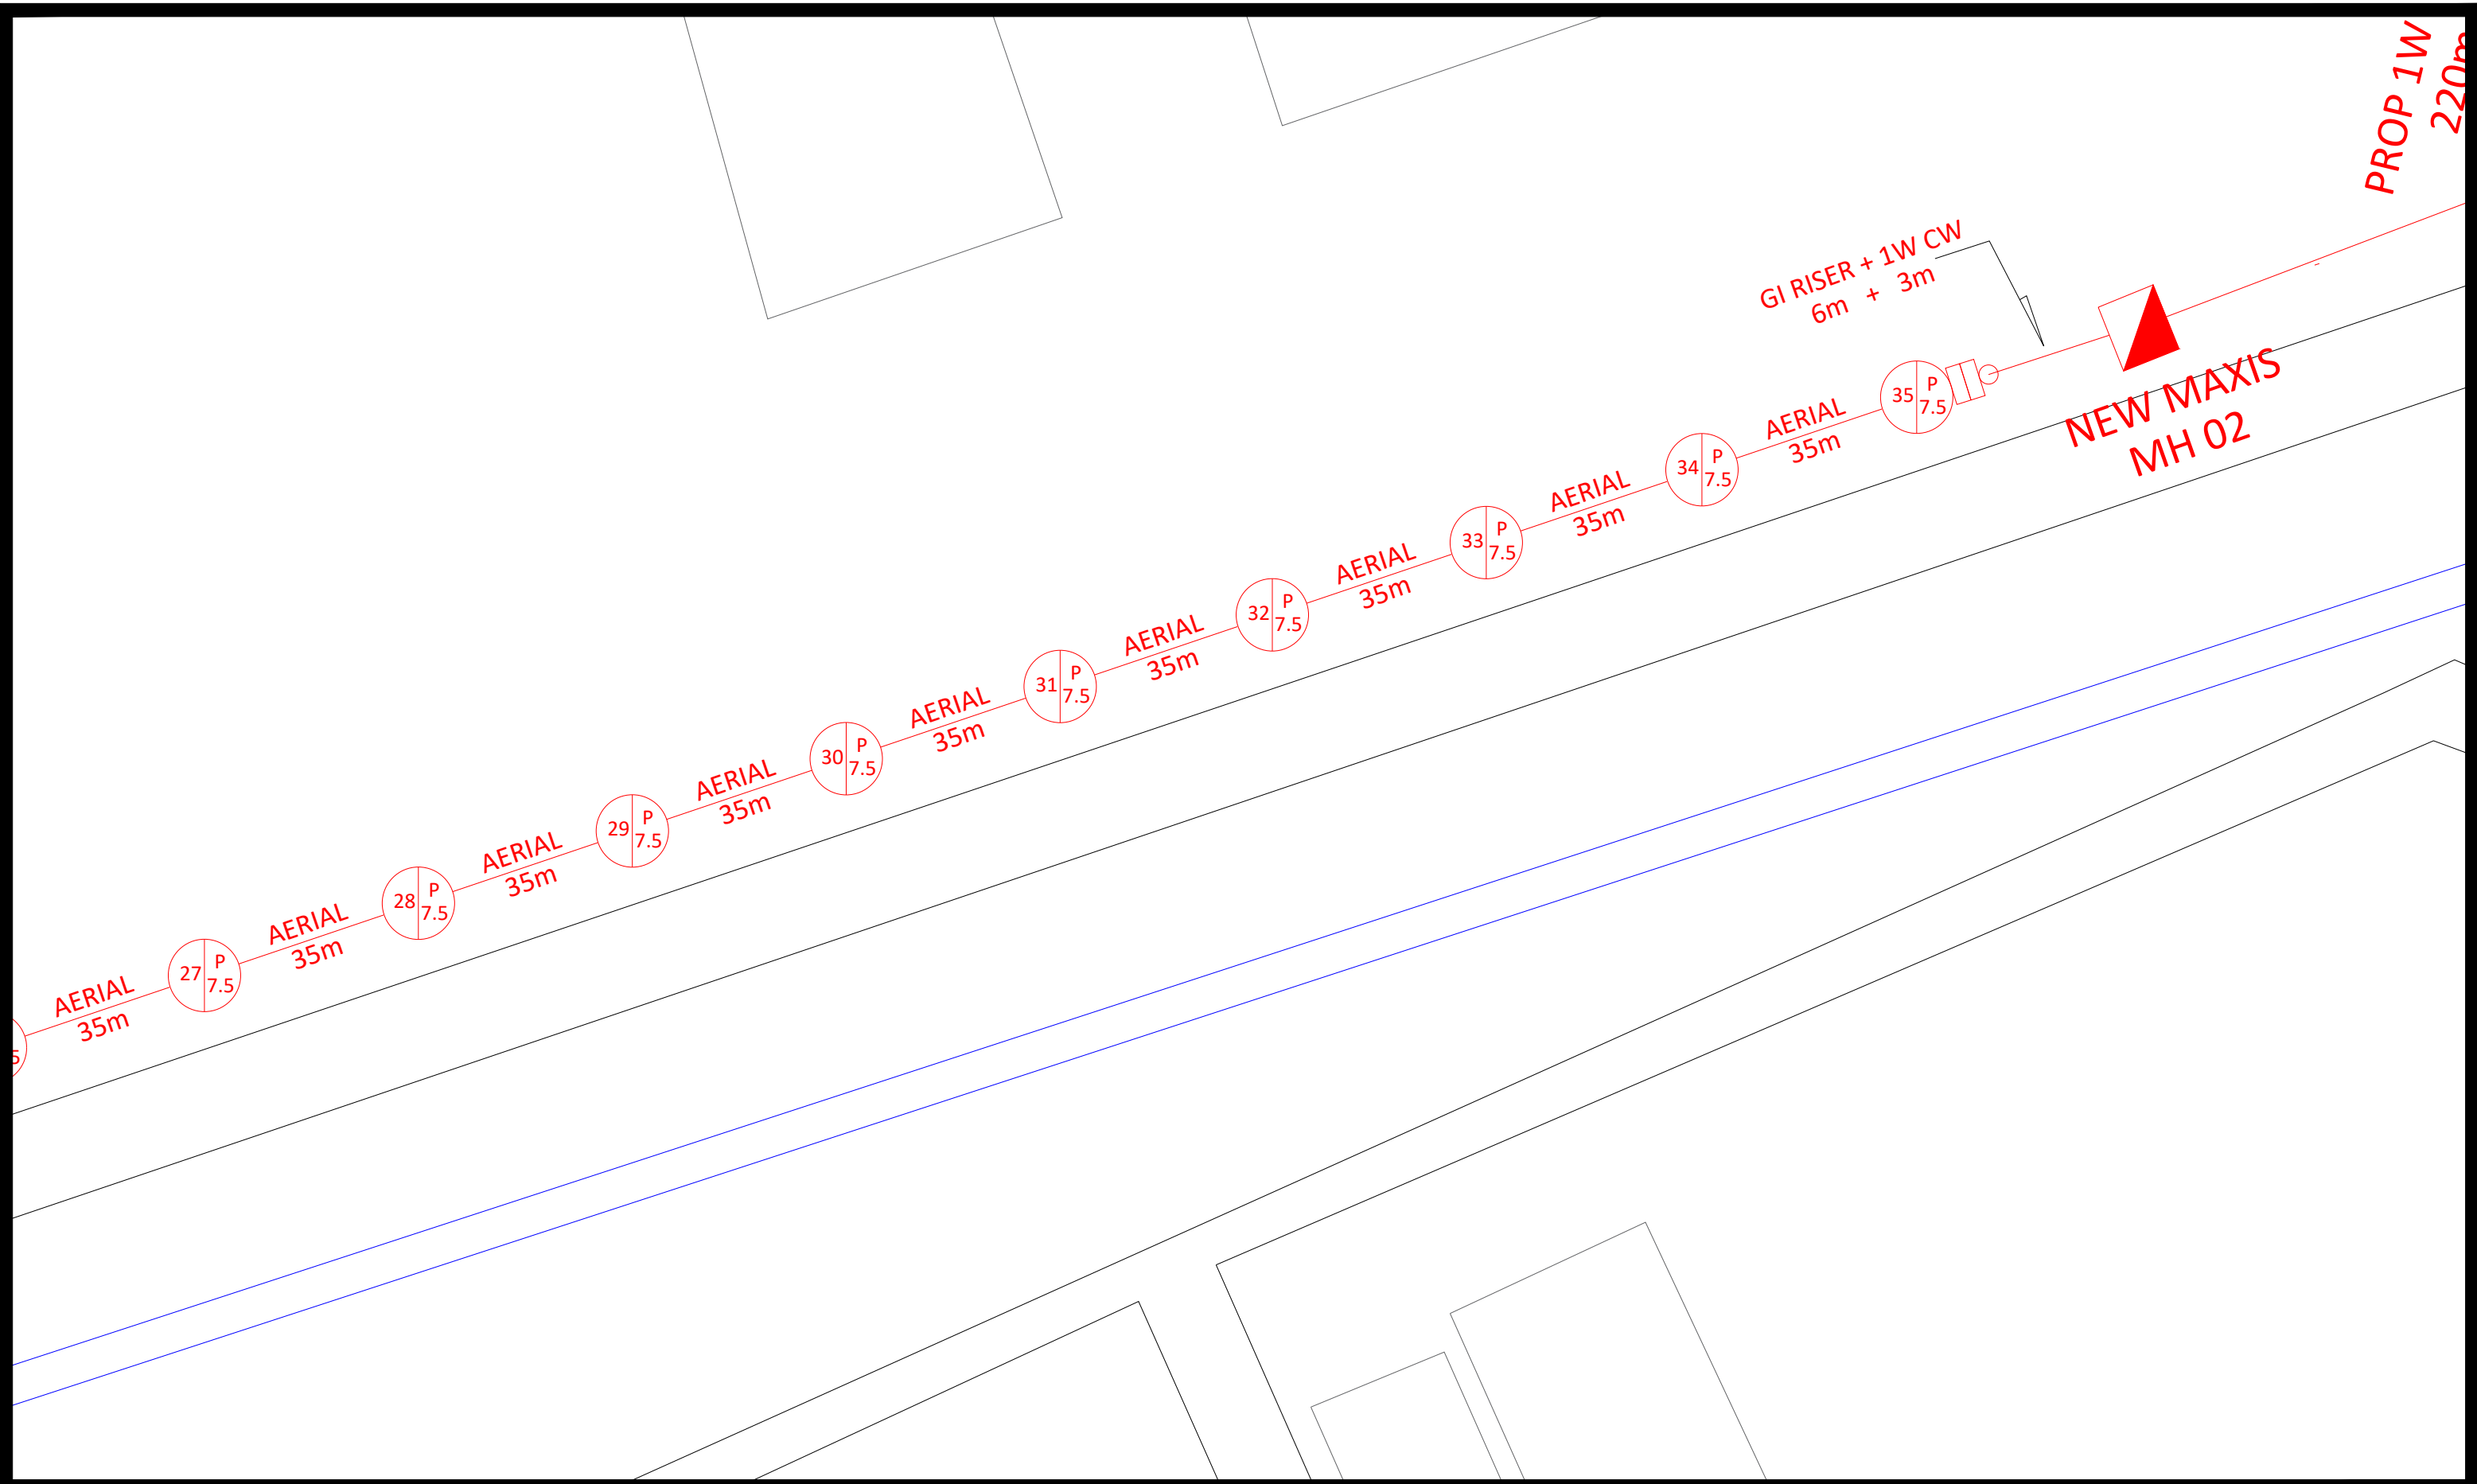

MAXIS BROADBAND SDN BHD
 Tingkat 8, Block 1A, Plaza Central,
 Jalan Stesen Central 5,
 Kuala Lumpur Central,
 50470 Kuala Lumpur.

TITLE:
 SITE PLAN
 KIPC, KERTEH

Designed by:


Prepared by:

Job No:

Approved by:

Sheet No:

Rev:

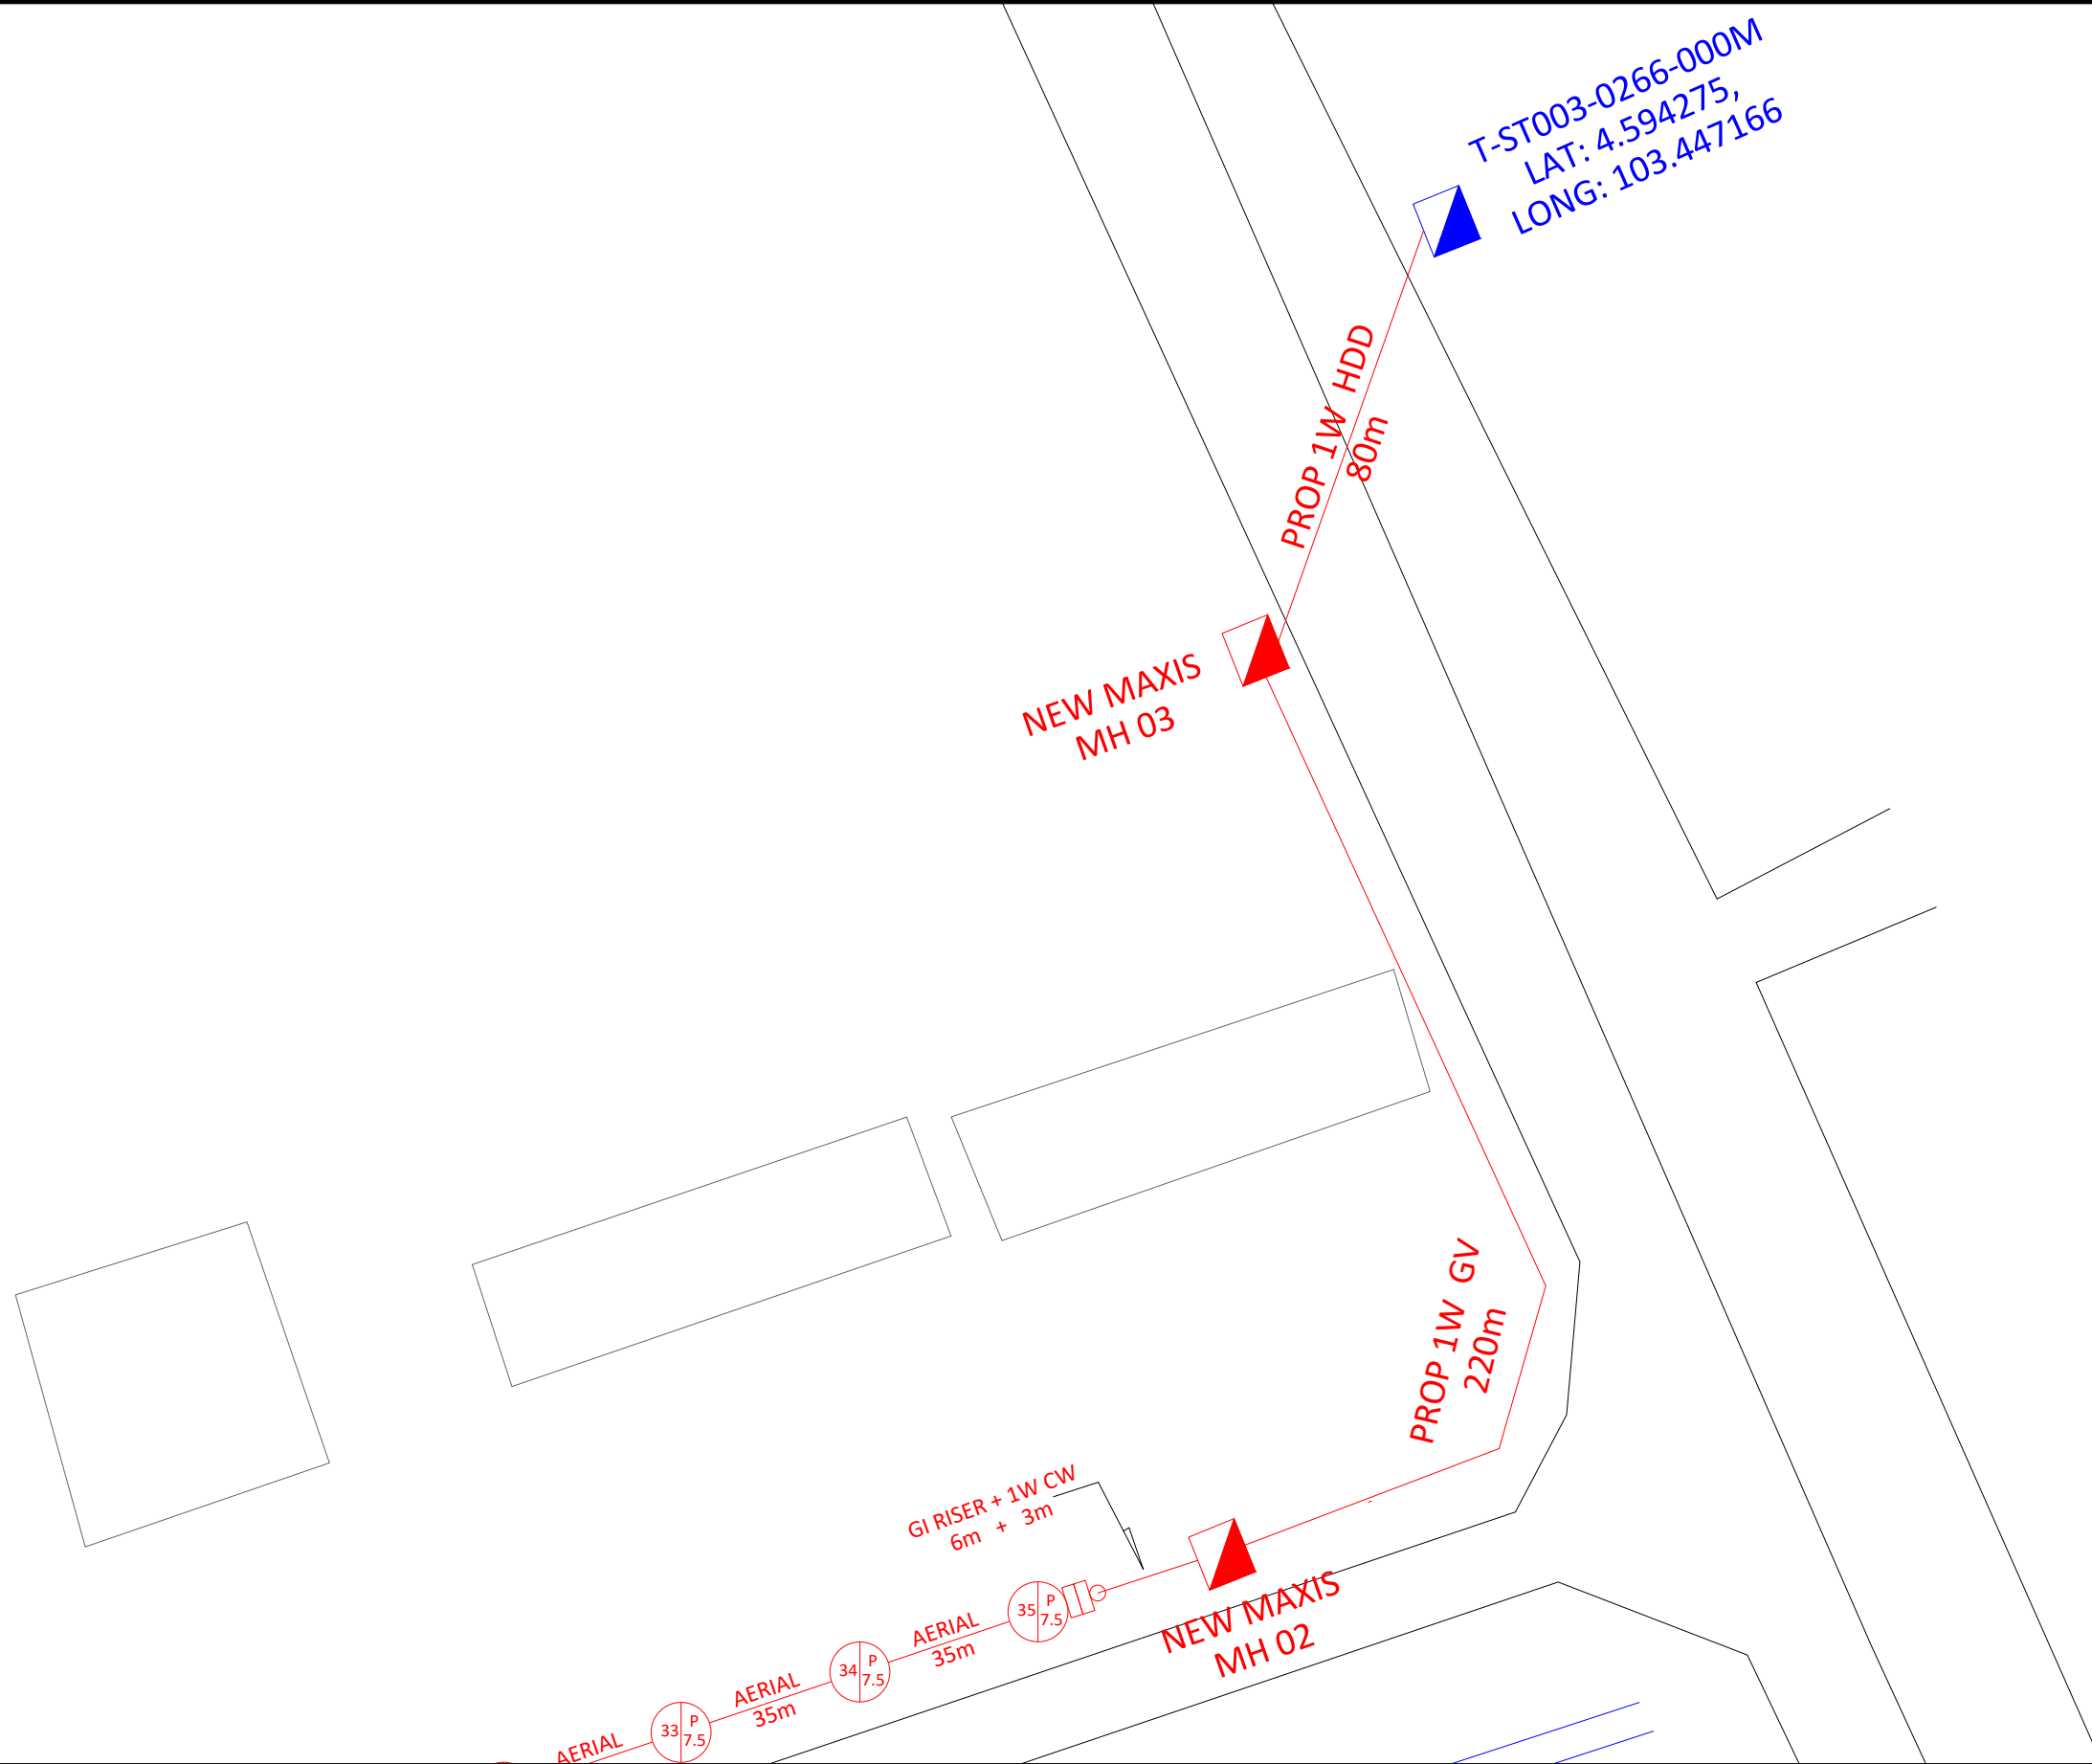

T-ST003-0266-000M
 LAT: 4.594275,
 LONG: 103.447166

NEW MAXIS
 MH 03

PROP 1W HDD
 80m

PROP 1W GV
 220m

GI RISER + 1W CW
 6m + 3m

NEW MAXIS
 MH 02

AERIAL 33 P 7.5

AERIAL 34 P 7.5

AERIAL 35 P 7.5



MAXIS BROADBAND SDN BHD
 Tingkat 8, Block 1A, Plaza Central,
 Jalan Stesen Central 5,
 Kuala Lumpur Central,
 50470 Kuala Lumpur.

TITLE:
 SITE PLAN
 KIPC, KERTEH

Designed by:

Prepared by:

Job No:

Approved by:


Sheet No:

Rev:

T-ST003-0266-000M
 LAT: 4.594275,
 LONG: 103.447166

NEW MAXIS
 MH 03

PROP 1W HDD
 80m

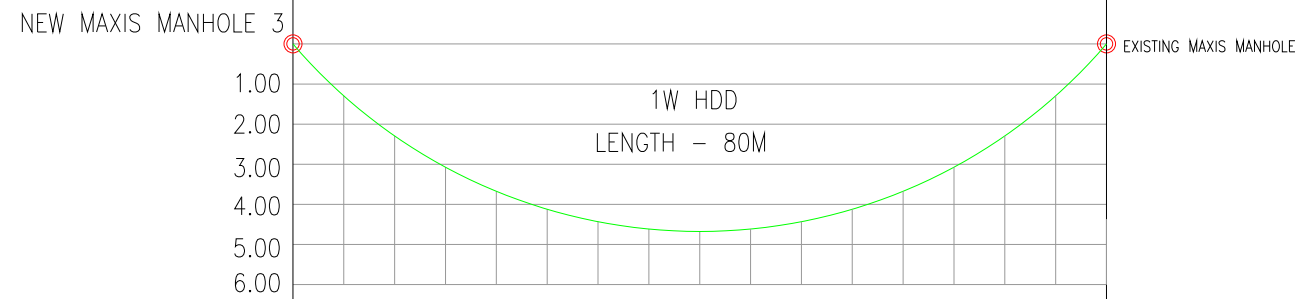

HORIZONTAL DISTANCE	0.00	5.00	10.00	15.00	20.00	25.00	30.00	35.00	40.00	45.00	50.00	55.00	60.00	65.00	70.00	75.00	80.00
HDD BOREPILE PROFILE	0.00	1.35	2.50	3.15	3.75	4.20	4.70	4.90	4.95	4.90	4.70	4.20	3.75	3.15	2.50	1.35	0.00

Vertical Scale - 1:1
 Horizontal Scale - 1:5

SITE NAME: Kerteh Integrated Petrochemical Complex	
TITLE: HDD PROFILE (80M)	
LEGENDS	
	FDC/FDF
	EXISTING FDC/FDF
	PROPOSED MANHOLE
	EXISTING MANHOLE
	NEW JOINT BOX/PIT
	EXISTING JOINT BOX/PIT
	DUCT RISER 4"
	PEDESTAL
	PROPOSED POLE
	EXISTING POLE
	SPLITTER 1:2
	SPLITTER 1:32
	ATB
	FDP
	EXISTING FDP
	CLOSURE
	NEW DUCTWAY/UG CABLE
	EXISTING DUCTWAY/UG CABLE
	NEW UG/ARIAL/DROP CABEL
	FDC BOUNDARY
	FDP BOUNDARY
REV:	DATE:



Verdenetworks Solutions Sdn. Bhd