

- NOTES :
1. ALL DIMENSIONS SHALL BE IN MILIMETER (MM) UNLESS NOTED OTHERWISE.
  2. TITIK MULA (GLT CLIMATE SDN BHD)  
(4.924636, 101.107456)
  3. TITIK AKHIR (PPU LINTANG, SUNGAI SIPUT)  
(4.936792, 101.105059)

TNB MINI PPU LINTANG, SUNGAI SIPUT  
GPS: 4.936792, 101.105059


REV. NO	DATE	REMARK

PROPRIETARY INFORMATION :  
THE INFORMATION IN THIS DOCUMENT/ DRAWING IS THE PROPERTY OF GLT DESIGN BUILD SDN. BHD. IS SUBJECTED TO RETURN UPON DEMAND AND MAY NOT BE REPRODUCED OR DISCLOSED TO OTHERS WITHOUT THE WRITTEN CONSENT OF GLT DESIGN BUILD SDN. BHD.


PROJECT:  
**DESIGN, SUPPLY, FABRICATION, CONSTRUCTION, DELIVERY TO SITE, INSTALLATION, COMPLETION, TESTING AND COMMISSIONING AND GUARANTEE THE PERFORMANCE OF 1 MW BIOGAS POWER PLANT AT GLT CLIMATE SDN BHD, SUNGAI SIPUT, PERAK**

PROJECT OWNER:  
**GLT CLIMATE SDN BHD**  
H-3A-01,  
PUSAT PERDAGANGAN BANDAR BUKIT JALIL,  
PERSIARAN JALIL 1,  
57000, KUALA LUMPUR, MALAYSIA  
TEL : +6 03- 2733 2960  
FAX : +6 03- 2733 2961

EPC CONTRACTOR:  
**GLT DESIGN BUILD SDN BHD**  
H-3A-01,  
PUSAT PERDAGANGAN BANDAR BUKIT JALIL,  
PERSIARAN JALIL 1,  
57000, KUALA LUMPUR, MALAYSIA  
TEL : +6 03- 2733 2960  
FAX : +6 03- 2733 2961

TITLE  
PETA PENANDAAN LOKASI

DRAWN LED	DESIGNED LED	APPROVED HYS
DATE 30 OCT, 2025	SCALE 1:2700	
DRAWING NO DB2505-GLTC(2)-KUDR-001	REV NO 0	SHEET 1/2

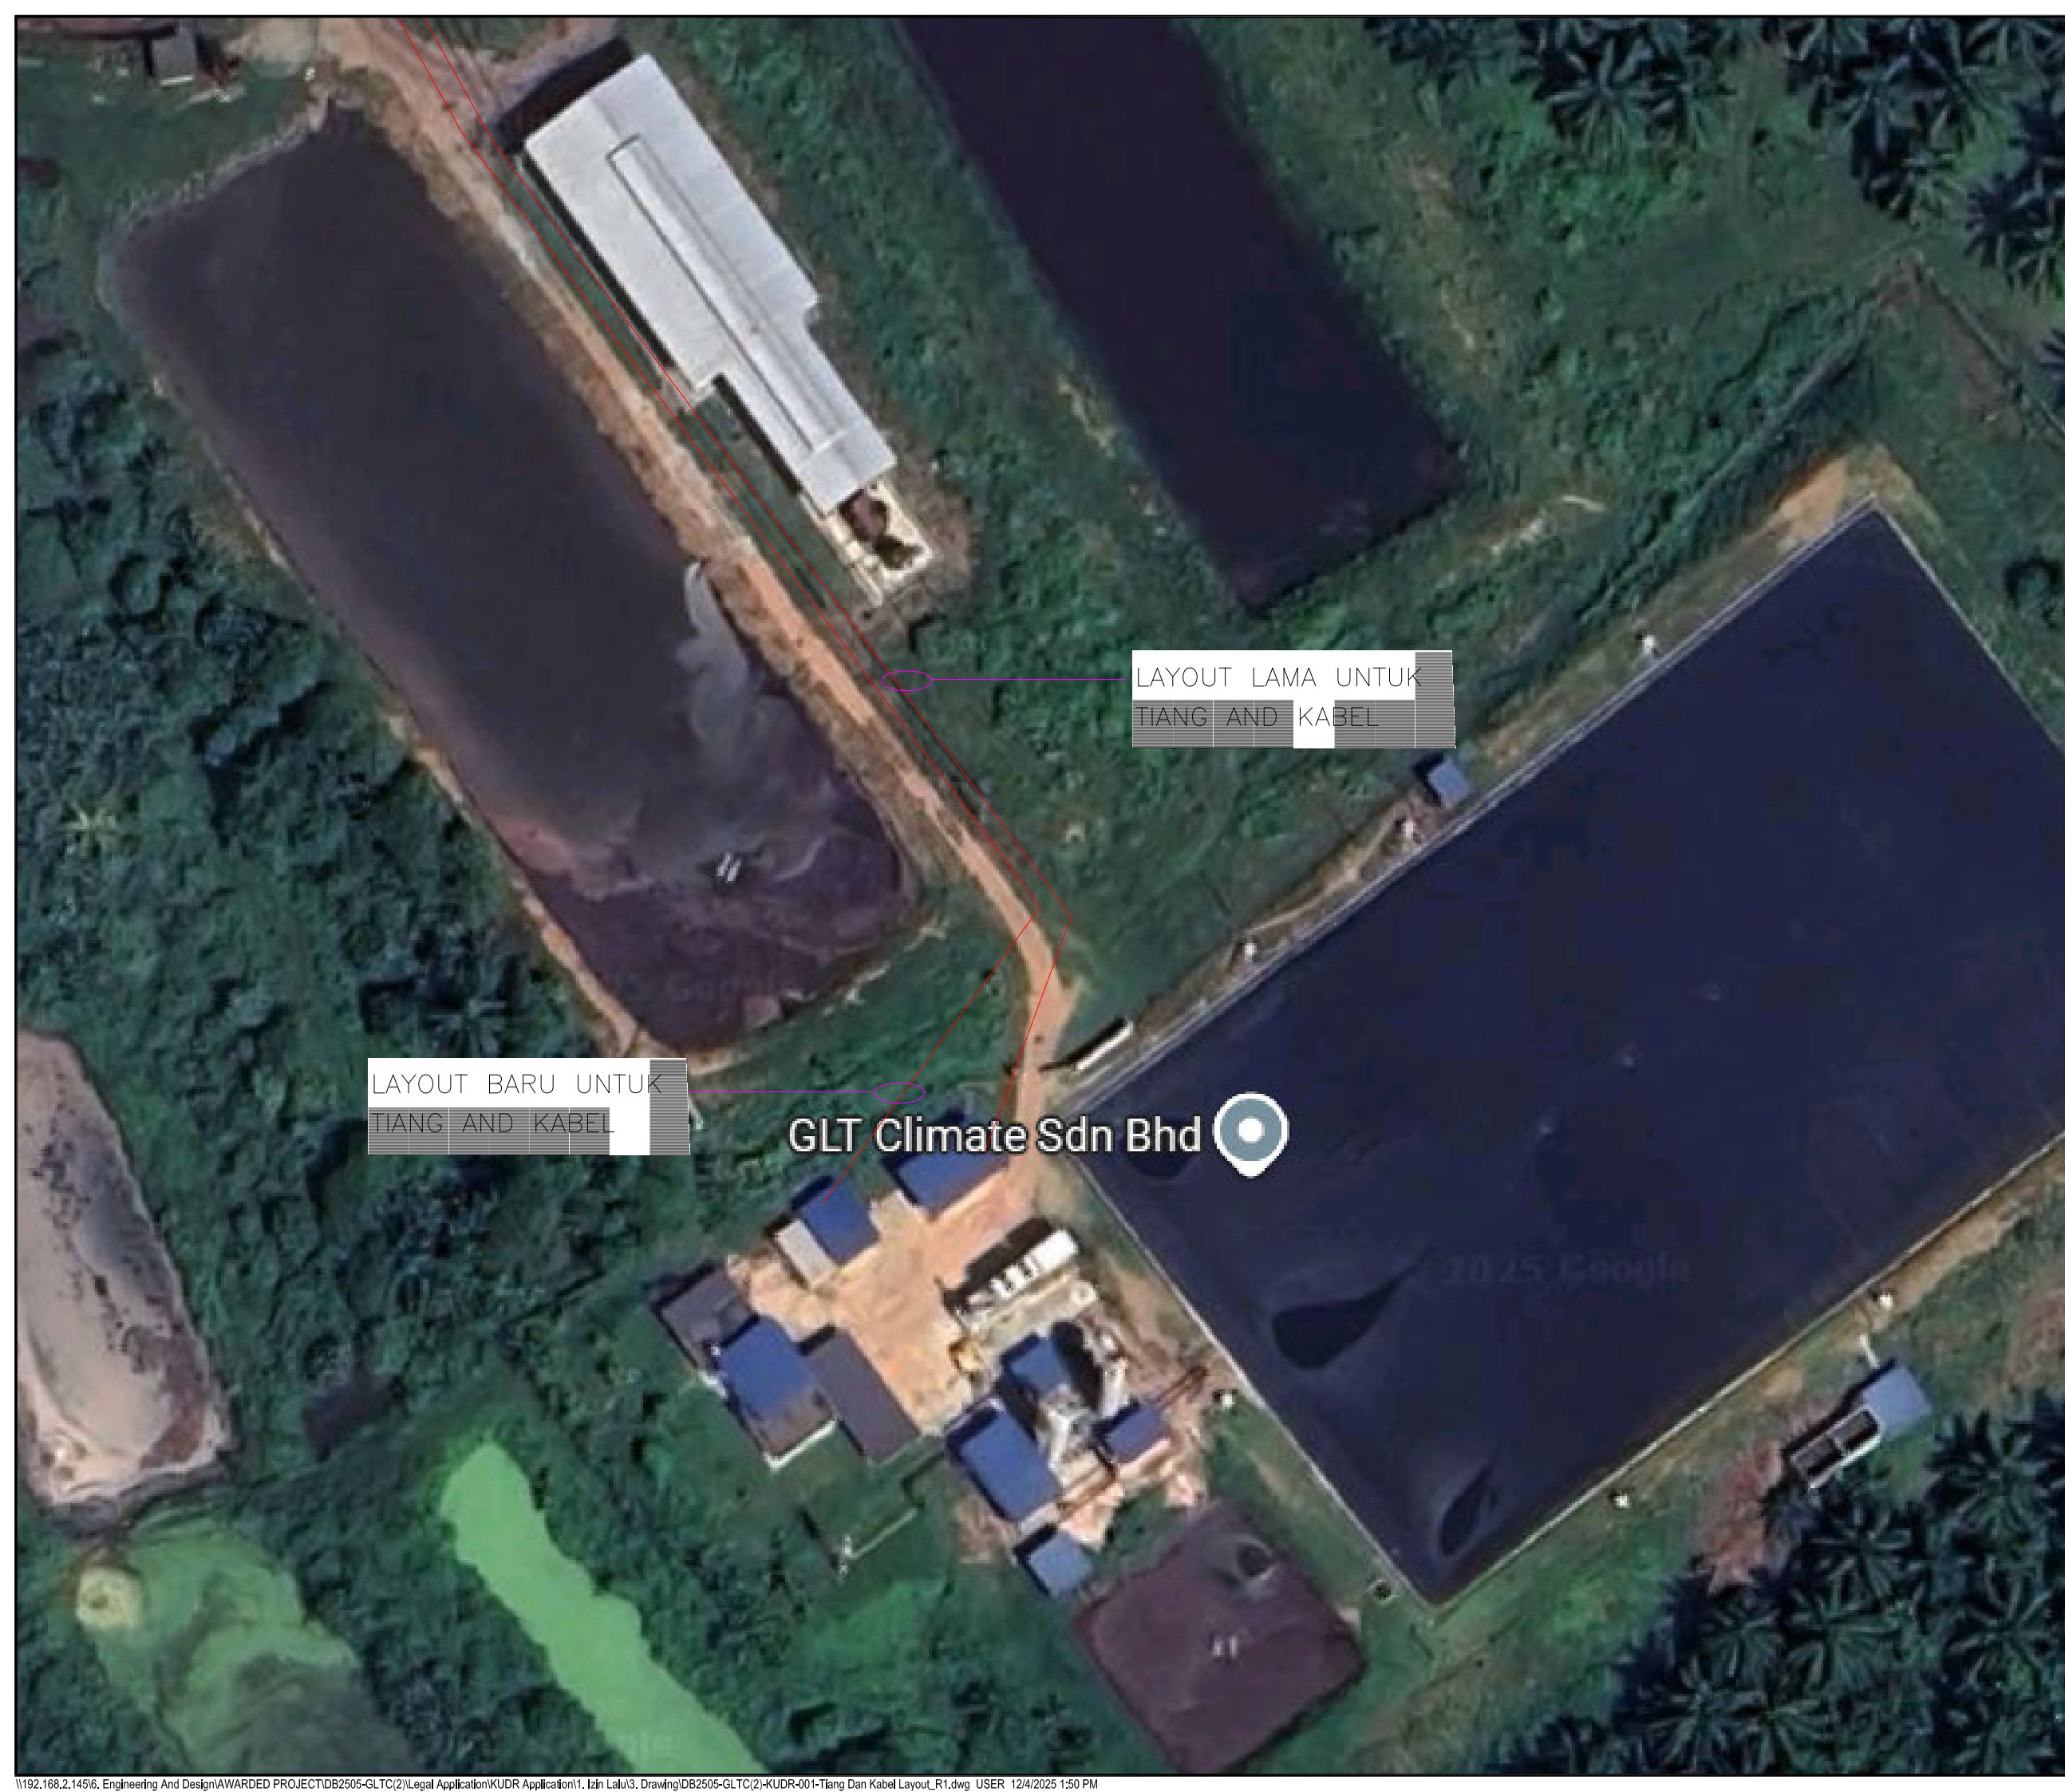

LAYOUT LAMA UNTUK  
TIANG AND KABEL

LAYOUT BARU UNTUK  
TIANG AND KABEL

GLT Climate Sdn Bhd

NOTES :  
1. ALL DIMENSIONS SHALL BE IN MILIMETER (MM) UNLESS NOTED OTHERWISE.  
2. SETIAP JARAK TIANG ADALAH LEBIH KURANG 20 METER


REV. NO	DATE	REMARK

PROPRIETARY INFORMATION :  
THE INFORMATION IN THIS DOCUMENT/ DRAWING IS THE PROPERTY OF GLT DESIGN BUILD SDN. BHD. IS SUBJECTED TO RETURN UPON DEMAND AND MAY NOT BE REPRODUCED OR DISCLOSED TO OTHERS WITHOUT THE WRITTEN CONSENT OF GLT DESIGN BUILD SDN. BHD.

PROJECT:  
**DESIGN, SUPPLY, FABRICATION, CONSTRUCTION, DELIVERY TO SITE, INSTALLATION, COMPLETION, TESTING AND COMMISSIONING AND GUARANTEE THE PERFORMANCE OF 1 MW BIOGAS POWER PLANT AT GLT CLIMATE SDN BHD, SUNGAI SIPUT, PERAK**

PROJECT OWNER:  
**GLT CLIMATE SDN BHD**  
H-3A-01,  
PUSAT PERDAGANGAN BANDAR BUKIT JALIL,  
PERSIARAN JALIL 1,  
57000, KUALA LUMPUR, MALAYSIA  
TEL : +6 03- 2733 2960  
FAX : +6 03- 2733 2961

EPCC CONTRACTOR:  
**GLT DESIGN BUILD SDN BHD**  
H-3A-01,  
PUSAT PERDAGANGAN BANDAR BUKIT JALIL,  
PERSIARAN JALIL 1,  
57000, KUALA LUMPUR, MALAYSIA  
TEL : +6 03- 2733 2960  
FAX : +6 03- 2733 2961

TITLE  
TIANG AND KABEL LAYOUT

DRAWN LED	DESIGNED LED	APPROVED HYS
DATE 04 DEC, 2025	SCALE 1:300	
DRAWING NO DB2505-GLTC(2)-KUDR-001	REV. NO 1	SHEET 2/2

Jambatan Kampung Lintang ( Sg. Siput ( U...  
Recently viewed



A20

A19



PPU LINTANG SUNGAI SIPUT

KAMPUNG CHERAKOH

Lintang Health Clinic



MENANAM TIANG & TALIAN SESALUR DI ATAS TIANG (DARI GLT CLIMATE SDN BHD KE PPU LINTANG) 2.7KM  
SETIAP JARAK TIANG ADALAH LEBIH KURANG 20 METER

A19

A19

GLT Climate Sdn Bhd  
Recently viewed




- NOTES :
1. ALL DIMENSIONS SHALL BE IN MILIMETER (MM) UNLESS NOTED OTHERWISE.
  2. SETIAP JARAK TIANG ADALAH LEBIH KURANG 20 METER
- Ⓟ PROPOS LOKASI TIANG


REV. NO	DATE	REMARK

PROPRIETARY INFORMATION :  
THE INFORMATION IN THIS DOCUMENT/ DRAWING IS THE PROPERTY OF GLT DESIGN BUILD SDN. BHD. IS SUBJECT TO RETURN UPON DEMAND AND MAY NOT BE REPRODUCED OR DISCLOSED TO OTHERS WITHOUT THE WRITTEN CONSENT OF GLT DESIGN BUILD SDN. BHD.


PROJECT:  
**DESIGN, SUPPLY, FABRICATION, CONSTRUCTION, DELIVERY TO SITE, INSTALLATION, COMPLETION, TESTING AND COMMISSIONING AND GUARANTEE THE PERFORMANCE OF 1 MW BIOGAS POWER PLANT AT GLT CLIMATE SDN BHD, SUNGAI SIPUT, PERAK**

PROJECT OWNER:  
**GLT CLIMATE SDN BHD**  
  
H-3A-01,  
PUSAT PERDAGANGAN BANDAR BUKIT JALIL,  
PERSIARAN JALIL 1,  
57000, KUALA LUMPUR, MALAYSIA  
TEL : +6 03- 2733 2960  
FAX : +6 03- 2733 2961



EPC CONTRACTOR:  
**GLT DESIGN BUILD SDN BHD**  
  
H-3A-01,  
PUSAT PERDAGANGAN BANDAR BUKIT JALIL,  
PERSIARAN JALIL 1,  
57000, KUALA LUMPUR, MALAYSIA  
TEL : +6 03- 2733 2960  
FAX : +6 03- 2733 2961

TITLE  
PELAN TAPAK

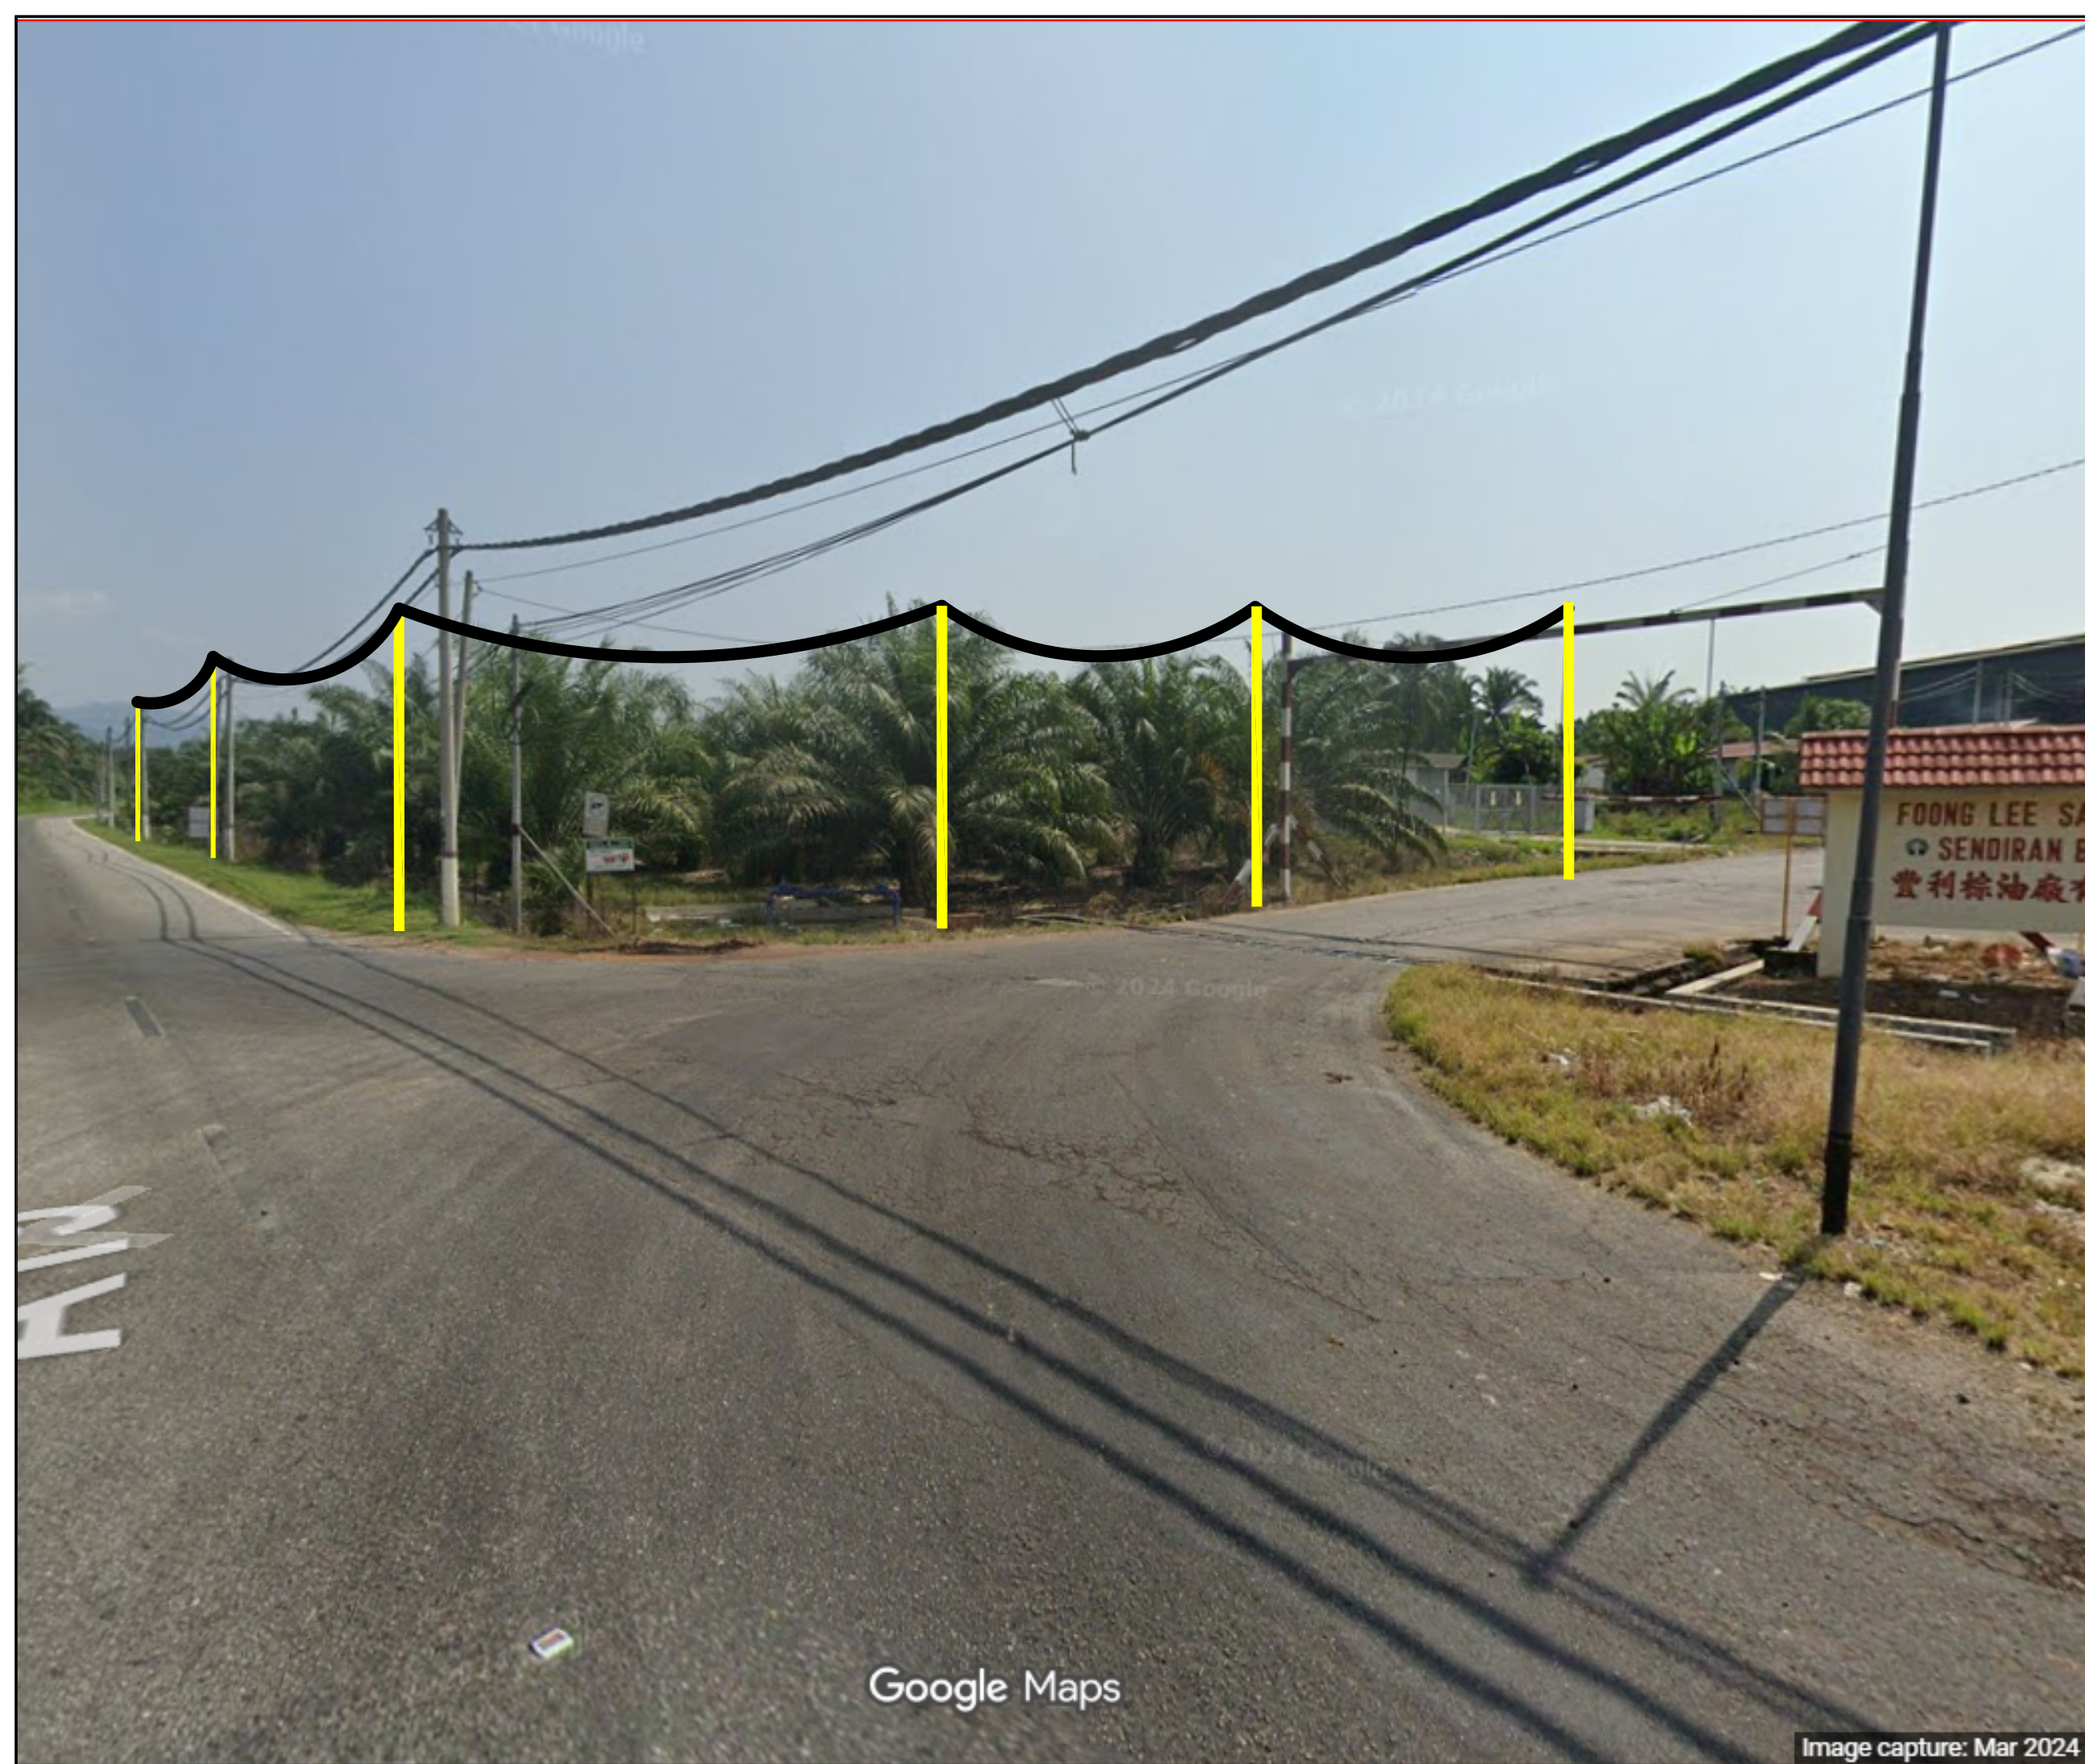DRAWN LED	DESIGNED LED	APPROVED HYS
DATE 30 OCT, 2025	SCALE 1:3000	
DRAWING NO DB2505-GLTC(2)-KUDR-002	REV/NO 1	SHEET 1/1



NOTES :  
 1. ALL DIMENSIONS SHALL BE IN MILIMETER (MM) UNLESS NOTED OTHERWISE.  
 2. SETIAP JARAK TIANG ADALAH LEBIH KURANG 20 METER

-  MANANAM TIANG TNB DI BAHU JALAN
-  TALIAN SESALUR DI ATAS TNB


REV. NO	DATE	REMARK

PROPRIETARY INFORMATION :  
 THE INFORMATION IN THIS DOCUMENT/ DRAWING IS THE PROPERTY OF  
 GLT DESIGN BUILD SDN. BHD. IS SUBJECTED TO RETURN UPON DEMAND AND  
 MAY NOT BE REPRODUCED OR DISCLOSED TO OTHERS WITHOUT THE WRITTEN  
 CONSENT OF GLT DESIGN BUILD SDN. BHD.

PROJECT:  
 DESIGN, SUPPLY, FABRICATION, CONSTRUCTION, DELIVERY TO SITE,  
 INSTALLATION, COMPLETION, TESTING AND COMMISSIONING AND  
 GUARANTEE THE PERFORMANCE OF 1 MW BIOGAS POWER PLANT AT GLT  
 CLIMATE SDN BHD, SUNGAI SIPUT, PERAK

PROJECT OWNER:  
 **GLT CLIMATE SDN BHD**  
 H-3A-01,  
 PUSAT PERDAGANGAN BANDAR BUKIT JALIL,  
 PERSIARAN JALIL 1,  
 57000, KUALA LUMPUR, MALAYSIA  
 TEL : +6 03- 2733 2960  
 FAX : +6 03- 2733 2961

EPC CONTRACTOR:  
 **GLT DESIGN BUILD SDN BHD**  
 H-3A-01,  
 PUSAT PERDAGANGAN BANDAR BUKIT JALIL,  
 PERSIARAN JALIL 1,  
 57000, KUALA LUMPUR, MALAYSIA  
 TEL : +6 03- 2733 2960  
 FAX : +6 03- 2733 2961

TITLE  
 GAMBAR LOKASI



DRAWN LED	DESIGNED LED	APPROVED HYS
DATE 30 OCT, 2025	SCALE 1:12000	
DRAWING NO DB2505-GLTC(2)-KUDR-003	REV/NO 1	SHEET 1/2

Google Maps

Image capture: Mar 2024



NOTES :  
 1. ALL DIMENSIONS SHALL BE IN MILIMETER (MM) UNLESS NOTED OTHERWISE.  
 2. SETIAP JARAK TIANG ADALAH LEBIH KURANG 20 METER

 MANANAM TIANG TNB DI BAHU JALAN  
 TALIAN SESALUR DI ATAS TNB


REV. NO	DATE	REMARK

PROPRIETARY INFORMATION :  
 THE INFORMATION IN THIS DOCUMENT/ DRAWING IS THE PROPERTY OF  
 GLT DESIGN BUILD SDN. BHD. IS SUBJECTED TO RETURN UPON DEMAND AND  
 MAY NOT BE REPRODUCED OR DISCLOSED TO OTHERS WITHOUT THE WRITTEN  
 CONSENT OF GLT DESIGN BUILD SDN. BHD.

PROJECT:  
 DESIGN, SUPPLY, FABRICATION, CONSTRUCTION, DELIVERY TO SITE,  
 INSTALLATION, COMPLETION, TESTING AND COMMISSIONING AND  
 GUARANTEE THE PERFORMANCE OF 1 MW BIOGAS POWER PLANT AT GLT  
 CLIMATE SDN BHD, SUNGAI SIPUT, PERAK

PROJECT OWNER:  
 **GLT CLIMATE SDN BHD**  
 H-3A-01,  
 PUSAT PERDAGANGAN BANDAR BUKIT JALIL,  
 PERSIARAN JALIL 1,  
 57000, KUALA LUMPUR, MALAYSIA  
 TEL : +6 03- 2733 2960  
 FAX : +6 03- 2733 2961

EPC CONTRACTOR:  
 **GLT DESIGN BUILD SDN BHD**  
 H-3A-01,  
 PUSAT PERDAGANGAN BANDAR BUKIT JALIL,  
 PERSIARAN JALIL 1,  
 57000, KUALA LUMPUR, MALAYSIA  
 TEL : +6 03- 2733 2960  
 FAX : +6 03- 2733 2961

TITLE  
 GAMBAR LOKASI

DRAWN LED	DESIGNED LED	APPROVED HYS
DATE 30 OCT, 2025	SCALE 1:12000	
DRAWING NO DB2505-GLTC(2)-KUDR-003	REV/NO 1	SHEET 2/2

Google Maps

Image capture: Mar 2024 © 2025 Google