



(DAERAH KUALA NERUS)
SEKOLAH KEBANGSAAN PADANG KEMUNTING

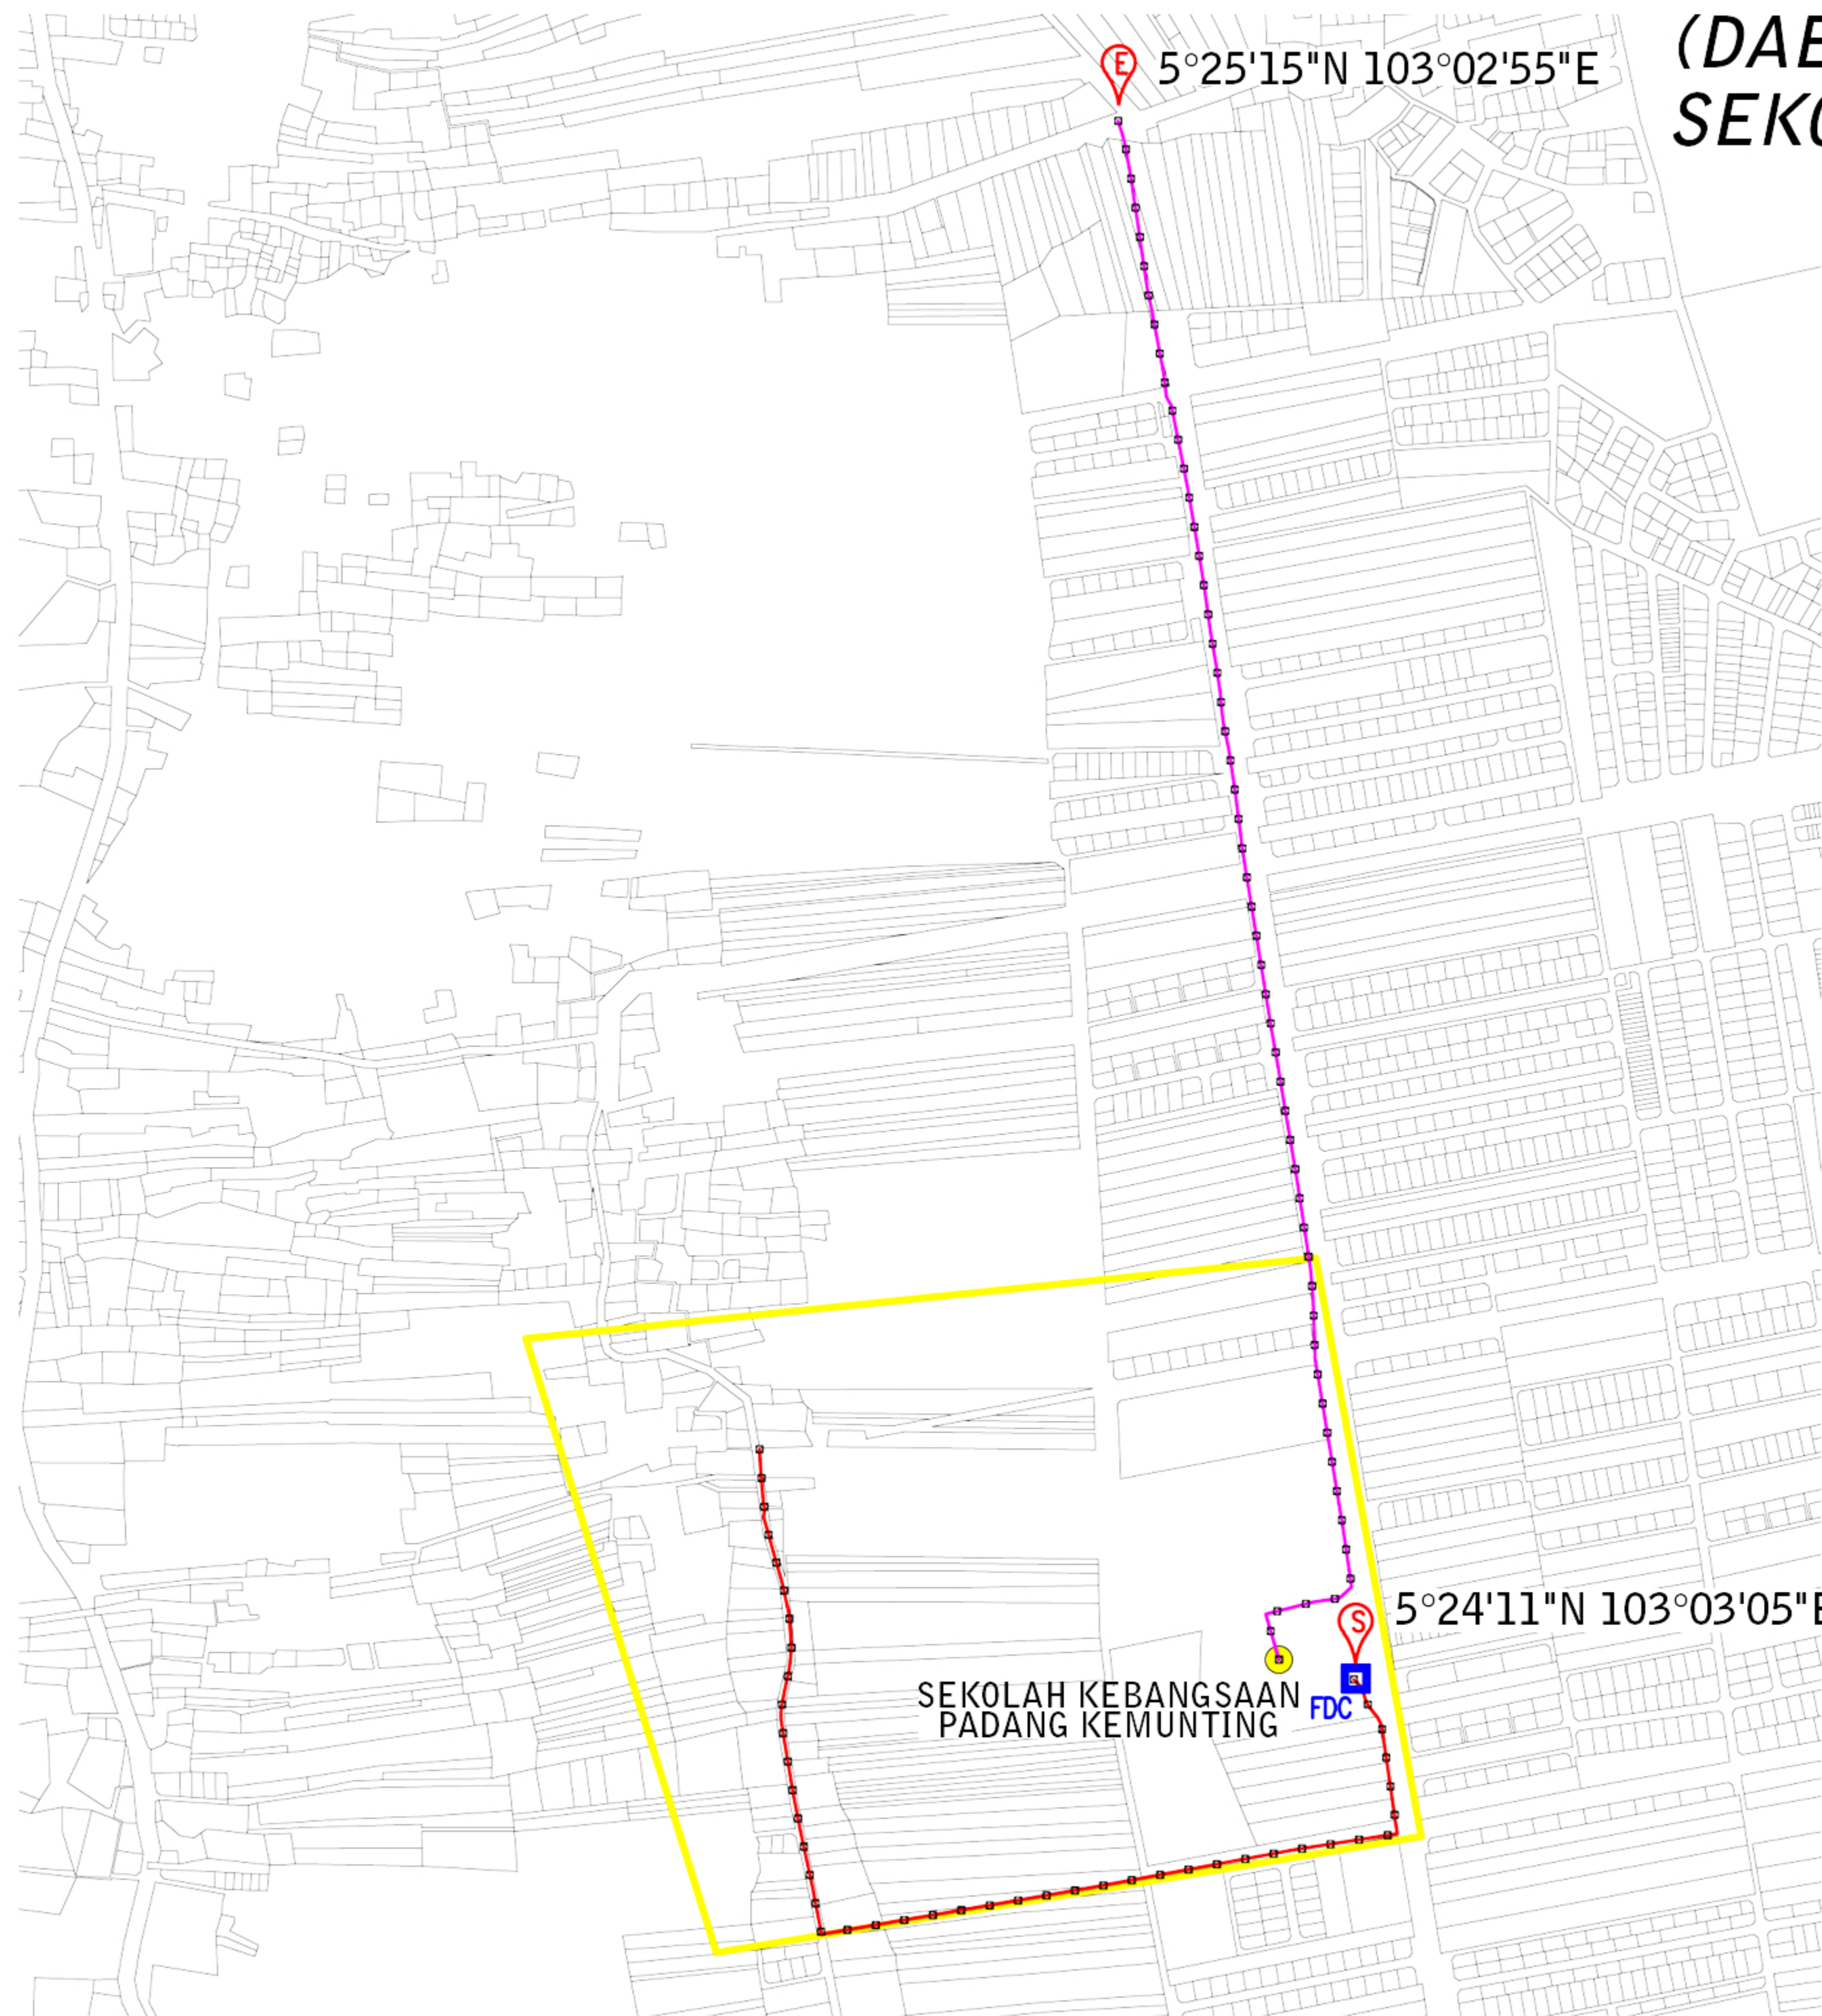

- total length = 1571.08m
 - post = 44 nos
 - distance post = 35m

- total length = 2054.64m
 - post = 56 nos
 - distance post = 35m

TOTAL POST = 100 NOS

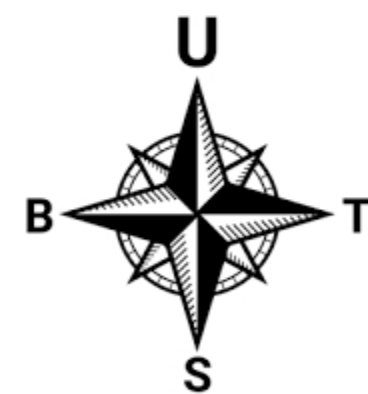

SITE PLAN

LEGEND :

- GPON CABLE
- BACKHAUL CABLE
- FDC - FIBRE DISTRIBUTION CABINET
- START
- END
- SCHOOL



DRAWN BY: Potyar
 CHKD BY:
 DATE: DEC 2024
 DWG. NO.: NA/YAR/24/11

CLUSTER NAME : KUALA NERUS
 STATE: TERENGGANU
 SCALE: NOT TO SCALE
 VERSION: 1

ENDORSE BY:

KORIDOR UTILITI TEKNOLOGI TERENGGANU
 (Pelan Infrastruktur Utiliti)
PROJECT TITLE:
 PERMOHONAN HAK AKSES CADANGAN LALUAN FIBER OPTIK &
 PENANAMAN TIANG BAGI PERMOHONAN IZIN LALU UNTUK PROJEK
 PENYEDIAAN DAN PENYELENGGARAAN POINT OF PRESENCE (POP)
 HUB INFRASTRUKTUR GENTIAN OPTIK BERHAMPIRAN DENGAN
 SEKOLAH, KAW. PERINDUSTRIAN, PREMIS KERAJAAN DAN
 KOMUNITI SEKITARNYA OLEH KEMENTERIAN KOMUNIKASI
 DAN MULTIMEDIA (K-KOM)

NOTE:

AHMAD FARID BIN MOHAMAD
 Managing Director
 AZIMAT TELCO SDN BHD
 (1367371-U)

SHEET
 13 - 13