



Local Authorities:-

LEGEND :-

- = EXISTING BUILDING MANHOLE
- = EXISTING TIME MH
- ▣ = PROPOSE NEW TIME MH
- - - = PROPOSED NEW CABLE DUCT
- = PROPOSED INSTALL G.I PIPE
- = EXISTING DUCT WAY
- 1W / 4W = 2 WAY OR 4 WAY DUCT


DRAWING SCALE:	DRAWING UNITS:
N.T.S	METER
PREPARED BY: TECOM ENERGY SDN. BHD.	INITIAL & DATE: 27/11/2024
DESIGNED BY: TECOM ENERGY SDN. BHD.	INITIAL & DATE: 27/11/2024
CHECKED BY: TECOM ENERGY SDN. BHD.	INITIAL & DATE: 27/11/2024
APPROVED BY: TT DOTCOM SDN. BHD.	INITIAL & DATE: -

PROJECT TITLE: PROPOSED SITE PLAN – SO_UPSI: 2ND ROUTE	
DRAWING TITLE: PROPOSED PLAN VIEW DRAWING – SO UPSI: 2ND ROUTE	
DRAWING NO:	E3911
SHEET NO:1/2	

TT dotCom Sdn Bhd (52371-A)
 No 14, Jalan Majistret U1/26,
 Hicom Glenmarie Industrial Park
 40150 Shah Alam, Selangor Darul Ehsan, Malaysia.
 Tel: +60 3 5032 6000
 Website: www.time.com.my

Tecom Energy Sdn. Bhd. (1255358-W)
 No 35-B, Jalan PP 2/5,
 Taman Putra Prima,
 47100 Puchong, Selangor Darul Ehsan.
 Tel: +603 5886 2005
 E-mail: info@tecom.my

REV. NO.	REV. DATE	REV. BY

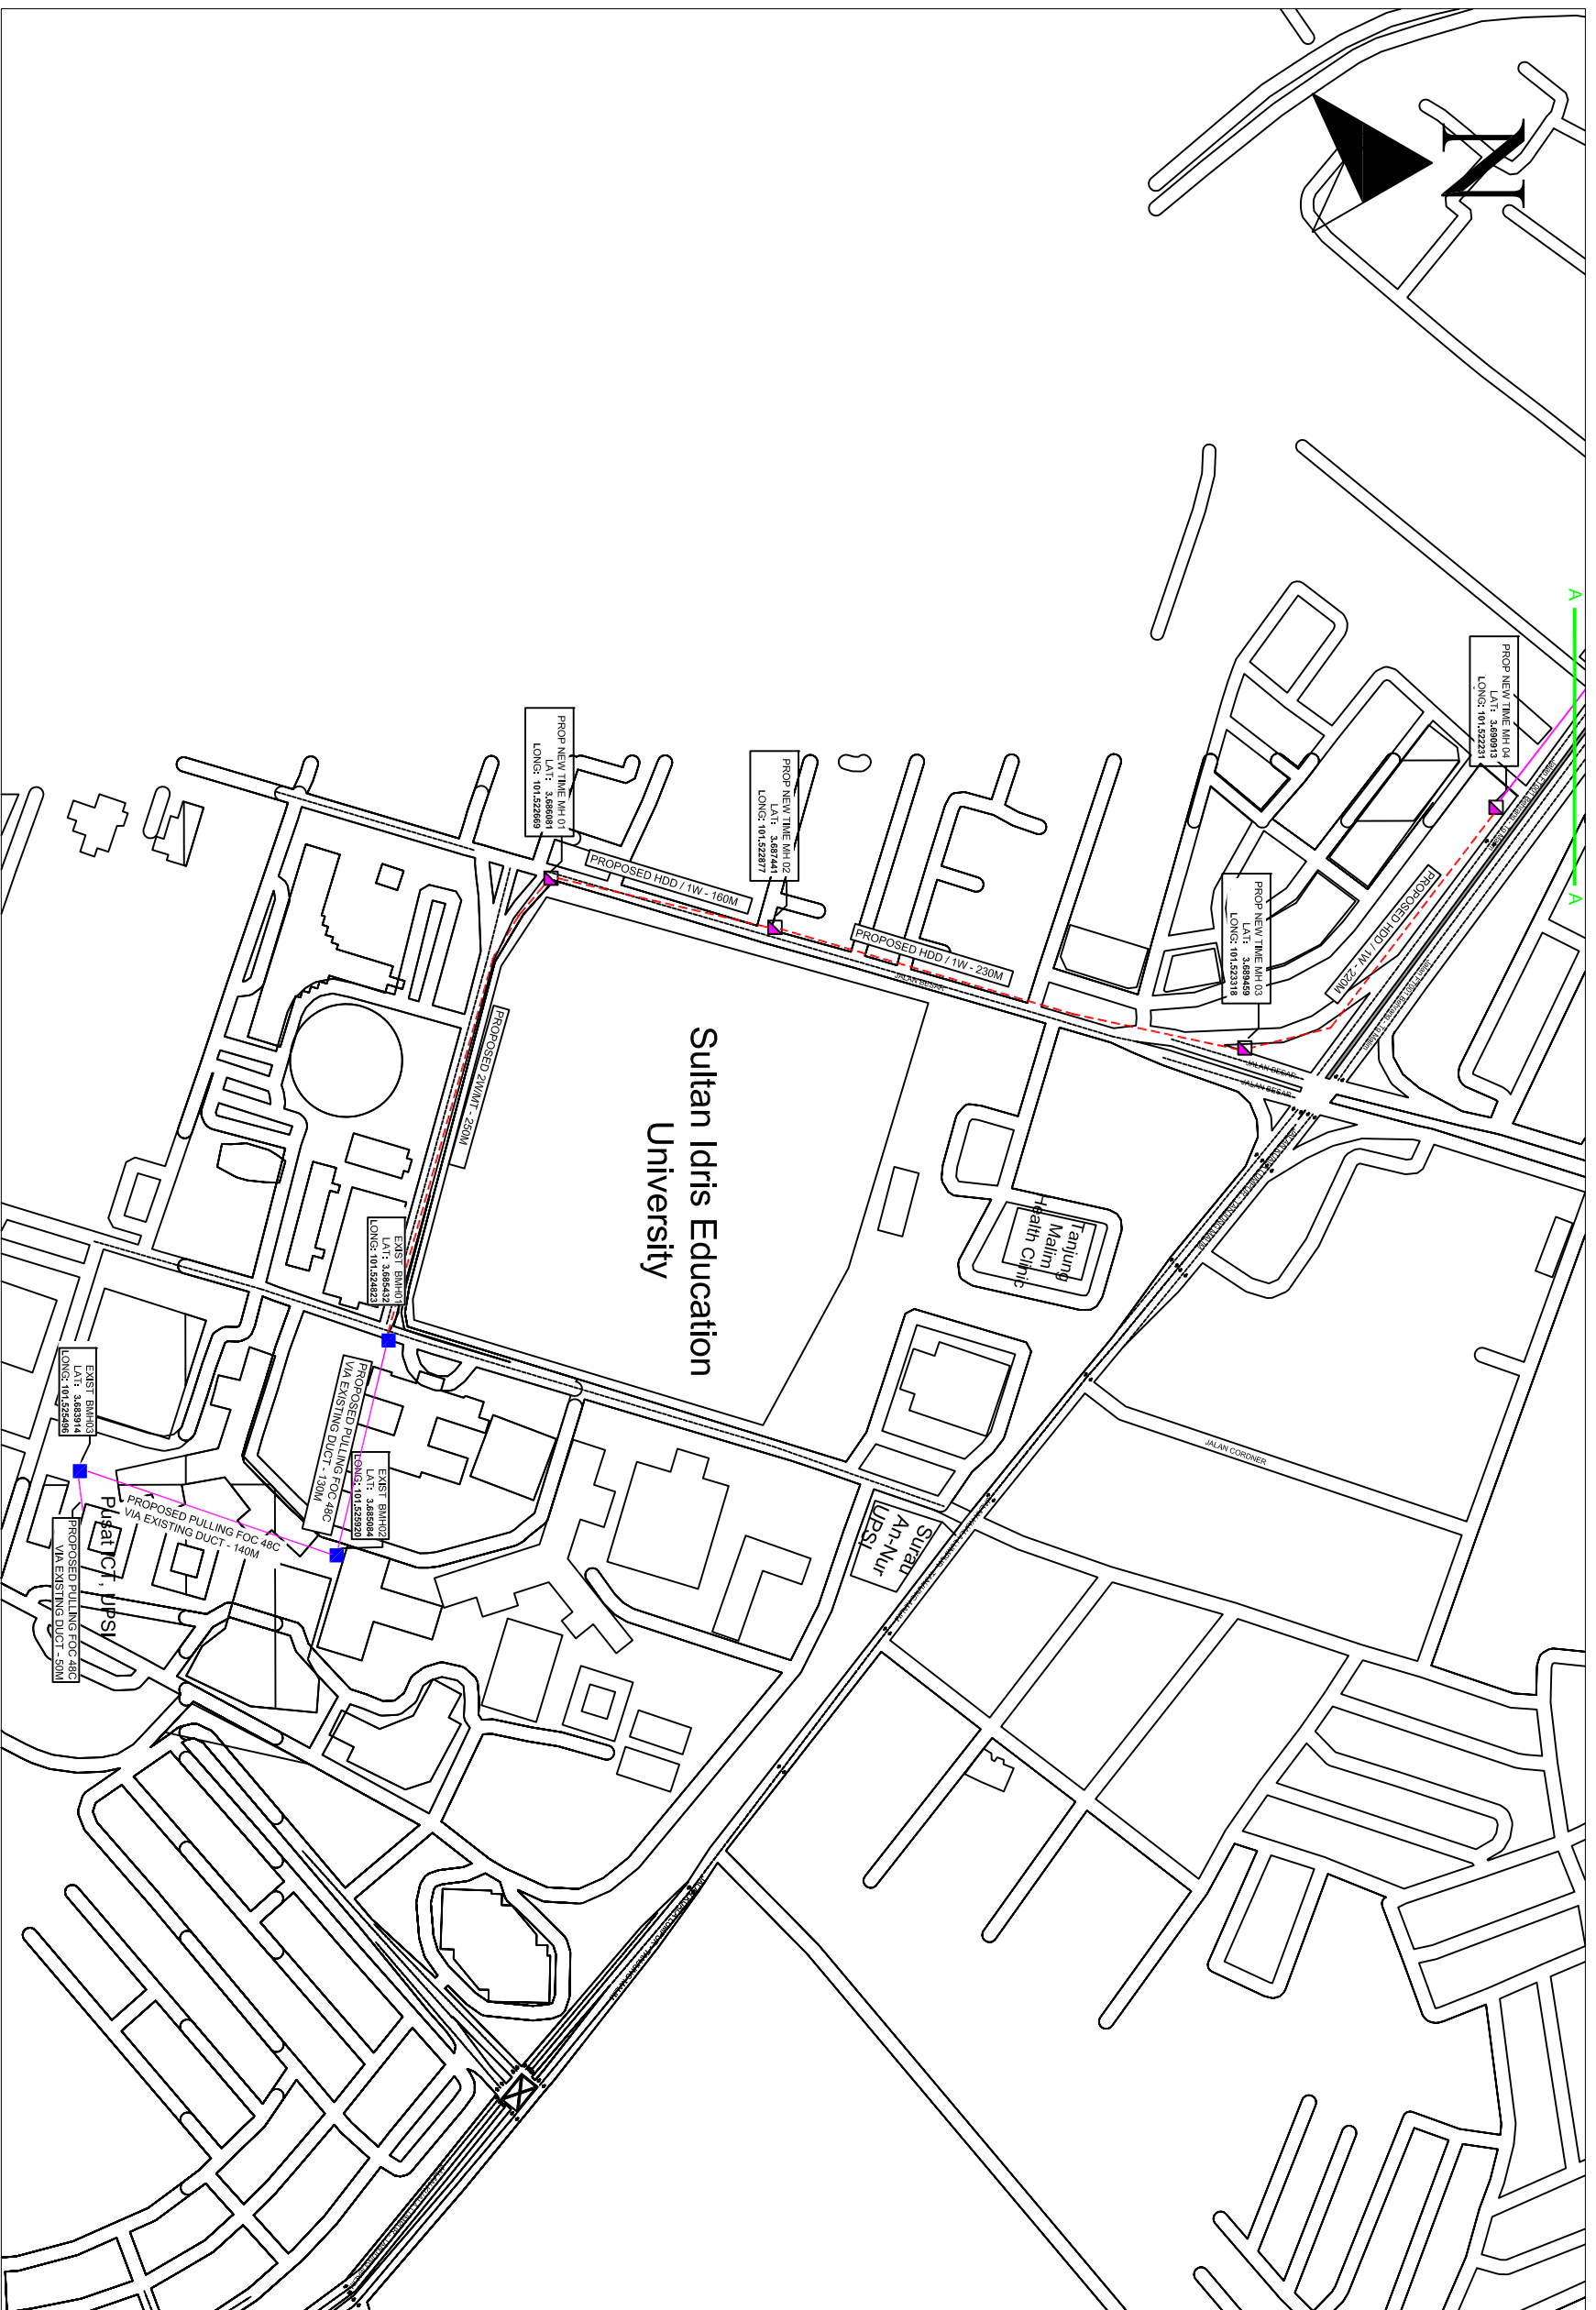

Local Authorities:-

- LEGEND :-**
- = EXISTING BUILDING MANHOLE
 - = EXISTING TIME MH
 - = PROPOSE NEW TIME MH
 - - - = PROPOSED NEW CABLE DUCT
 - = PROPOSED INSTALL G.I PIPE
 - = EXISTING DUCT WAY
 - 1W / 4W = 2 WAY OR 4 WAY DUCT

DRAWING SCALE:	DRAWING UNITS:
N.T.S	METER
PREPARED BY: TECOM ENERGY SDN. BHD.	INITIAL & DATE: 27/11/2024
DESIGNED BY: TECOM ENERGY SDN. BHD.	INITIAL & DATE: 27/11/2024
CHECKED BY: TECOM ENERGY SDN. BHD.	INITIAL & DATE: 27/11/2024
APPROVED BY: TT DOTCOM SDN. BHD.	INITIAL & DATE: -


PROJECT TITLE: PROPOSED SITE PLAN – SO_UPSI: 2ND ROUTE	
DRAWING TITLE: PROPOSED PLAN VIEW DRAWING – SO UPSI: 2ND ROUTE	
DRAWING NO:	E3911
	1
	SHEET NO:1/2

timeTM

TT dotCom Sdn Bhd (52371-A)
No 14, Jalan Majistret U1/26,
Hicom Glenmarie Industrial Park
40150 Shah Alam, Selangor Darul Ehsan, Malaysia.
Tel: +60 3 5032 6000
Website: www.time.com.my

Tecom Energy Sdn. Bhd. (1255358-W)
No 35-B, Jalan PP 2/5,
Taman Putra Prima,
47100 Puchong, Selangor Darul Ehsan.
Tel: +603 5886 2005
E-mail: info@tecom.my

REV. NO.	REV. DATE	REV. BY

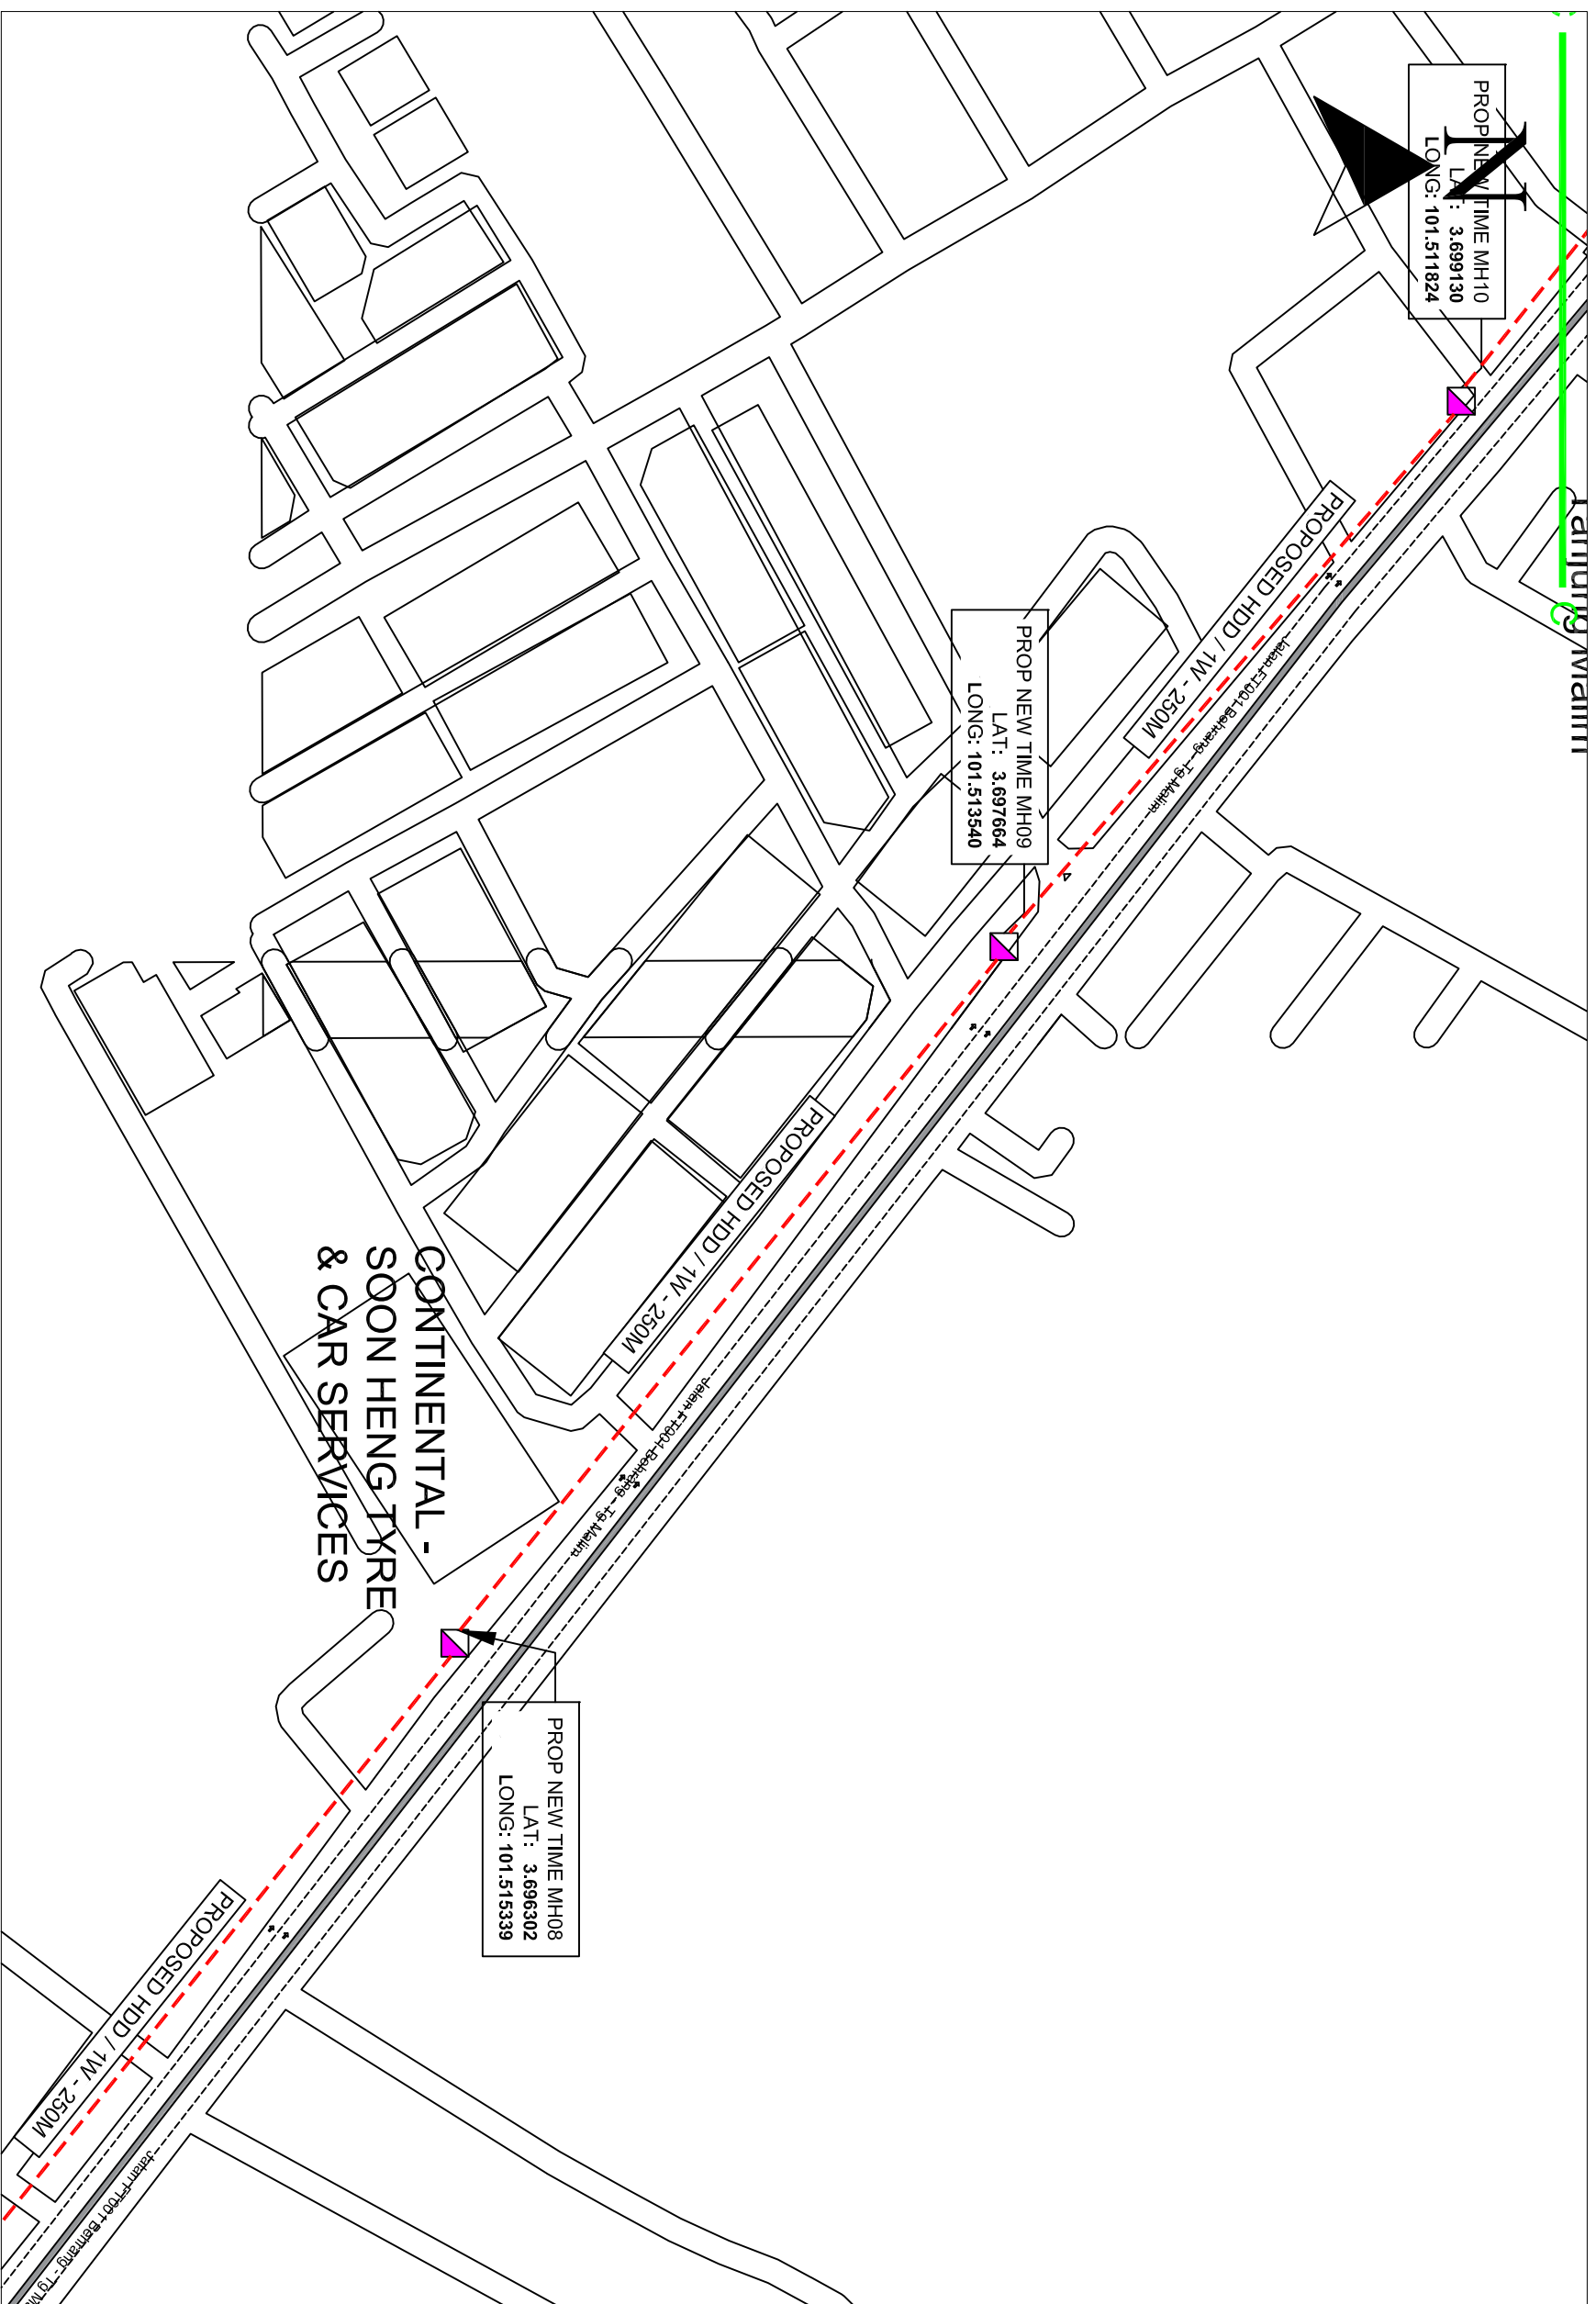

Local Authorities:-

LEGEND :-

- = EXISTING BUILDING MANHOLE
- = EXISTING TIME MH
- = PROPOSE NEW TIME MH
- - - = PROPOSED NEW CABLE DUCT
- = PROPOSED INSTALL G.I PIPE
- 1W / 4W = 2 WAY OR 4 WAY DUCT

DRAWING SCALE:	DRAWING UNITS:
N.T.S	METER
PREPARED BY: TECOM ENERGY SDN. BHD.	INITIAL & DATE: 27/11/2024
DESIGNED BY: TECOM ENERGY SDN. BHD.	INITIAL & DATE: 27/11/2024
CHECKED BY: TECOM ENERGY SDN. BHD.	INITIAL & DATE: 27/11/2024
APPROVED BY: TT DOTCOM SDN. BHD.	INITIAL & DATE: -

PROJECT TITLE: PROPOSED SITE PLAN – SO_UPSI: 2ND ROUTE	
DRAWING TITLE: PROPOSED PLAN VIEW DRAWING – SO UPSI: 2ND ROUTE	DRAWING NO: E3911
SHEET NO:1/2	

timeTM

TT dotCom Sdn Bhd (52371-A)
No 14, Jalan Majistret U1/26,
Hicom Glenmarie Industrial Park
40150 Shah Alam, Selangor Darul Ehsan, Malaysia.
Tel: +60 3 5032 6000
Website: www.time.com.my


Tecom Energy Sdn. Bhd. (1255358-W)

No 35-B, Jalan PP 2/5,
Taman Putra Prima,
47100 Puchong, Selangor Darul Ehsan.
Tel: +603 5886 2005
E-mail: info@tecom.my

REV. NO.	REV. DATE	REV. BY



KELULUSAN PLAN

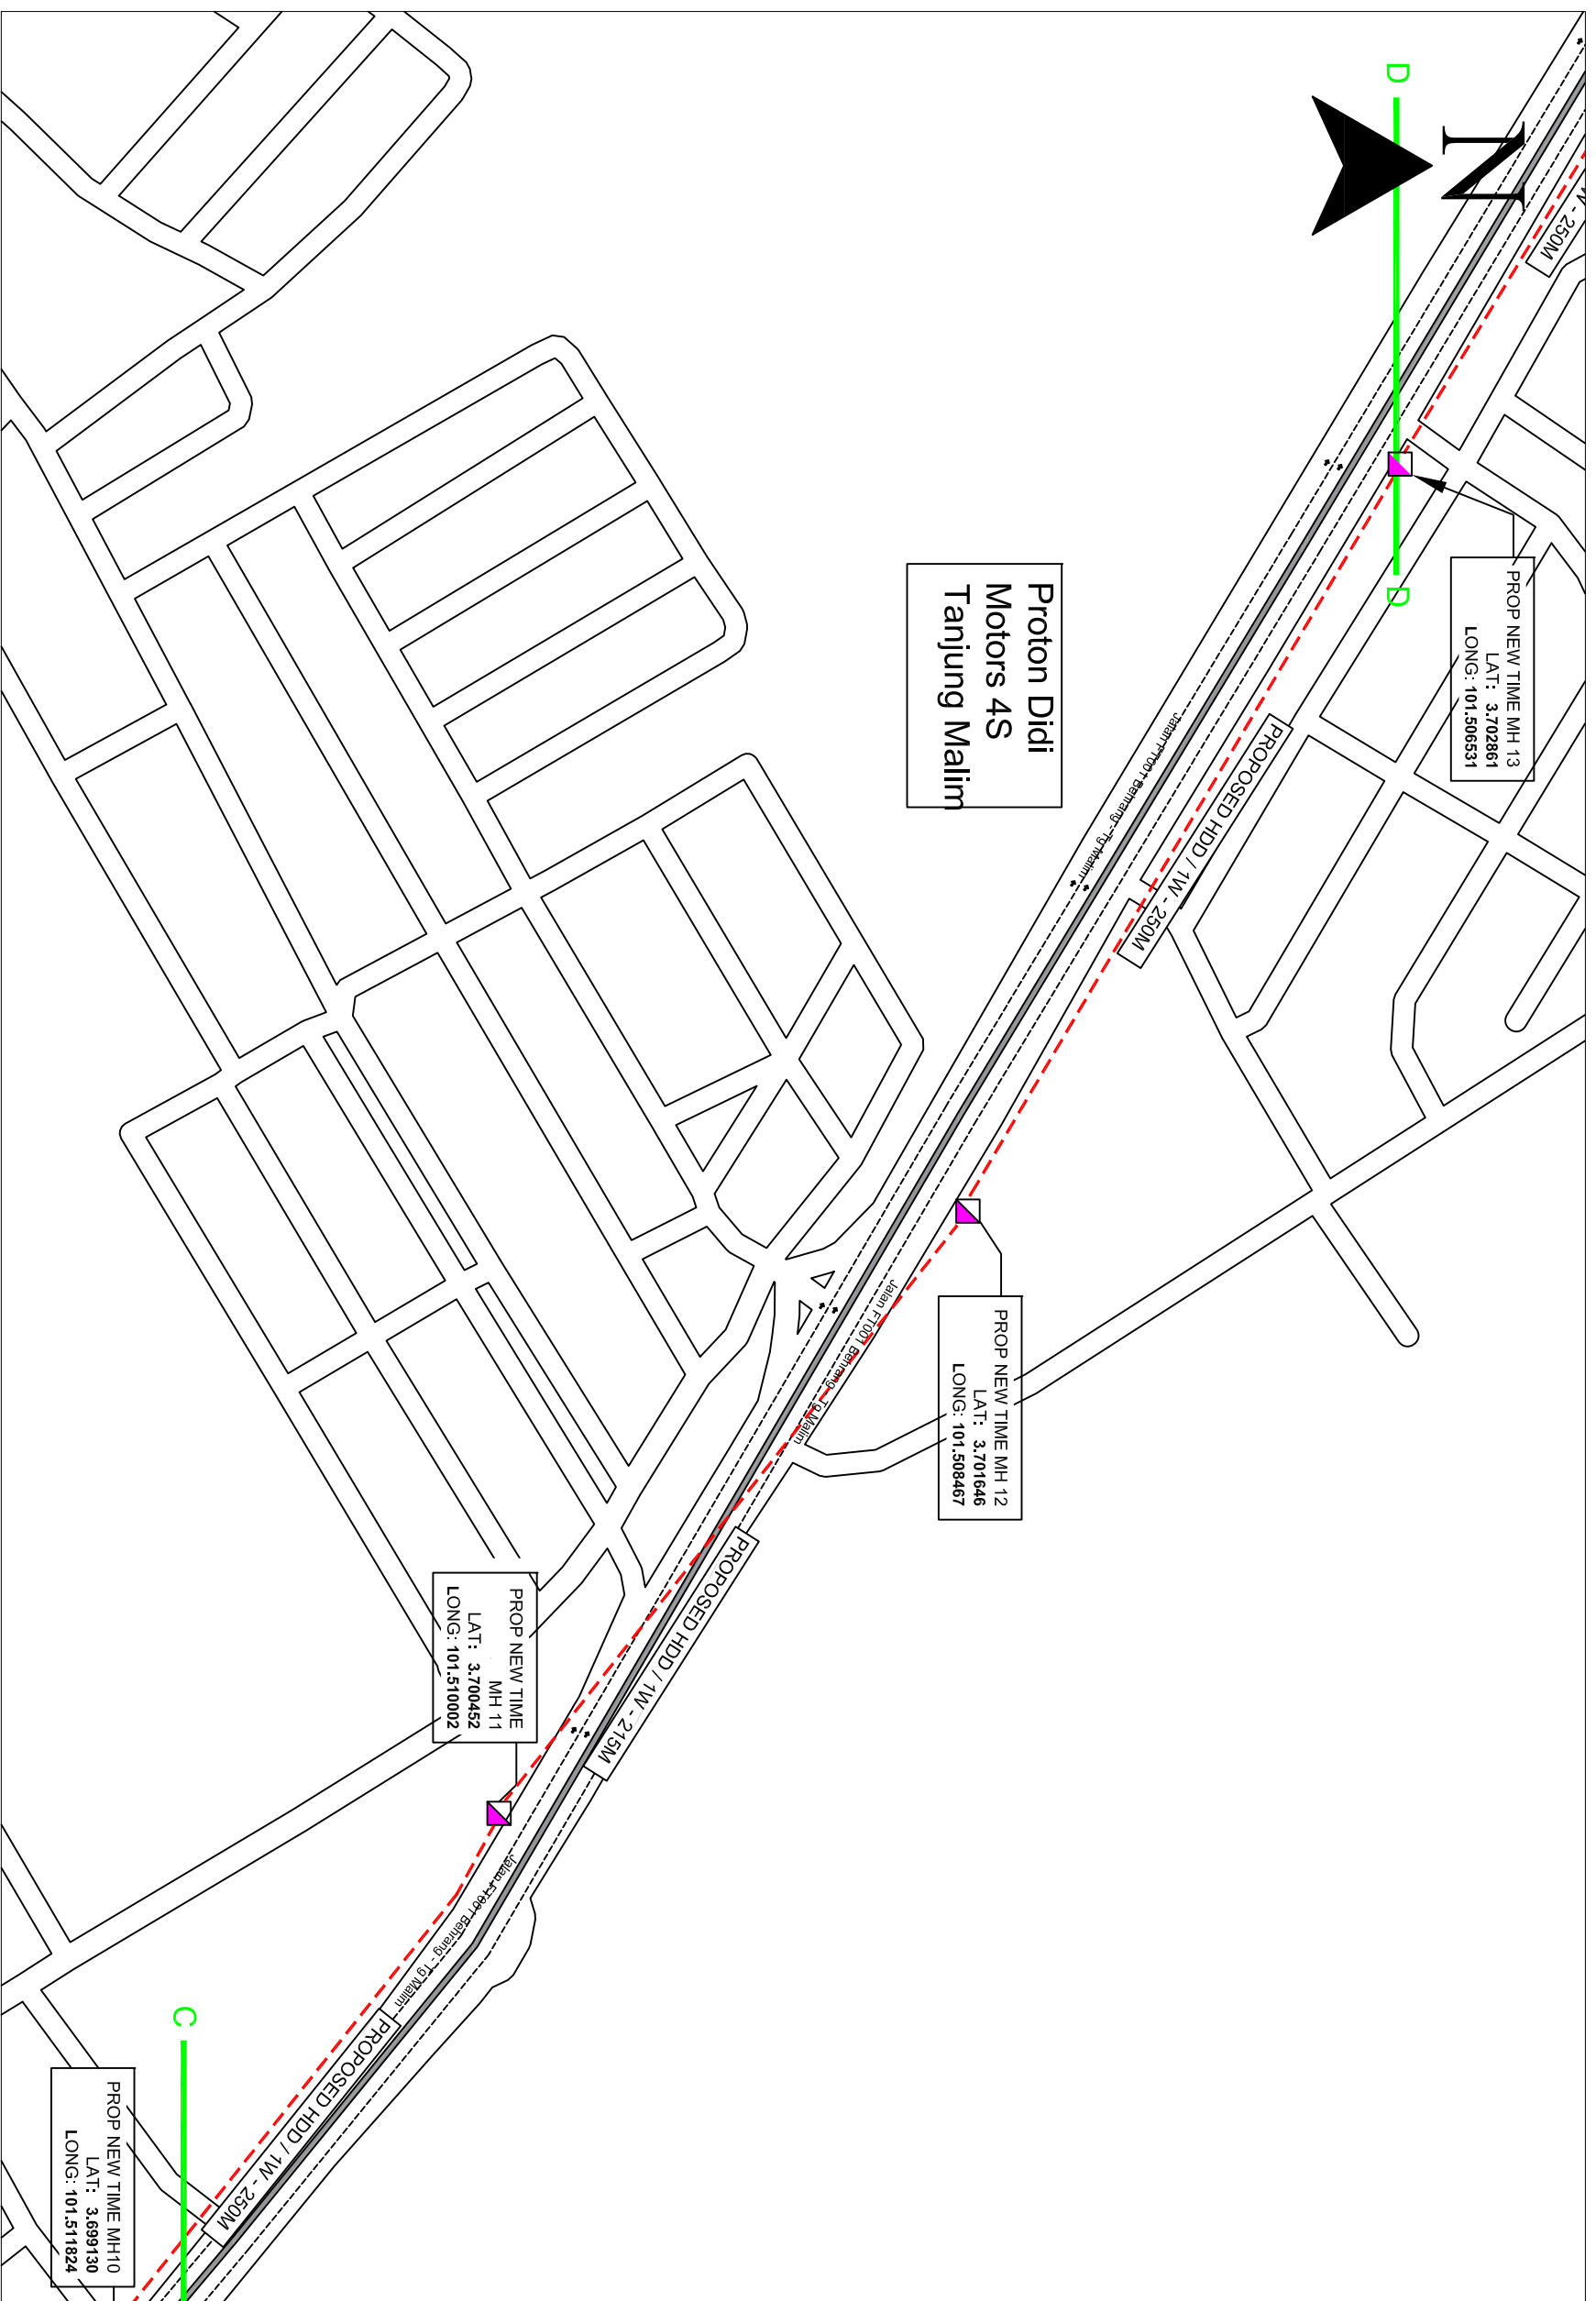

Local Authorities:-

LEGEND :-

- = EXISTING BUILDING MANHOLE
- = EXISTING TIME MH
- = PROPOSE NEW TIME MH
- - - = PROPOSED NEW CABLE DUCT
- = PROPOSED INSTALL G.I PIPE
- 1W / 4W = 2 WAY OR 4 WAY DUCT


DRAWING SCALE:	DRAWING UNITS:
N.T.S	METER
PREPARED BY:	INITIAL & DATE:
TECOM ENERGY SDN. BHD.	27/11/2024
DESIGNED BY:	INITIAL & DATE:
TECOM ENERGY SDN. BHD.	27/11/2024
CHECKED BY:	INITIAL & DATE:
TECOM ENERGY SDN. BHD.	27/11/2024
APPROVED BY:	INITIAL & DATE:
TT DOTCOM SDN. BHD.	-

PROJECT TITLE:	PROPOSED SITE PLAN – SO_UPSI: 2ND ROUTE
DRAWING TITLE:	PROPOSED PLAN VIEW DRAWING – SO UPSI: 2ND ROUTE
DRAWING NO:	E39111 SHEET NO:1/2

TT dotCom Sdn Bhd (52371-A)
 No 14, Jalan Majistret U1/26,
 Hicom Glenmarie Industrial Park
 40150 Shah Alam, Selangor Darul Ehsan, Malaysia.
 Tel: +60 3 5032 6000
 Website: www.time.com.my

Tecom Energy Sdn. Bhd. (1255358-W)
 No 35-B, Jalan PP 2/5,
 Taman Putra Prima,
 47100 Puchong, Selangor Darul Ehsan.
 Tel: +603 5886 2005
 E-mail: info@tecom.my

REV. NO.	REV. DATE	REV. BY

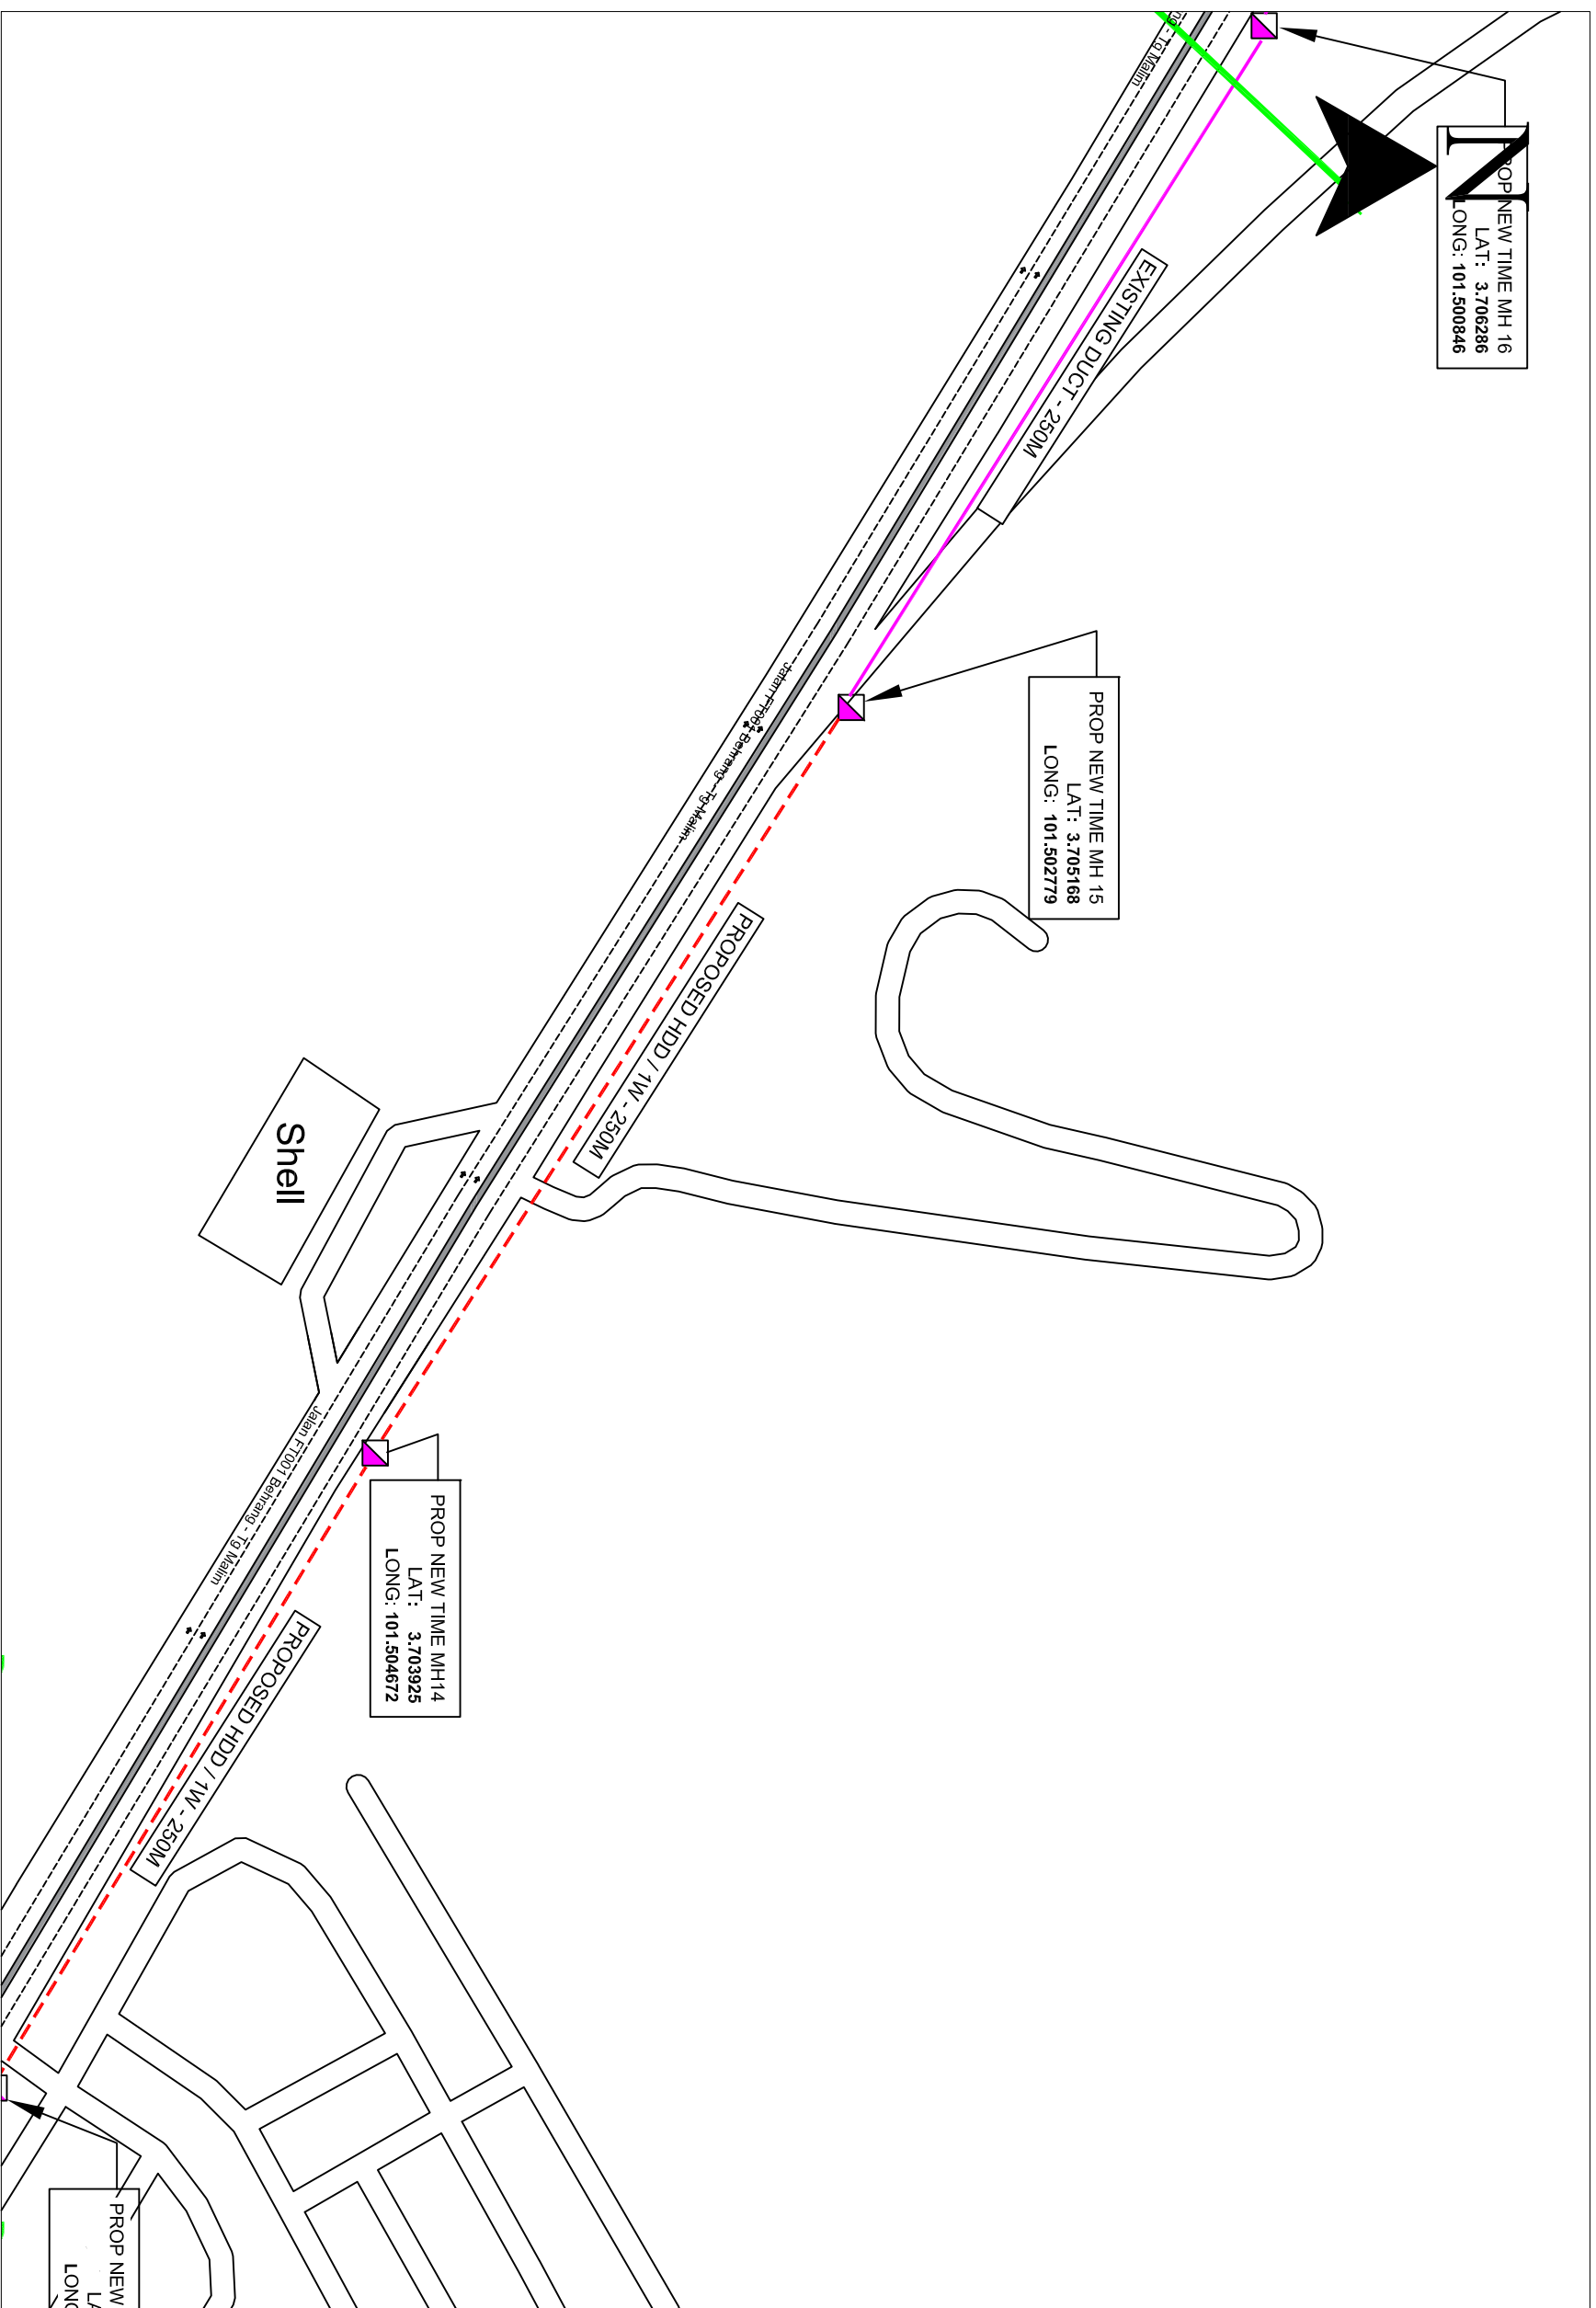

Local Authorities:-

- LEGEND :-**
- = EXISTING BUILDING MANHOLE
 - = EXISTING TIME MH
 - ▣ = PROPOSE NEW TIME MH
 - - - = PROPOSED NEW CABLE DUCT
 - = PROPOSED INSTALL G.I PIPE
 - 1W / 4W = 2 WAY OR 4 WAY DUCT

DRAWING SCALE:	DRAWING UNITS:
N.T.S	METER
PREPARED BY: TECOM ENERGY SDN. BHD.	INITIAL & DATE: 27/11/2024
DESIGNED BY: TECOM ENERGY SDN. BHD.	INITIAL & DATE: 27/11/2024
CHECKED BY: TECOM ENERGY SDN. BHD.	INITIAL & DATE: 27/11/2024
APPROVED BY: TT DOTCOM SDN. BHD.	INITIAL & DATE: -


PROJECT TITLE: PROPOSED SITE PLAN – SO_UPSI: 2ND ROUTE	
DRAWING TITLE: PROPOSED PLAN VIEW DRAWING – SO UPSI: 2ND ROUTE	DRAWING NO: E3911
SHEET NO:1/2	

timeTM

TT dotCom Sdn Bhd (52371-A)
No 14, Jalan Majistret U1/26,
Hicom Glenmarie Industrial Park
40150 Shah Alam, Selangor Darul Ehsan, Malaysia.
Tel: +60 3 5032 6000
Website: www.time.com.my

Tecom Energy Sdn. Bhd. (1255358-W)
No 35-B, Jalan PP 2/5,
Taman Putra Prima,
47100 Puchong, Selangor Darul Ehsan.
Tel: +603 5886 2005
E-mail: info@tecom.my

REV. NO.	REV. DATE	REV. BY

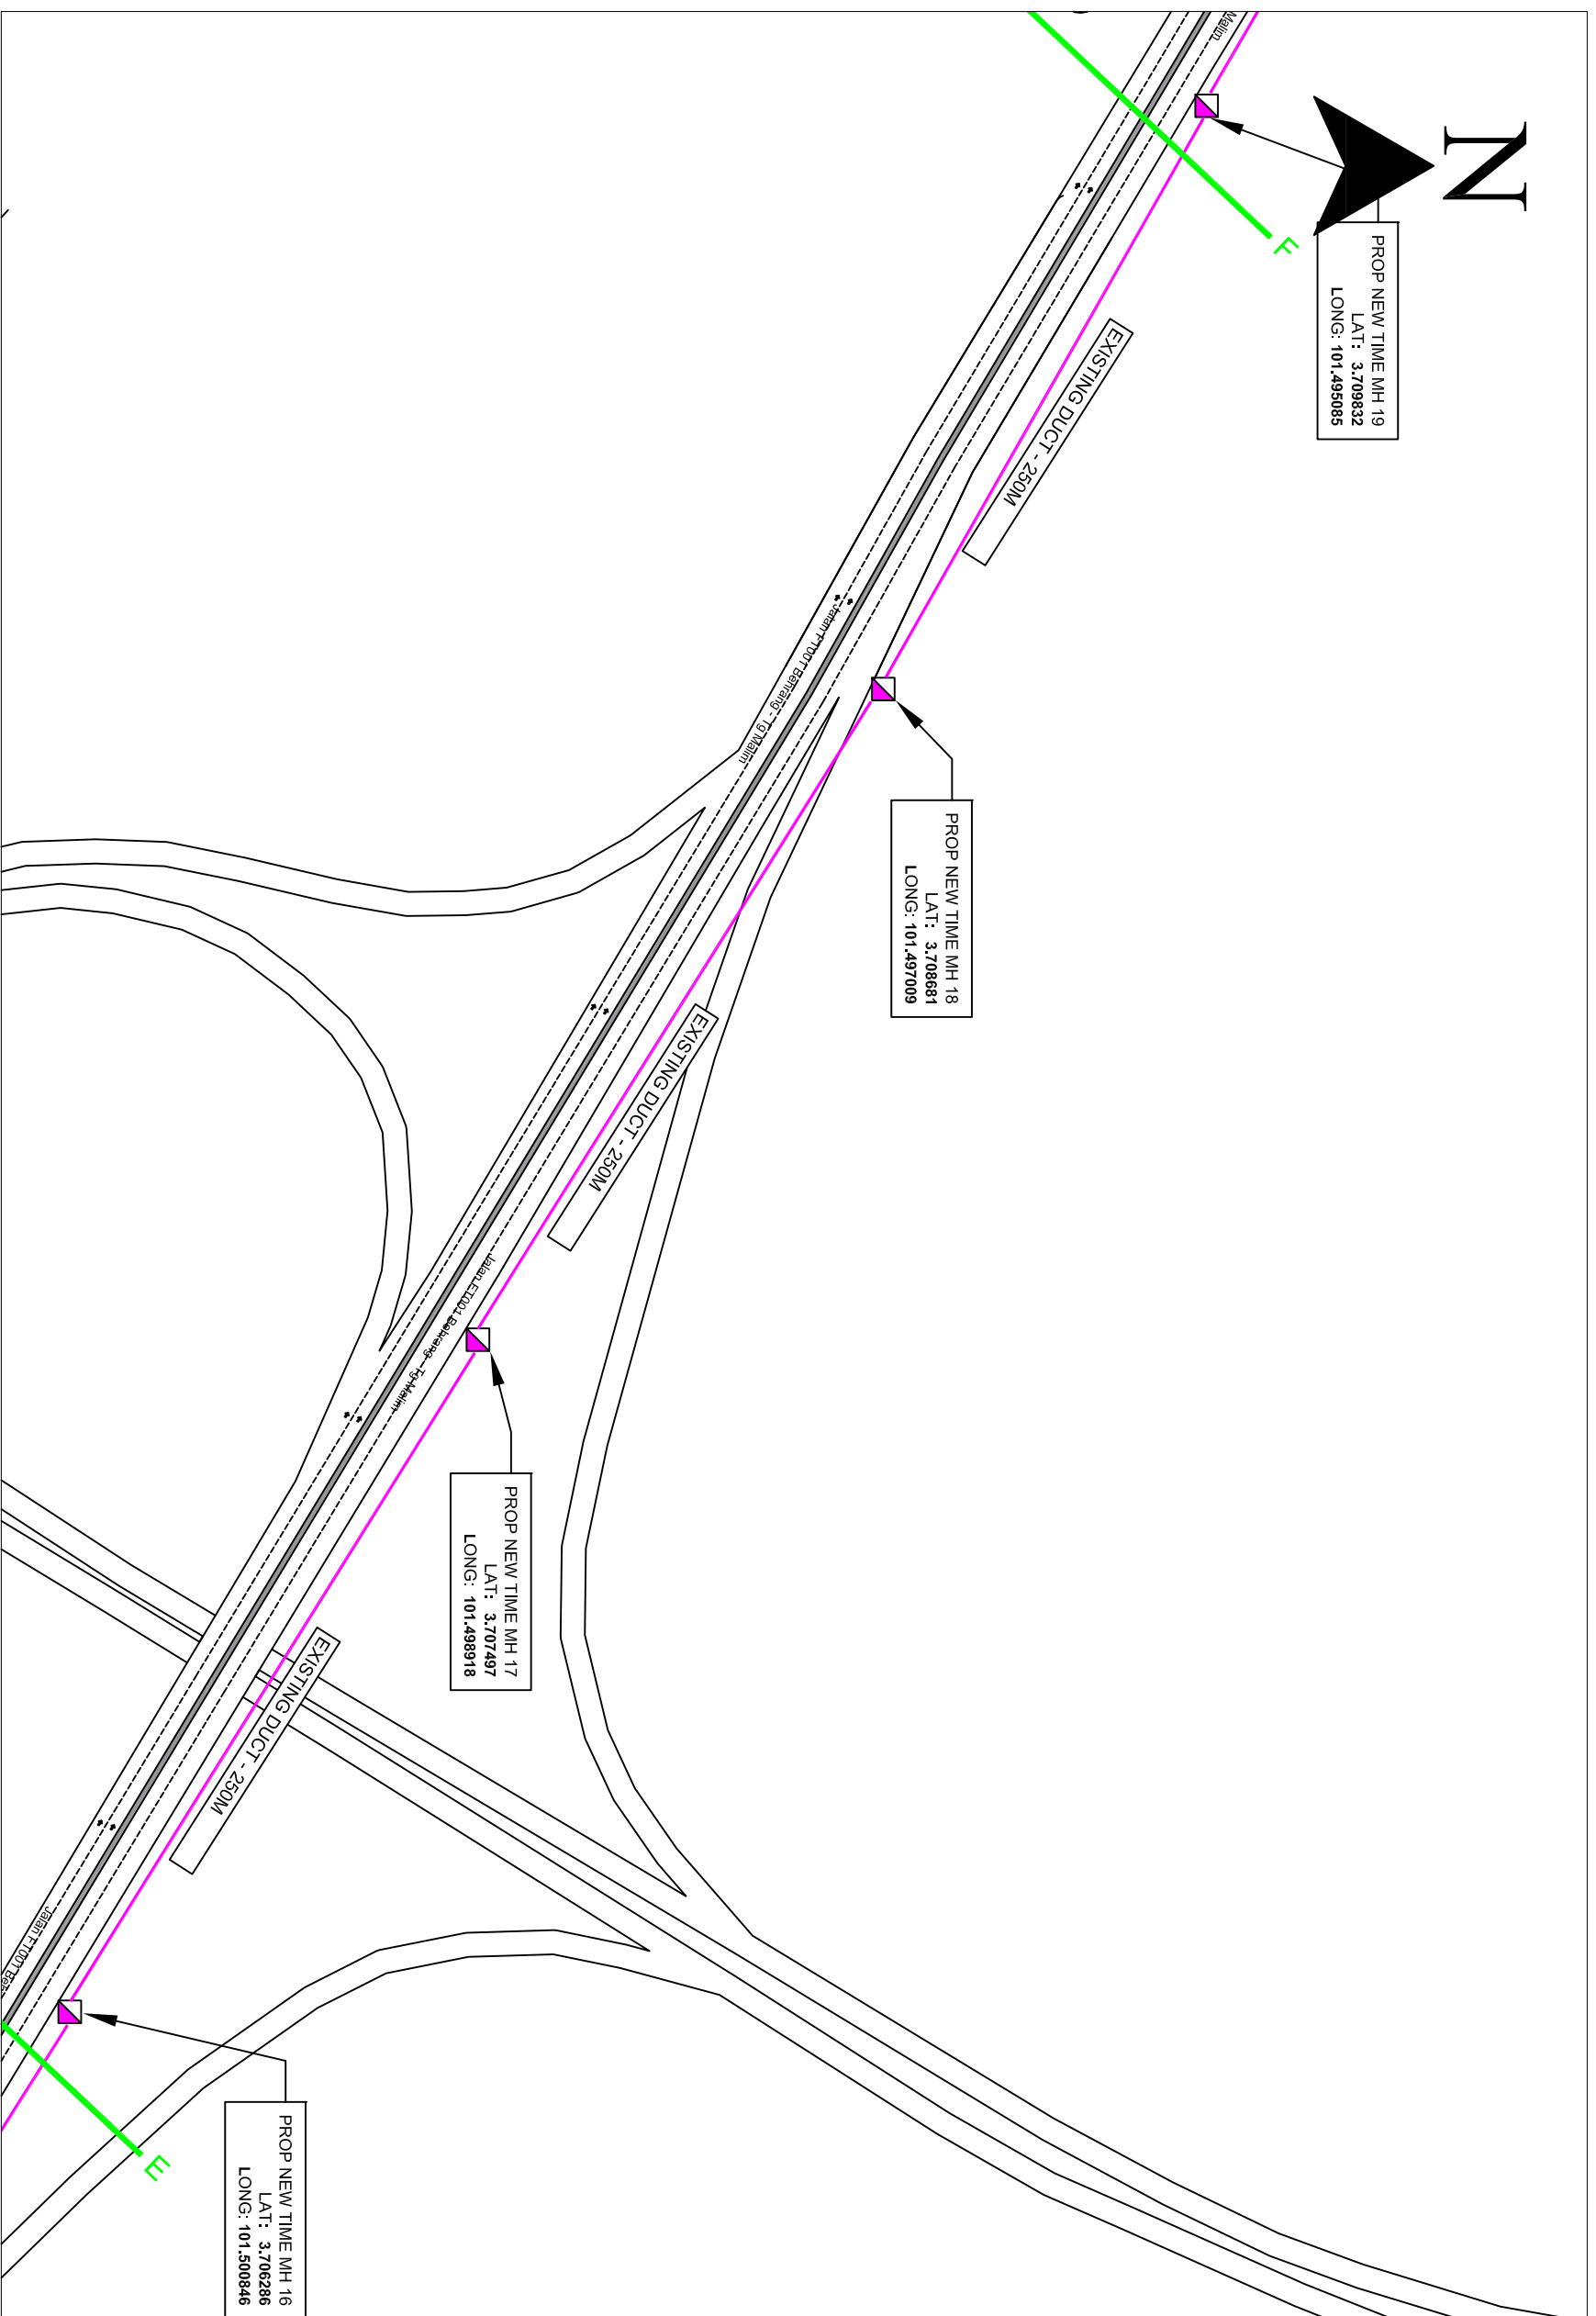

Local Authorities:-

- LEGEND :-**
- = EXISTING BUILDING MANHOLE
 - = EXISTING TIME MH
 - = PROPOSE NEW TIME MH
 - - - = PROPOSED NEW CABLE DUCT
 - = PROPOSED INSTALL G.I PIPE
 - 1W / 4W = 2 WAY OR 4 WAY DUCT

DRAWING SCALE:	DRAWING UNITS:
N.T.S	METER
PREPARED BY: TECOM ENERGY SDN. BHD.	INITIAL & DATE: 27/11/2024
DESIGNED BY: TECOM ENERGY SDN. BHD.	INITIAL & DATE: 27/11/2024
CHECKED BY: TECOM ENERGY SDN. BHD.	INITIAL & DATE: 27/11/2024
APPROVED BY: TT DOTCOM SDN. BHD.	INITIAL & DATE: -

PROJECT TITLE: PROPOSED SITE PLAN – SO_UPSI: 2ND ROUTE	
DRAWING TITLE: PROPOSED PLAN VIEW DRAWING – SO UPSI: 2ND ROUTE	DRAWING NO: E3911
SHEET NO:1/2	

timeTM

TT dotCom Sdn Bhd (52371-A)
No 14, Jalan Majistret U1/26,
Hicom Glenmarie Industrial Park
40150 Shah Alam, Selangor Darul Ehsan, Malaysia.
Tel: +60 3 5032 6000
Website: www.time.com.my

Tecom Energy Sdn. Bhd. (1255358-W)
No 35-B, Jalan PP 2/5,
Taman Putra Prima,
47100 Puchong, Selangor Darul Ehsan.
Tel: +603 5886 2005
E-mail: info@tecom.my

REV. NO.	REV. DATE	REV. BY



Local Authorities:-

LEGEND :-

- = EXISTING BUILDING MANHOLE
- = EXISTING TIME MH
- = PROPOSE NEW TIME MH
- - - = PROPOSED NEW CABLE DUCT
- = PROPOSED INSTALL G.I PIPE
- 1W / 4W = 2 WAY OR 4 WAY DUCT

DRAWING SCALE:	DRAWING UNITS:
N.T.S	METER
PREPARED BY: TECOM ENERGY SDN. BHD.	INITIAL & DATE: 27/11/2024
DESIGNED BY: TECOM ENERGY SDN. BHD.	INITIAL & DATE: 27/11/2024
CHECKED BY: TECOM ENERGY SDN. BHD.	INITIAL & DATE: 27/11/2024
APPROVED BY: TT DOTCOM SDN. BHD.	INITIAL & DATE: -


PROJECT TITLE: PROPOSED SITE PLAN – SO_UPSI: 2ND ROUTE	
DRAWING TITLE: PROPOSED PLAN VIEW DRAWING – SO UPSI: 2ND ROUTE	DRAWING NO: E39111
SHEET NO:1/2	

timeTM

TT dotCom Sdn Bhd (52371-A)
 No 14, Jalan Majistret U1/26,
 Hicom Glenmarie Industrial Park
 40150 Shah Alam, Selangor Darul Ehsan, Malaysia.
 Tel: +60 3 5032 6000
 Website: www.time.com.my

Tecom Energy Sdn. Bhd. (1255358-W)
 No 35-B, Jalan PP 2/5,
 Taman Putra Prima,
 47100 Puchong, Selangor Darul Ehsan.
 Tel: +603 5886 2005
 E-mail: info@tecom.my

REV. NO.	REV. DATE	REV. BY

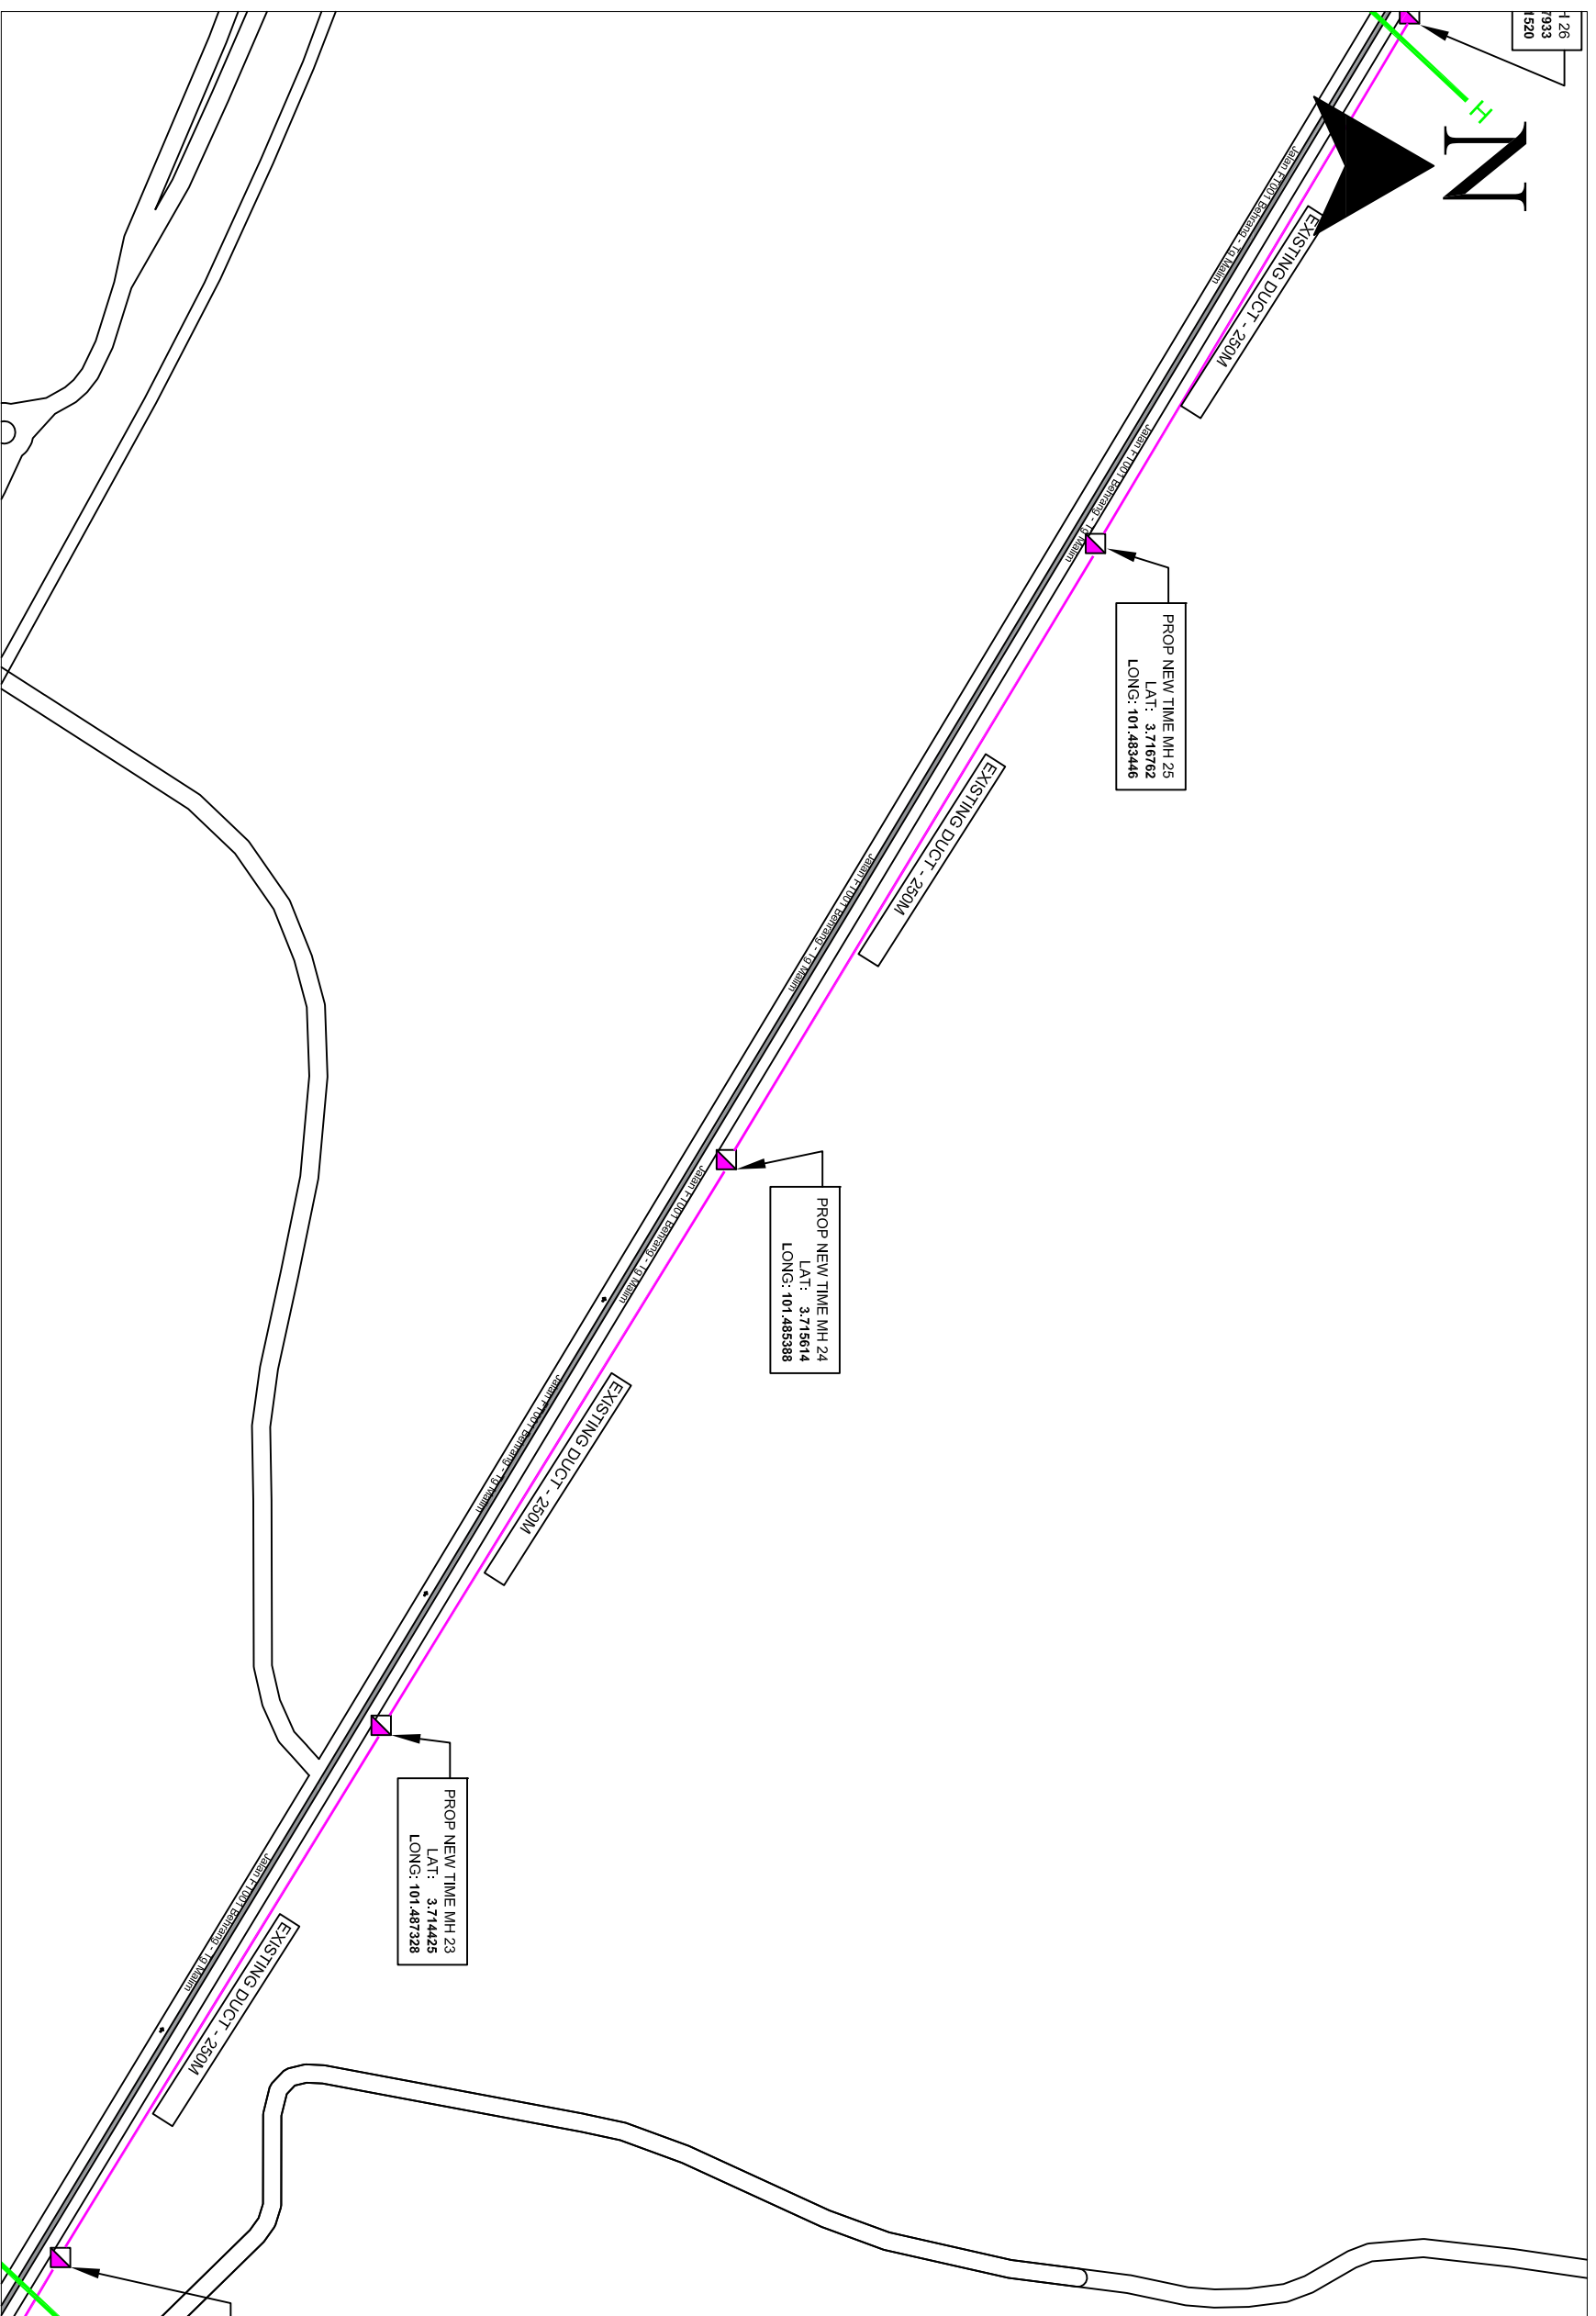

Local Authorities:-

LEGEND :-

- = EXISTING BUILDING MANHOLE
- = EXISTING TIME MH
- = PROPOSE NEW TIME MH
- - - = PROPOSED NEW CABLE DUCT
- = PROPOSED INSTALL G.I PIPE
- 1W / 4W = 2 WAY OR 4 WAY DUCT

DRAWING SCALE:	DRAWING UNITS:
N.T.S	METER
PREPARED BY: TECOM ENERGY SDN. BHD.	INITIAL & DATE: 27/11/2024
DESIGNED BY: TECOM ENERGY SDN. BHD.	INITIAL & DATE: 27/11/2024
CHECKED BY: TECOM ENERGY SDN. BHD.	INITIAL & DATE: 27/11/2024
APPROVED BY: TT DOTCOM SDN. BHD.	INITIAL & DATE: -


PROJECT TITLE: PROPOSED SITE PLAN - SO_UPSI: 2ND ROUTE	
DRAWING TITLE: PROPOSED PLAN VIEW DRAWING - SO UPSI: 2ND ROUTE	DRAWING NO: E3911
SHEET NO: 1/2	

timeTM

TT dotCom Sdn Bhd (52371-A)
No 14, Jalan Majistret U1/26,
Hicom Glenmarie Industrial Park
40150 Shah Alam, Selangor Darul Ehsan, Malaysia.
Tel: +60 3 5032 6000
Website: www.time.com.my

Tecom Energy Sdn. Bhd. (1255358-W)
No 35-B, Jalan PP 2/5,
Taman Putra Prima,
47100 Puchong, Selangor Darul Ehsan.
Tel: +603 5886 2005
E-mail: info@tecom.my

REV. NO.	REV. DATE	REV. BY

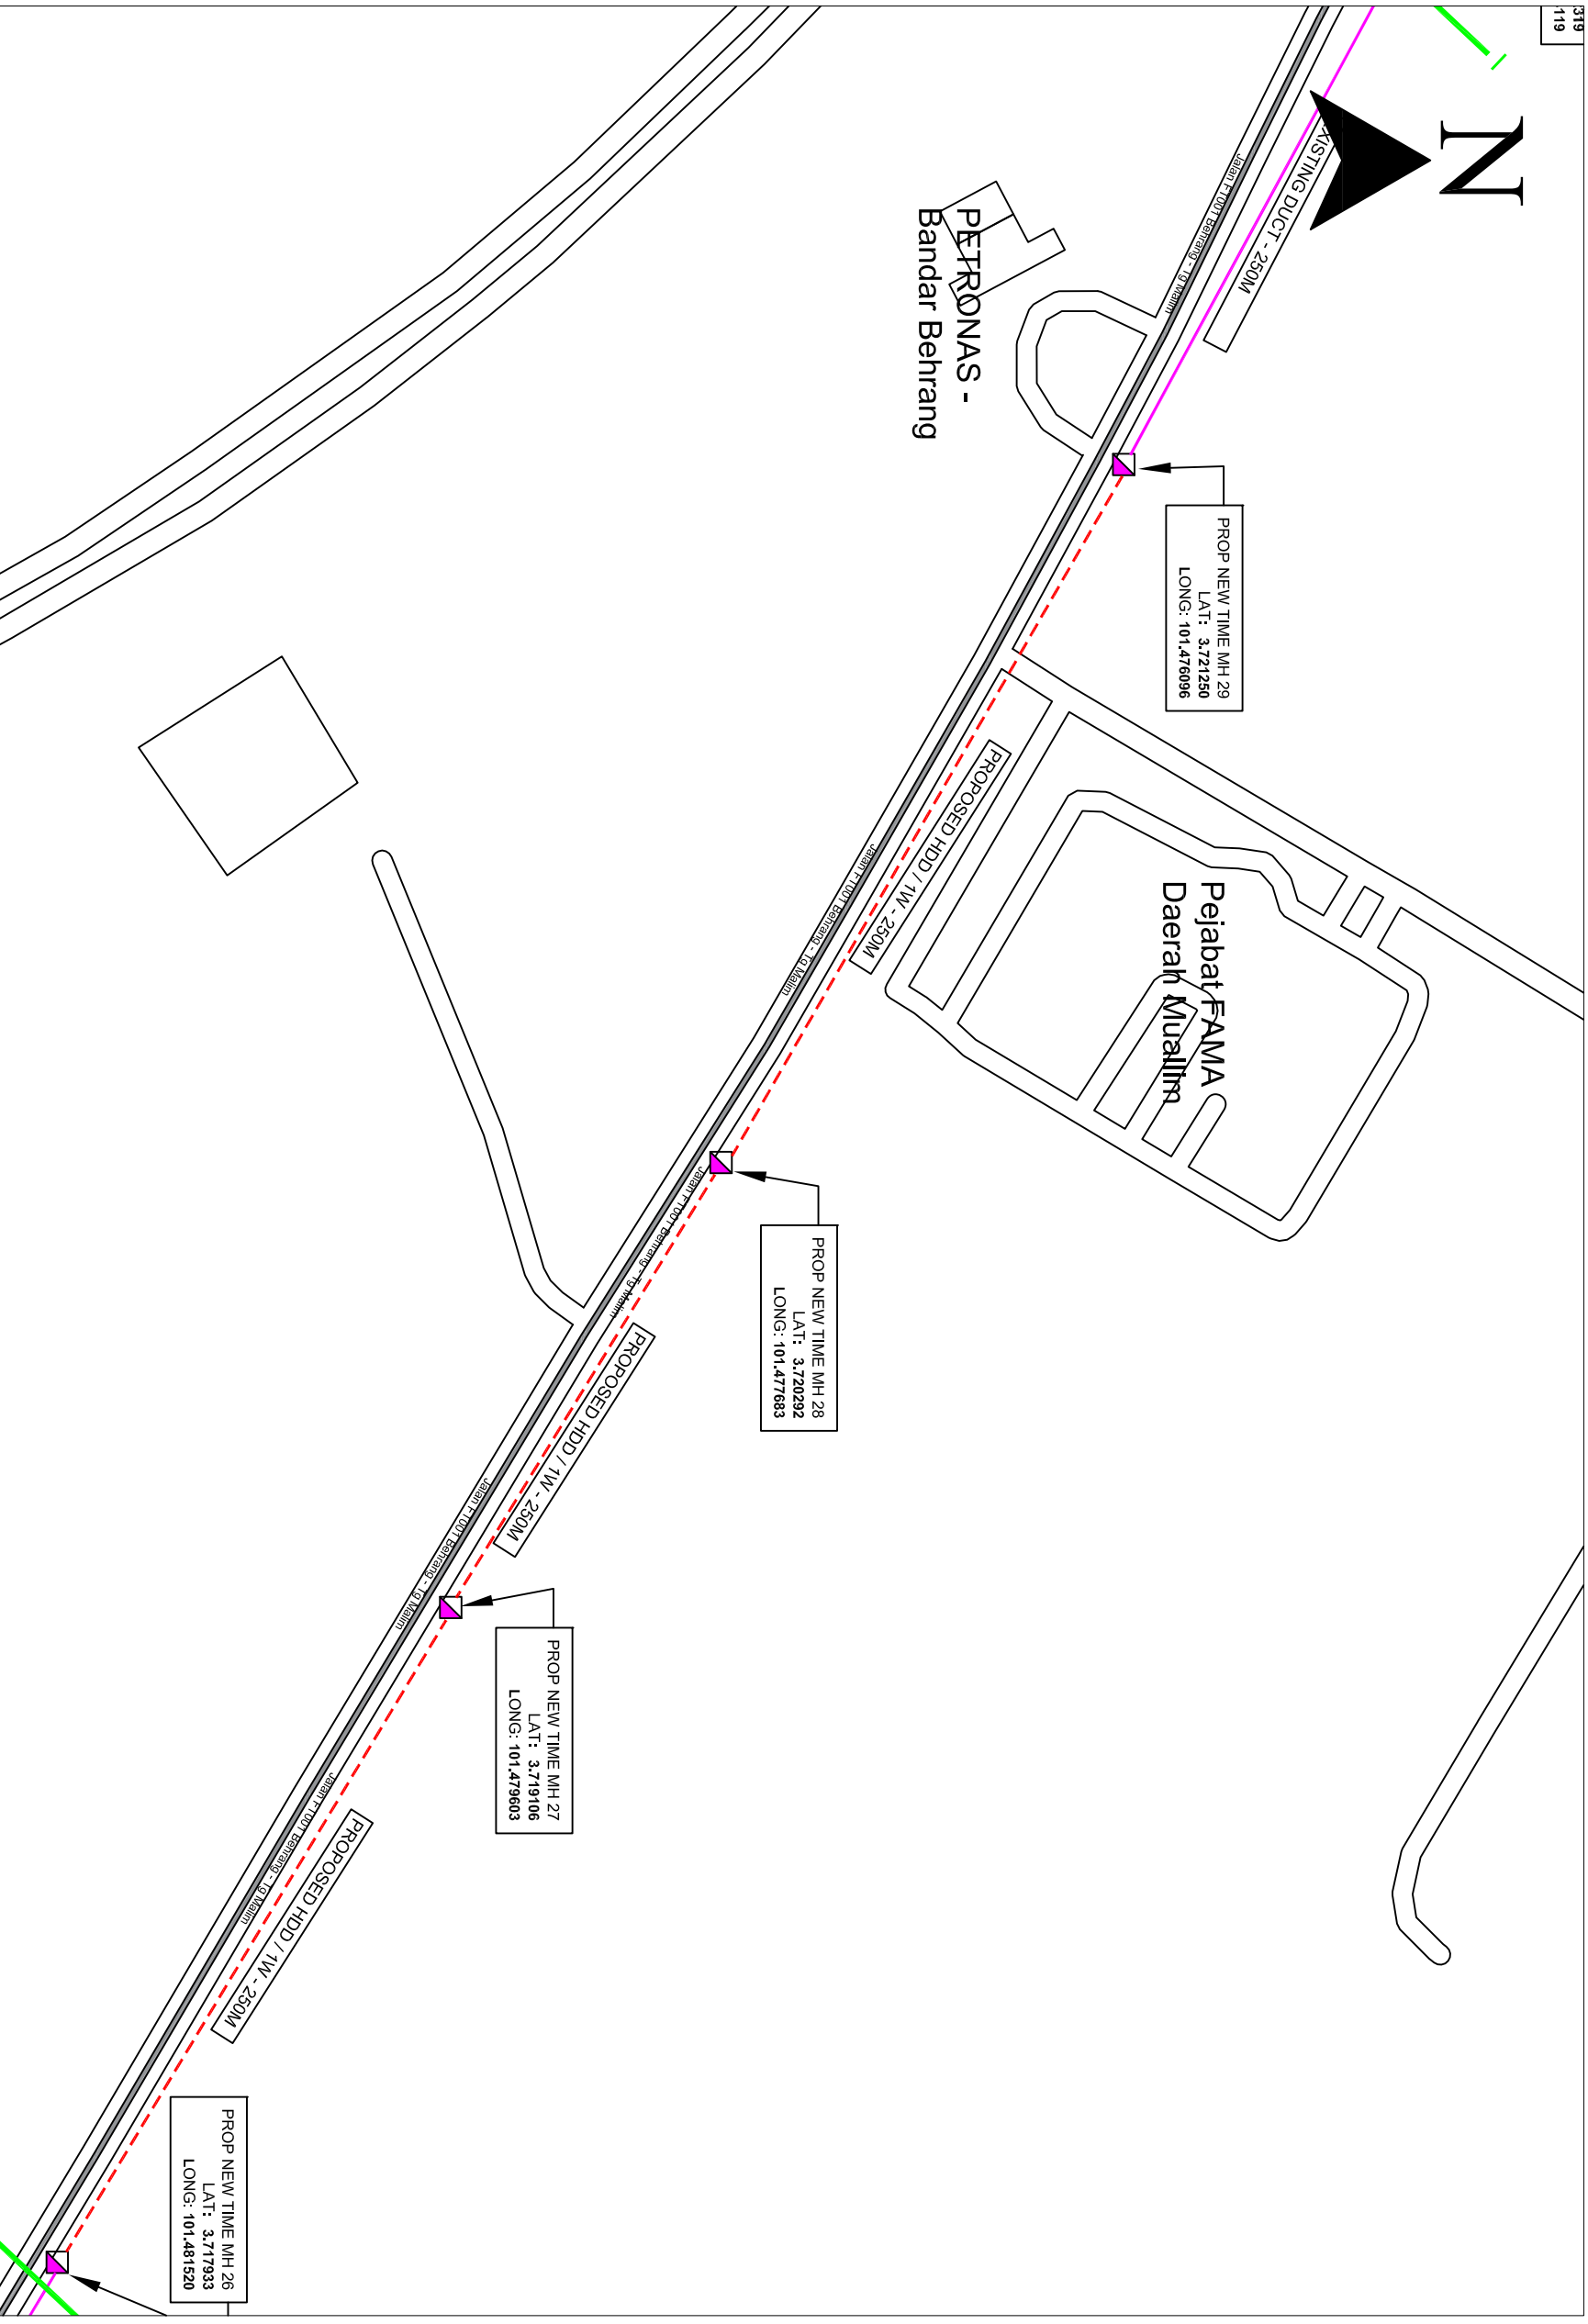

KELULUSAN PLAN

Local Authorities:-

LEGEND :-

- = EXISTING BUILDING MANHOLE
- = EXISTING TIME MH
- = PROPOSE NEW TIME MH
- - - = PROPOSED NEW CABLE DUCT
- = PROPOSED INSTALL G.I PIPE
- 1W / 4W = 2 WAY OR 4 WAY DUCT

REV. NO.	REV. DATE	REV. BY




Tecom Energy Sdn. Bhd. (1255358-W)
 No 35-B, Jalan PP 2/5,
 Taman Putra Prima,
 47100 Puchong, Selangor Darul Ehsan.
 Tel: +603 5886 2005
 E-mail: info@tecom.my



TT dotCom Sdn Bhd (52371-A)
 No 14, Jalan Majistret U1/26,
 Hicom Glenmarie Industrial Park
 40150 Shah Alam, Selangor Darul Ehsan, Malaysia.
 Tel: +60 3 5032 6000
 Website: www.time.com.my

PROJECT TITLE: PROPOSED SITE PLAN – SO_UPSI: 2ND ROUTE
DRAWING TITLE: PROPOSED PLAN VIEW DRAWING – SO UPSI: 2ND ROUTE
DRAWING NO: E3911
SHEET NO: 1/2

DRAWING SCALE: N.T.S	DRAWING UNITS: METER
PREPARED BY: TECOM ENERGY SDN. BHD.	INITIAL & DATE: 27/11/2024
DESIGNED BY: TECOM ENERGY SDN. BHD.	INITIAL & DATE: 27/11/2024
CHECKED BY: TECOM ENERGY SDN. BHD.	INITIAL & DATE: 27/11/2024
APPROVED BY: TT DOTCOM SDN. BHD.	INITIAL & DATE: -

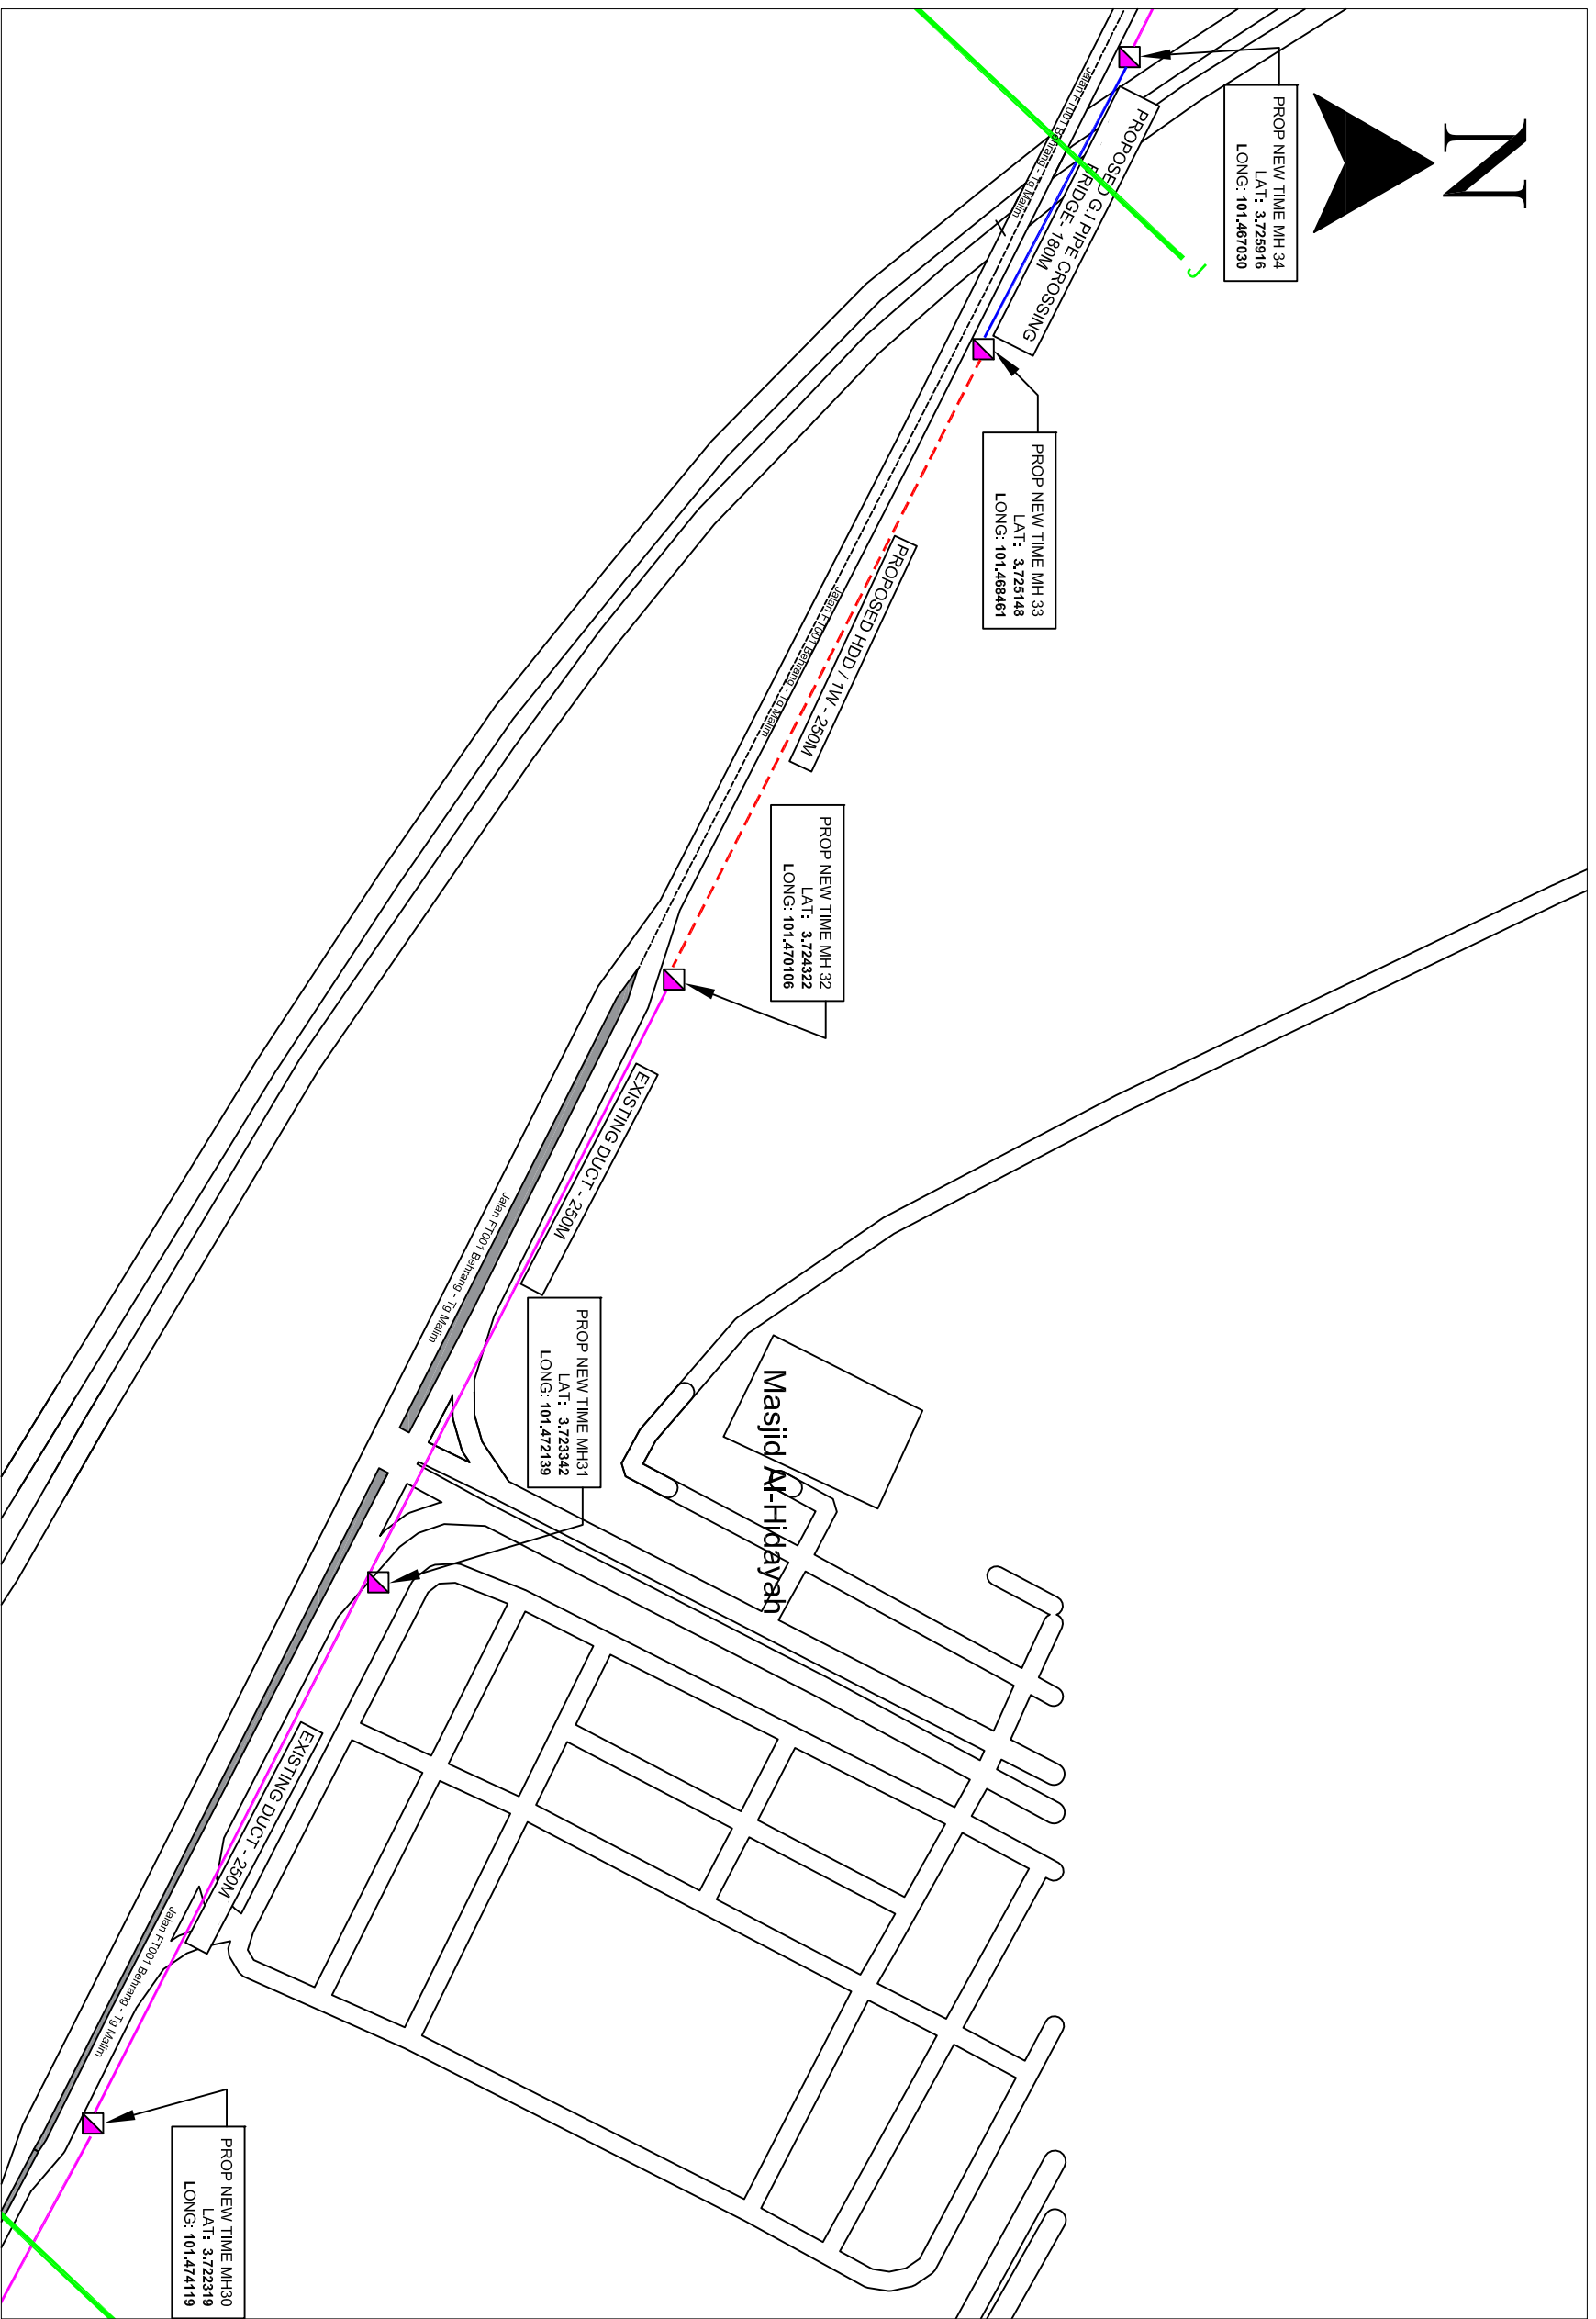

Local Authorities:-

LEGEND :-

- = EXISTING BUILDING MANHOLE
- = EXISTING TIME MH
- = PROPOSED NEW TIME MH
- - - = PROPOSED NEW CABLE DUCT
- = PROPOSED INSTALL G.I PIPE
- 1W / 4W = 2 WAY OR 4 WAY DUCT

DRAWING SCALE:	DRAWING UNITS:
N.T.S	METER
PREPARED BY:	INITIAL & DATE:
TECOM ENERGY SDN. BHD.	27/11/2024
DESIGNED BY:	INITIAL & DATE:
TECOM ENERGY SDN. BHD.	27/11/2024
CHECKED BY:	INITIAL & DATE:
TECOM ENERGY SDN. BHD.	27/11/2024
APPROVED BY:	INITIAL & DATE:
TT DOTCOM SDN. BHD.	-

PROJECT TITLE:	
PROPOSED SITE PLAN – SO UPSI: 2ND ROUTE	
DRAWING TITLE:	
PROPOSED PLAN VIEW DRAWING – SO UPSI: 2ND ROUTE	
DRAWING NO:	E3911
	1
	SHEET NO:1/2


timeTM

TT dotCom Sdn Bhd (52371-A)
 No 14, Jalan Majistret U1/26,
 Hicom Glenmarie Industrial Park
 40150 Shah Alam, Selangor Darul Ehsan, Malaysia.
 Tel: +60 3 5032 6000
 Website: www.time.com.my

Tecom Energy Sdn. Bhd. (1255358-W)
 No 35-B, Jalan PP 2/5,
 Taman Putra Prima,
 47100 Puchong, Selangor Darul Ehsan.
 Tel: +603 5886 2005
 E-mail: info@tecom.my

REV. NO.	REV. DATE	REV. BY



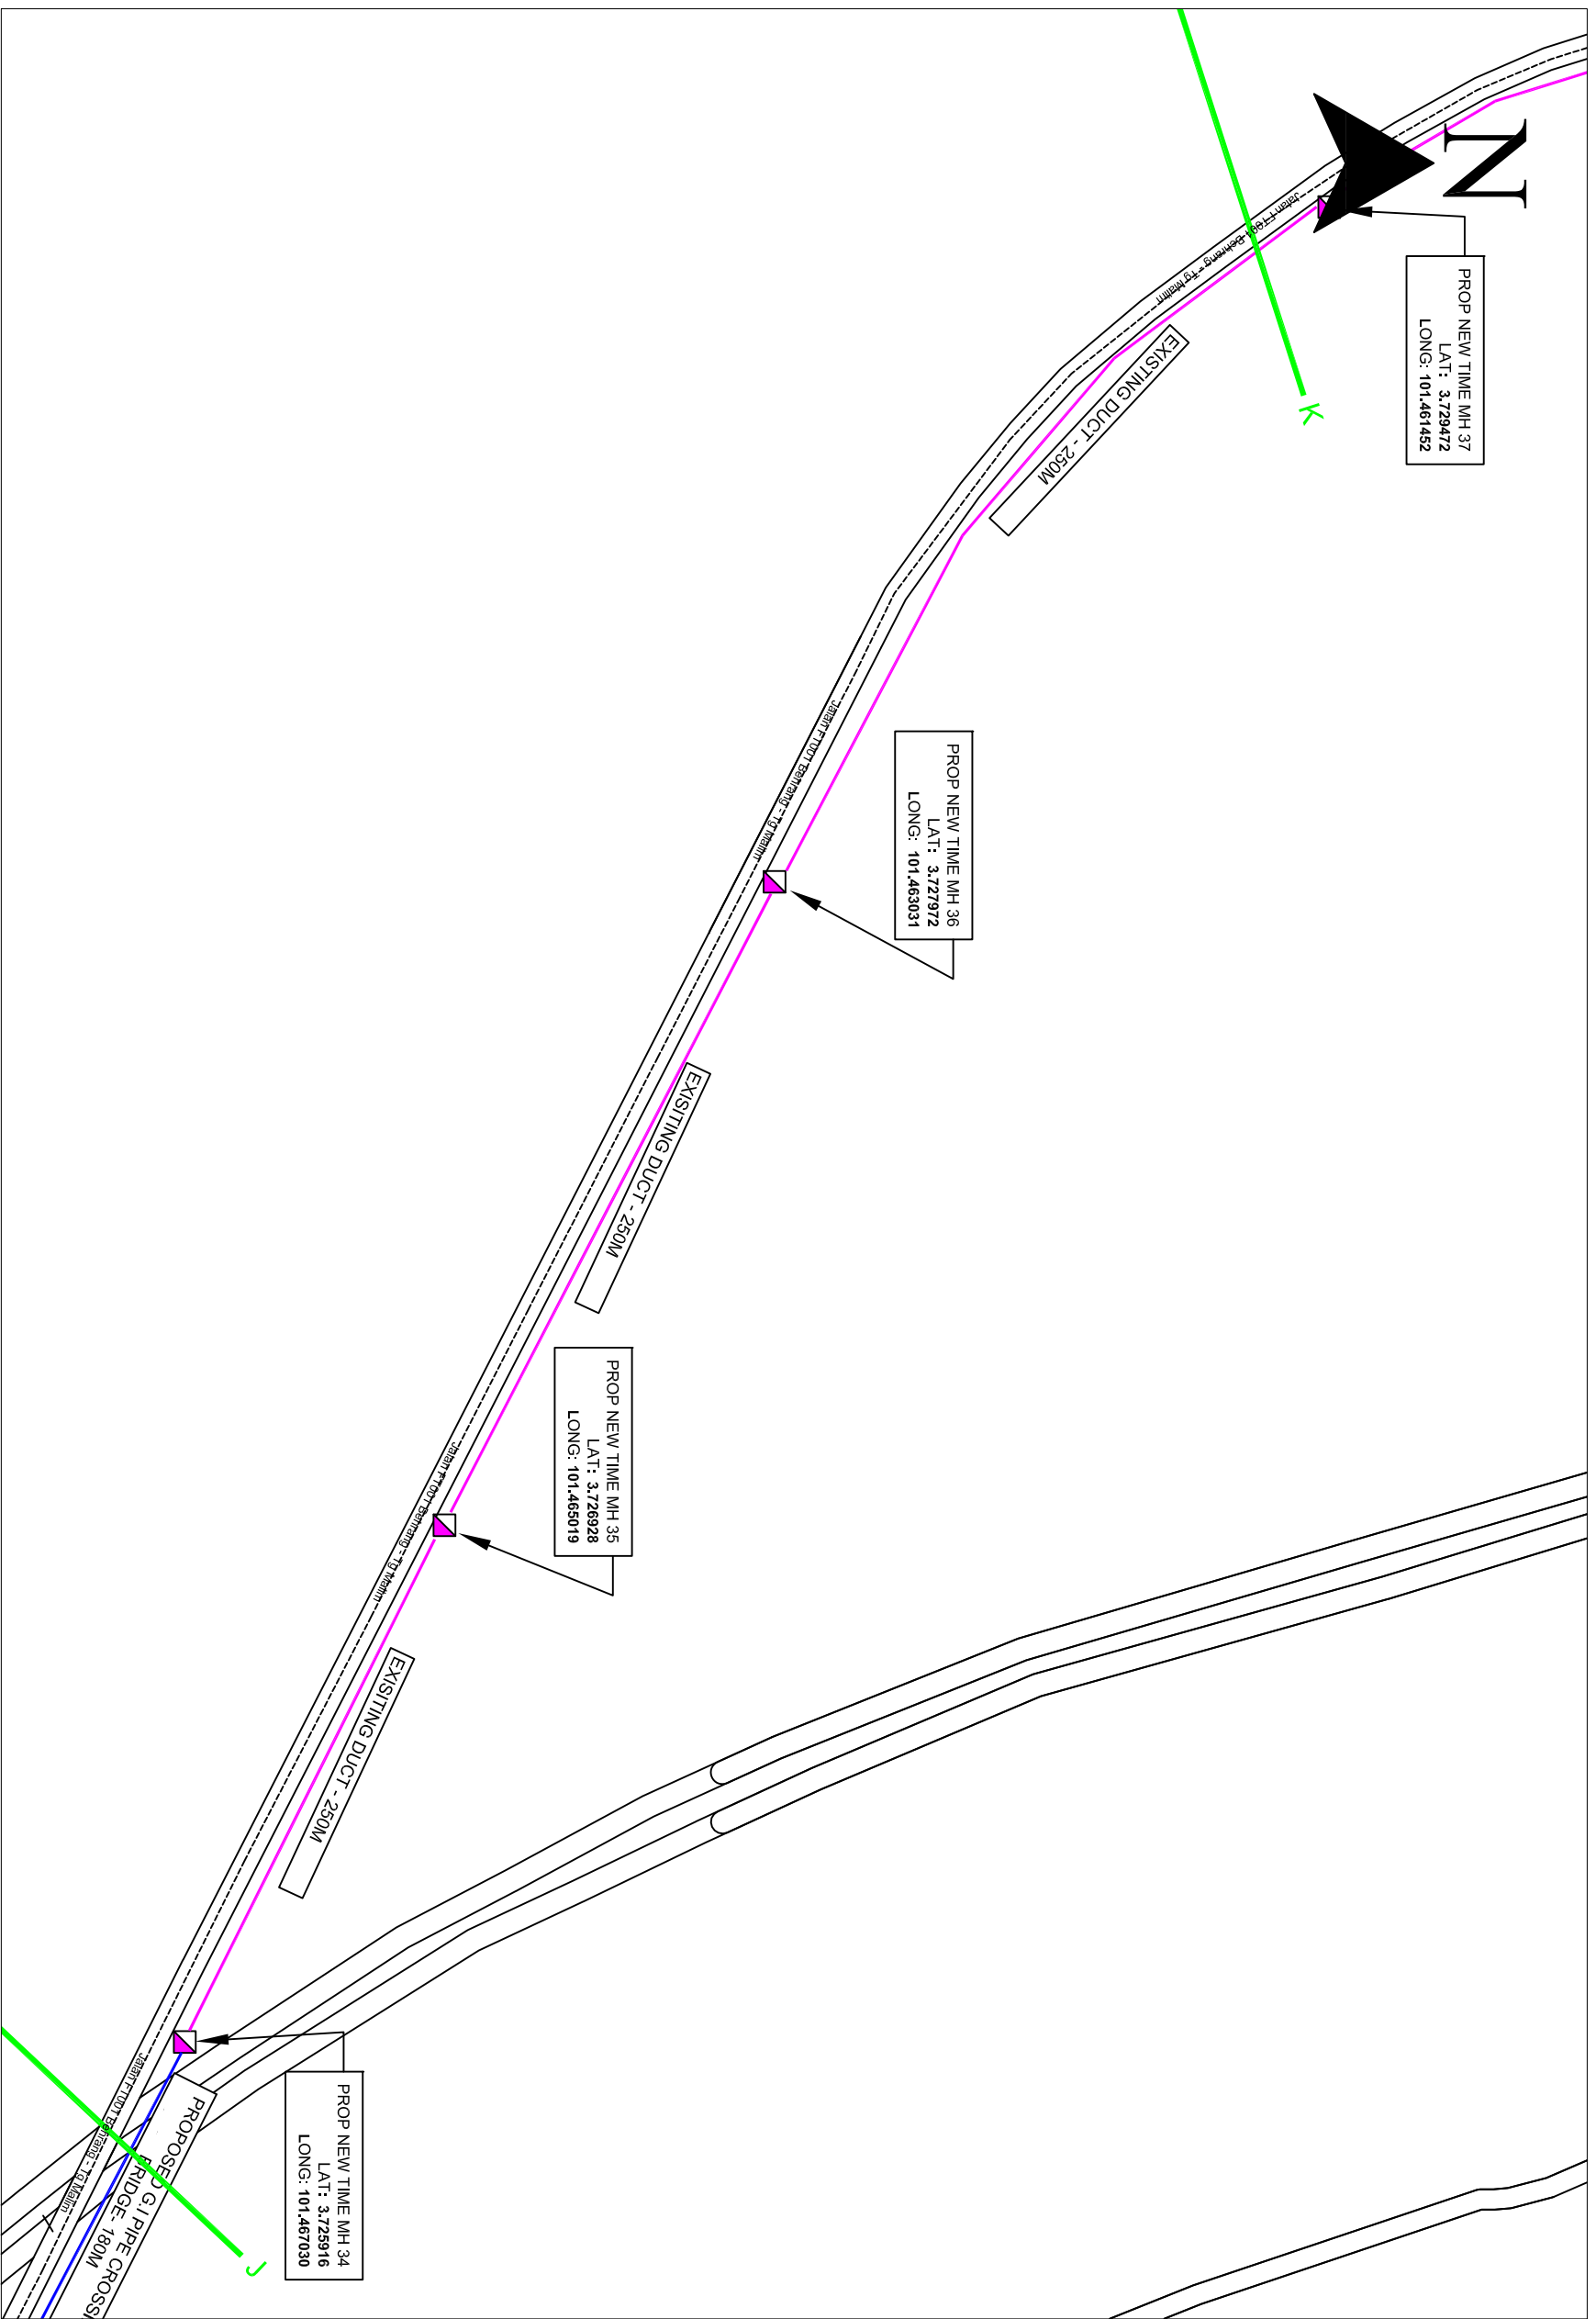

Local Authorities:-

LEGEND :-

- = EXISTING BUILDING MANHOLE
- = EXISTING TIME MH
- = PROPOSE NEW TIME MH
- - - = PROPOSED NEW CABLE DUCT
- = PROPOSED INSTALL G.I PIPE
- 1W / 4W = 2 WAY OR 4 WAY DUCT

REV. NO.	REV. DATE	REV. BY





Tecom Energy Sdn. Bhd. (1255358-W)
 No 35-B, Jalan PP 2/5,
 Taman Putra Prima,
 47100 Puchong, Selangor Darul Ehsan.
 Tel: +603 5886 2005
 E-mail: info@tecom.my



TT dotCom Sdn Bhd (52371-A)
 No 14, Jalan Majistret U1/26,
 Hicom Glenmarie Industrial Park
 40150 Shah Alam, Selangor Darul Ehsan, Malaysia.
 Tel: +60 3 5032 6000
 Website: www.time.com.my

PROJECT TITLE:	PROPOSED SITE PLAN – SO_UPSI: 2ND ROUTE
DRAWING TITLE:	PROPOSED PLAN VIEW DRAWING – SO UPSI: 2ND ROUTE
DRAWING NO.:	E39111
SHEET NO.:	1/2

DRAWING SCALE:	DRAWING UNITS:
N.T.S	METER
PREPARED BY:	INITIAL & DATE:
TECOM ENERGY SDN. BHD.	27/11/2024
DESIGNED BY:	INITIAL & DATE:
TECOM ENERGY SDN. BHD.	27/11/2024
CHECKED BY:	INITIAL & DATE:
TECOM ENERGY SDN. BHD.	27/11/2024
APPROVED BY:	INITIAL & DATE:
TT DOTCOM SDN. BHD.	-

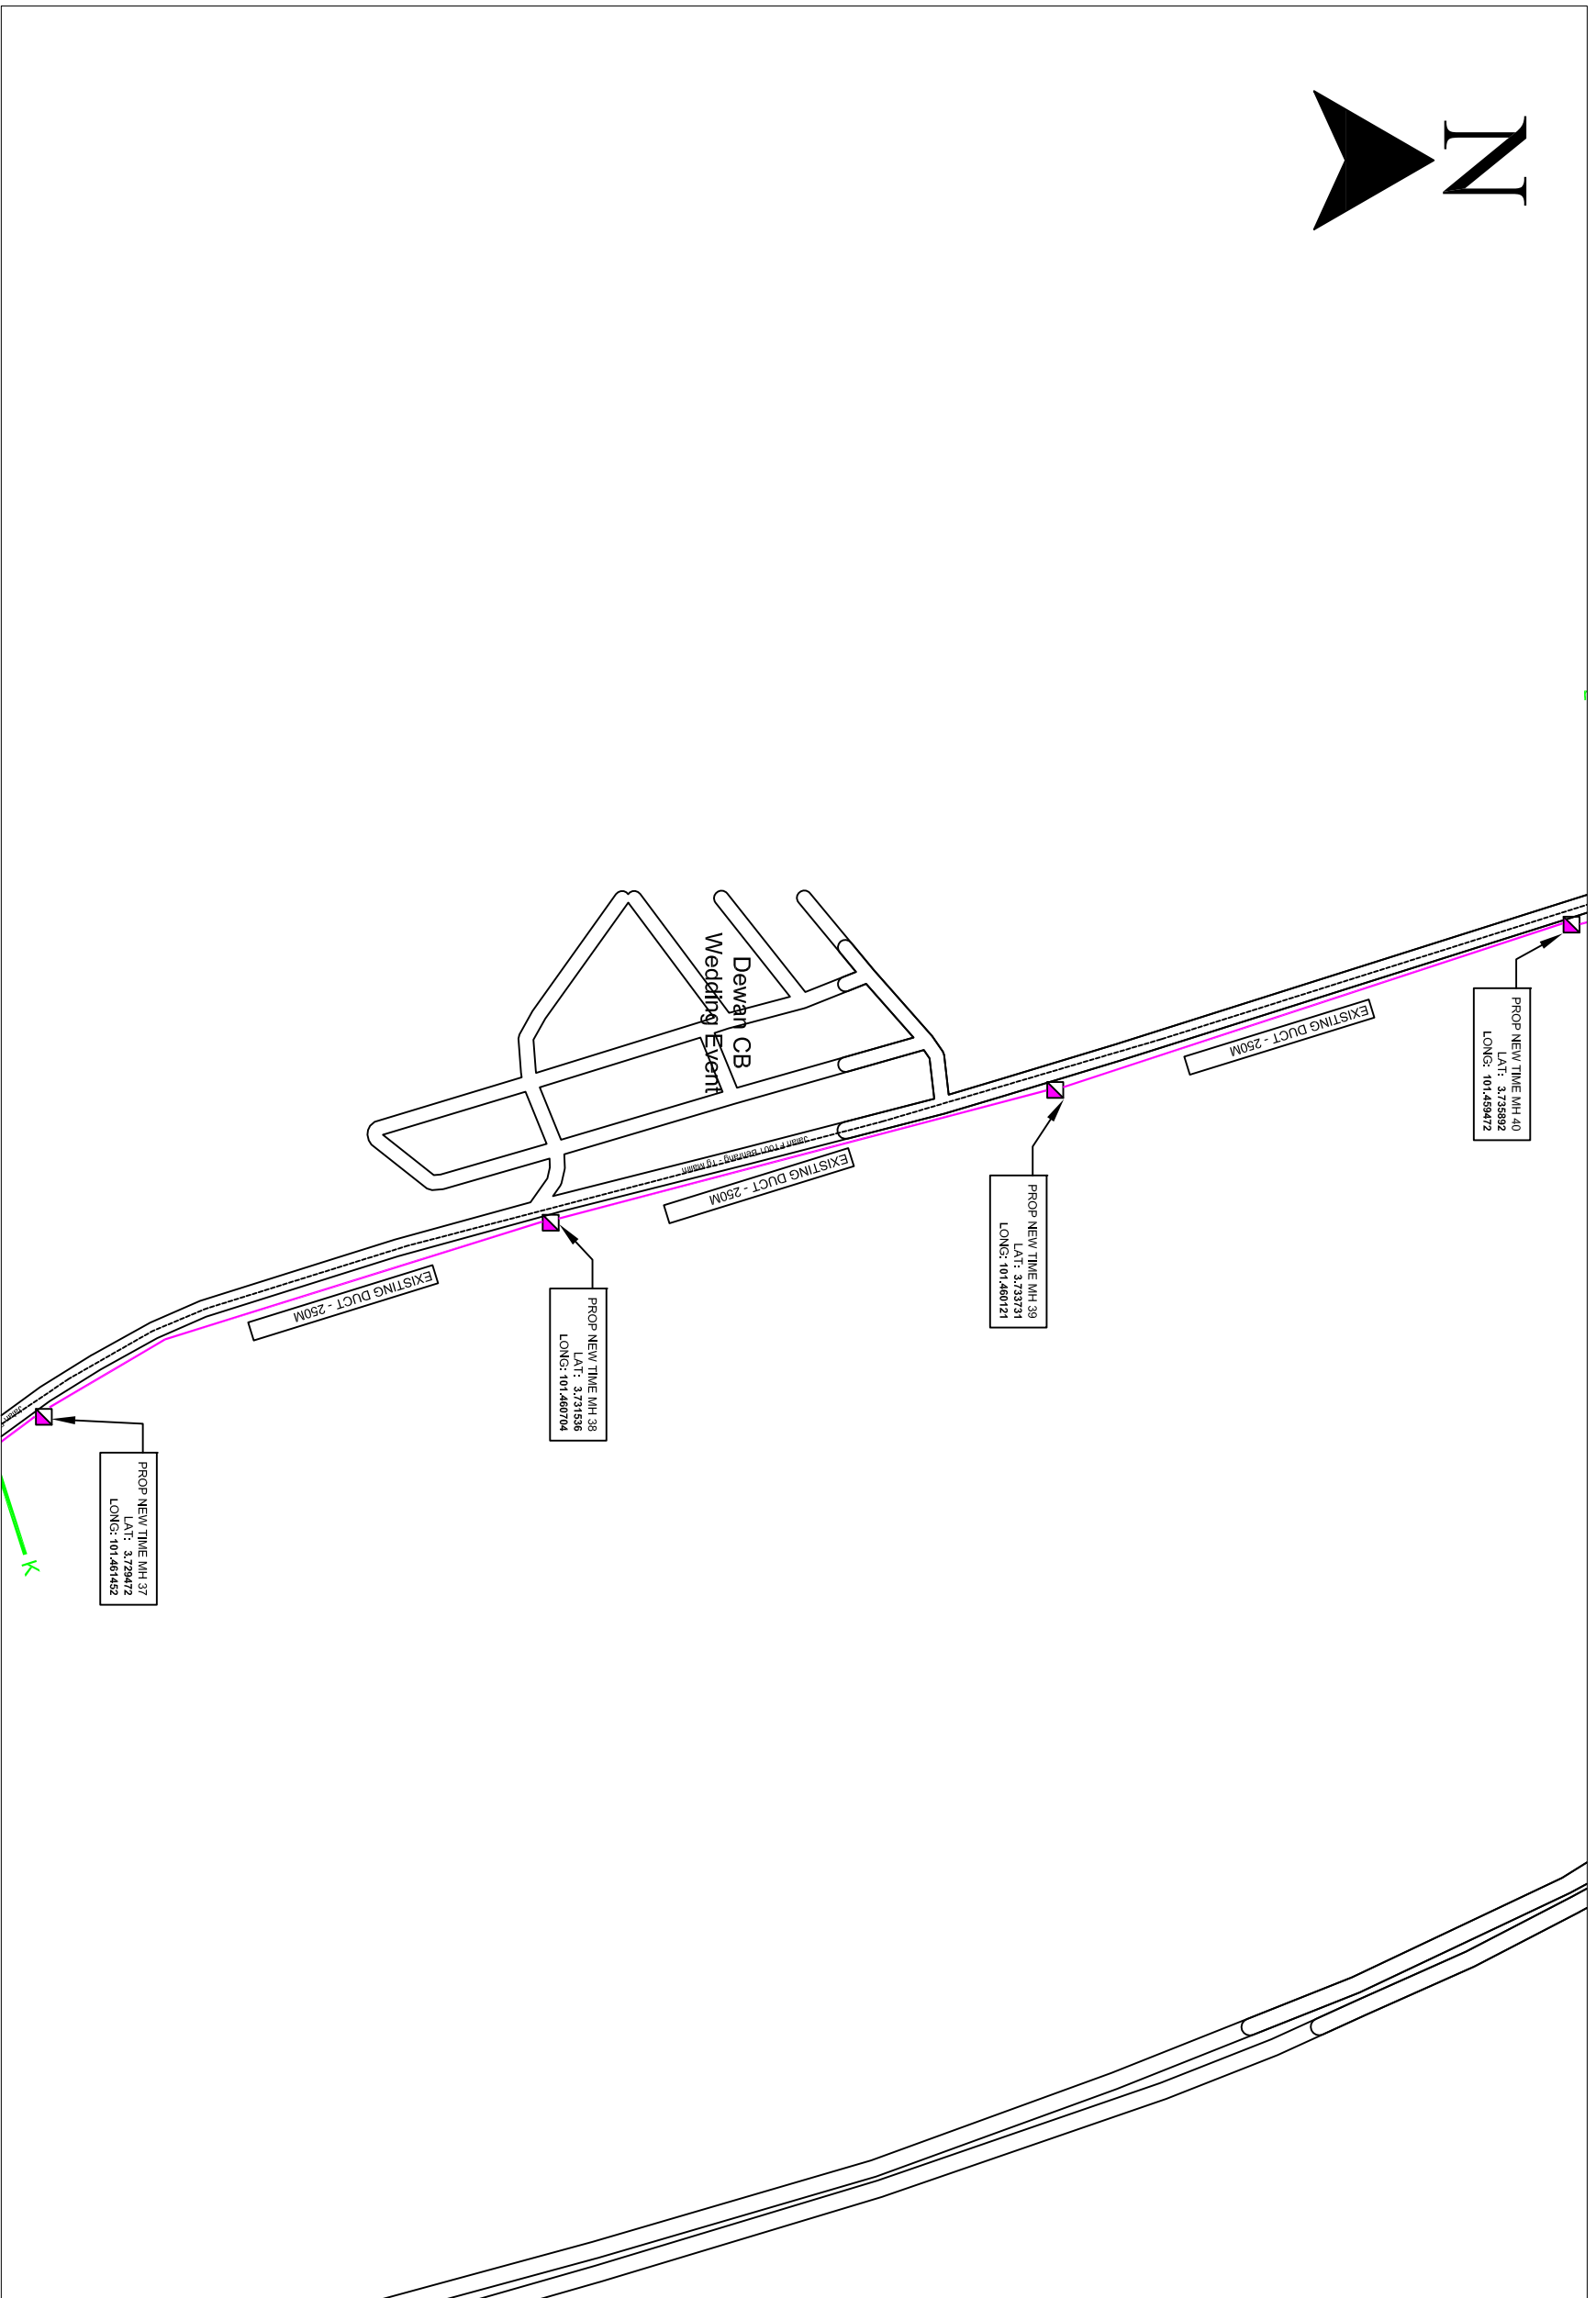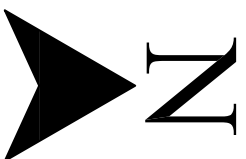

Local Authorities:-

LEGEND :-

- = EXISTING BUILDING MANHOLE
- = EXISTING TIME MH
- = PROPOSE NEW TIME MH
- - - = PROPOSED NEW CABLE DUCT
- = PROPOSED INSTALL G.I PIPE
- 1W / 4W = 2 WAY OR 4 WAY DUCT

REV. NO.	REV. DATE	REV. BY



Tecom Energy Sdn. Bhd. (12553558-W)

No 35-B, Jalan PP 2/5,
Taman Putra Prima,
47100 Puchong, Selangor Darul Ehsan.
Tel: +603 5886 2005
E-mail: info@tecom.my




TT dotCom Sdn Bhd (52371-A)

No 14, Jalan Majistret U1/26,
Hicom Glenmarie Industrial Park
40150 Shah Alam, Selangor Darul Ehsan, Malaysia.
Tel: +60 3 5032 6000
Website: www.time.com.my

PROJECT TITLE:	PROPOSED SITE PLAN – SO_UPSI: 2ND ROUTE
DRAWING TITLE:	PROPOSED PLAN VIEW DRAWING – SO UPSI: 2ND ROUTE
DRAWING NO:	E3911 1 SHEET NO:1/2

DRAWING SCALE:	DRAWING UNITS:
N.T.S	METER
PREPARED BY:	INITIAL & DATE:
TECOM ENERGY SDN. BHD.	27/11/2024
DESIGNED BY:	INITIAL & DATE:
TECOM ENERGY SDN. BHD.	27/11/2024
CHECKED BY:	INITIAL & DATE:
TECOM ENERGY SDN. BHD.	27/11/2024
APPROVED BY:	INITIAL & DATE:
TT DOTCOM SDN. BHD.	-

KELULUSAN PLAN

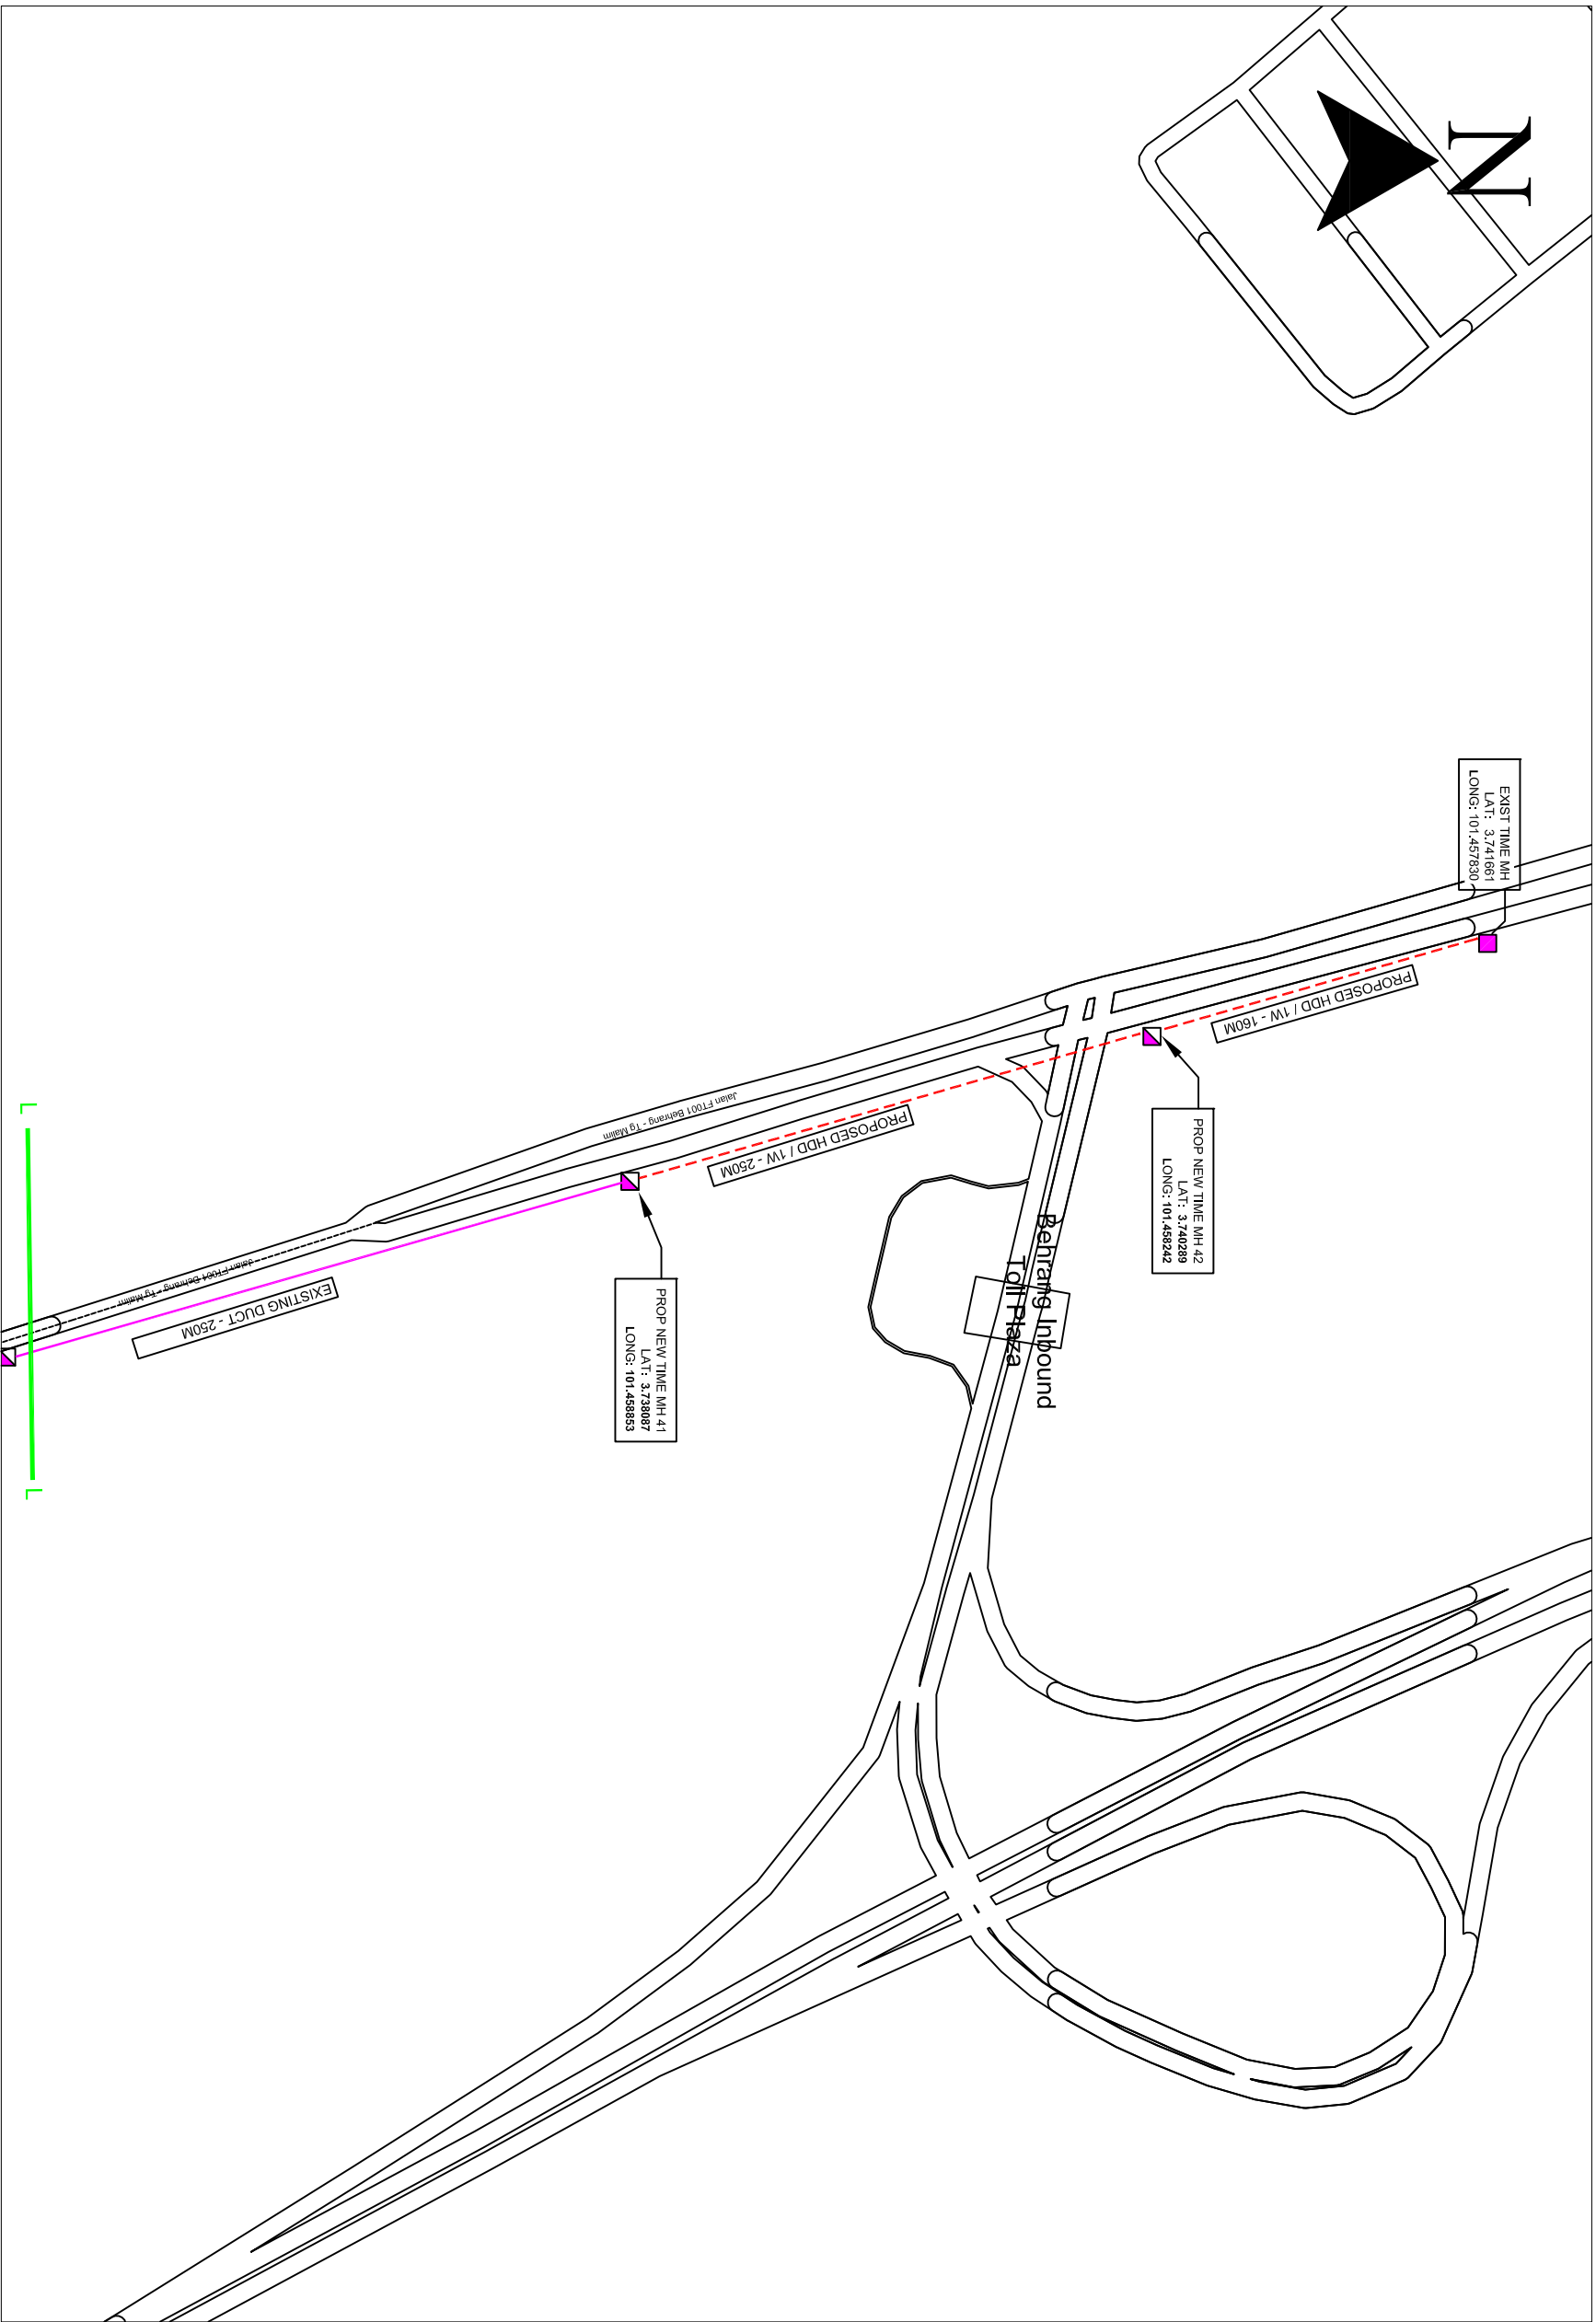

Local Authorities:-

LEGEND :-

- = EXISTING BUILDING MANHOLE
- = EXISTING TIME MH
- = PROPOSE NEW TIME MH
- = PROPOSED NEW CABLE DUCT
- = PROPOSED INSTALL G.I PIPE
- 1W / 4W = 2 WAY OR 4 WAY DUCT

DRAWING SCALE:	DRAWING UNITS:
N.T.S	METER
PREPARED BY:	INITIAL & DATE:
TECOM ENERGY SDN. BHD.	27/11/2024
DESIGNED BY:	INITIAL & DATE:
TECOM ENERGY SDN. BHD.	27/11/2024
CHECKED BY:	INITIAL & DATE:
TECOM ENERGY SDN. BHD.	27/11/2024
APPROVED BY:	INITIAL & DATE:
TT DOTCOM SDN. BHD.	-

PROJECT TITLE:	
PROPOSED SITE PLAN – SO_UPSI: 2ND ROUTE	
DRAWING TITLE:	
PROPOSED PLAN VIEW DRAWING – SO UPSI: 2ND ROUTE	
DRAWING NO:	
E3911	1
SHEET NO:1/2	

TT dotCom Sdn Bhd (52371-A)
 No 14, Jalan Majistret U1/26,
 Hicom Glenmarie Industrial Park
 40150 Shah Alam, Selangor Darul Ehsan, Malaysia.
 Tel: +60 3 5032 6000
 Website: www.time.com.my

Tecom Energy Sdn. Bhd. (1255358-W)
 No 35-B, Jalan PP 2/5,
 Taman Putra Prima,
 47100 Puchong, Selangor Darul Ehsan.
 Tel: +603 5886 2005
 E-mail: info@tecom.my

REV. NO.	REV. DATE	REV. BY