




LEGEND

-  FIBRE TERMINATION BOARD (FTB)
-  600mm X 600mm X 1000mm TELEPHONE CABLE PIT C/W METAL COVER
-  2 WAYS 100mm SQ G.I PIPE SLEEVES CLASS 'C' LAID UNDERGROUND
-  JRCT TELEPHONE MANHOLE C/W HEAVY DUTY CONCRETE COVER
-  EXISTING TELEKOM MALAYSIA (TM) POLE

NOTE :-
ALL ROAD & DRAIN CROSSING AND EXPOSE DUCT SHALL BE COVERED WITH 150mm G.I PIPE SLEEVES CLASS 'C'

EXISTING TM POLE TO BE RELOCATE



SITE PLAN
MUKIM PULAU KERENGA
DAERAH MARANG
TERENGGANU
SYIT PIAWAI : 76 - B
SCALE 1 : 400
NO.PELAN AKUI : 8361
KELUASAN TAPAK : 8701 m²

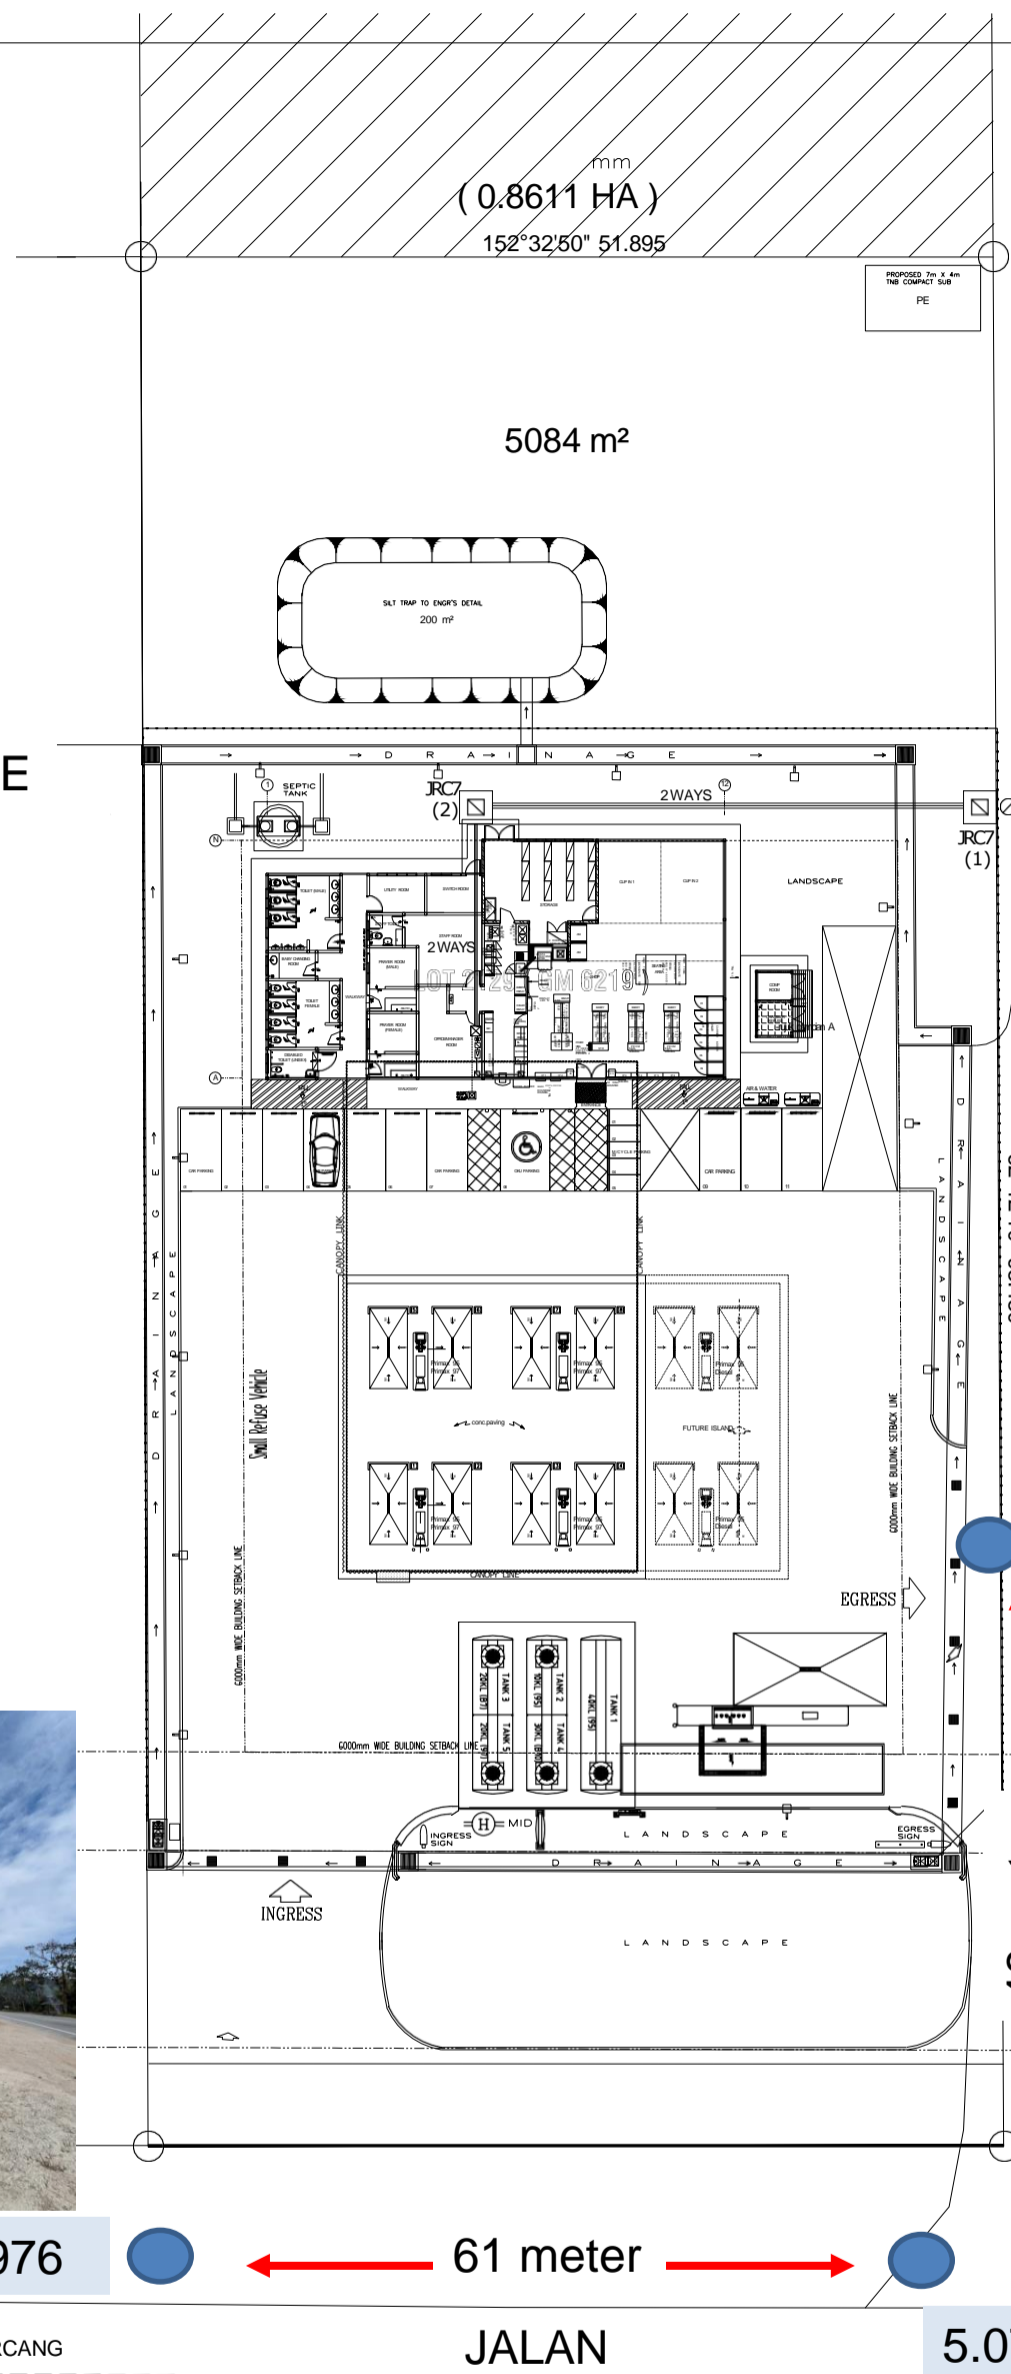

5.079058, 103.271976

5.079240, 103.271371

5.079421, 103.271766

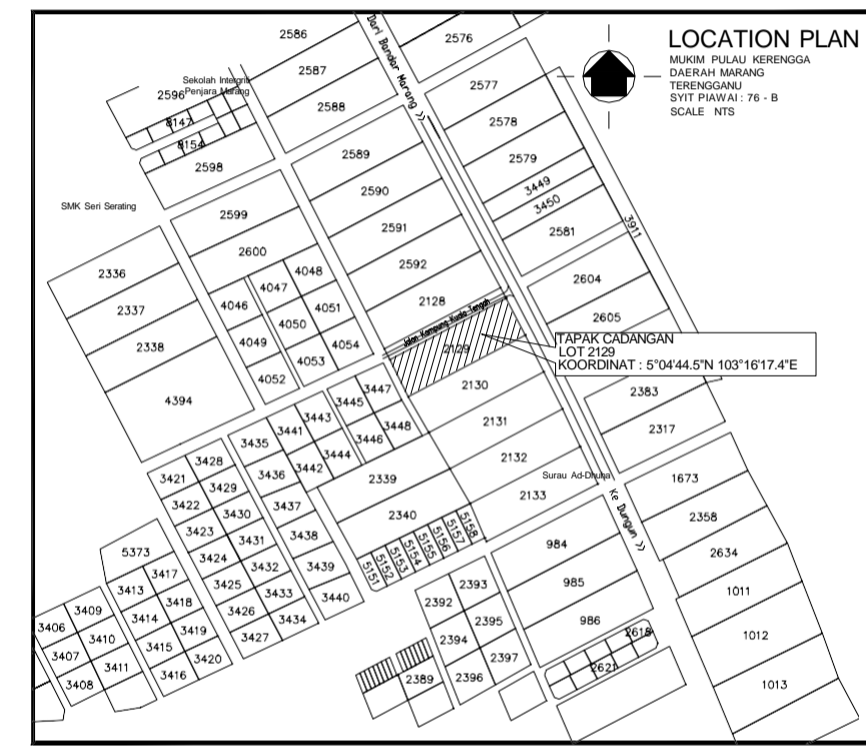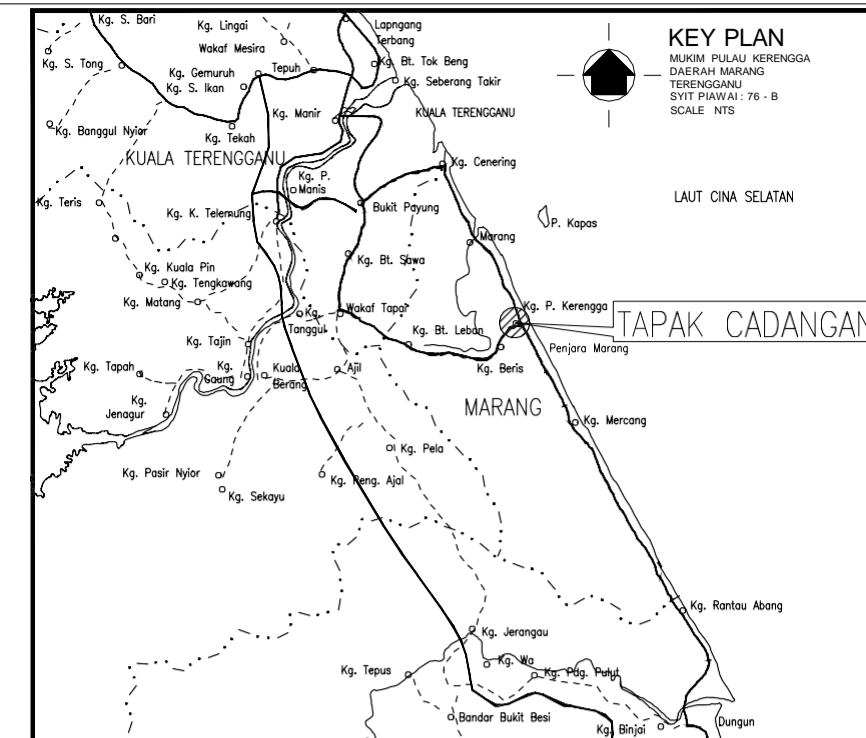

LAND/BUILDING OWNER

MOHD ZAKRI BIN MOHAMAD NOR
NO. K/P : 810412-11-9221

KAMPUNG PULAU RUSA,
MERCHANG, MARANG,
21610 TERENGGANU.

ARCHITECT

ZAIZA MULIATI BINTI ZAINAL @ ZAKARIA
NO. K/P : 810519-11-5408

NO.45, TAMAN EMAS MURNI,
MARANG,
21600 TERENGGANU.

WMK
WM KHAIRI architect
No. 24-5 KT Business Centre,
Jalan Sultan Mohamad,
21100 Kuala Terengganu,
Terengganu Darul Iman.
Tel/Fax : 09-62655663
Email : wmk.architect@gmail.com

CIVIL AND STRUCTURAL ENGINEER

MESH ENGINEERS SDN BHD
CIVIL, STRUCTURAL, MECHANICAL AND ELECTRICAL
Consulting Engineers

No. 26-5 KT Business Centre
Padang Hiliran
21100 Kuala Terengganu
T. 09 6266630 F. 09 6265508
E1. meshengineers@gmail.com
E2. meshengineers@yahoo.com

MECHANICAL AND ELECTRICAL ENGINEER

I hereby certify that these works have been designed by me in accordance with sound engineering and that I take full responsibility for the design and proper performance of the same

Ir. Aminuddin Bin A. Kadir
P. Eng. ELECTRICAL

MESH ENGINEERS SDN BHD
CIVIL, STRUCTURAL, MECHANICAL AND ELECTRICAL
Consulting Engineers

No. 26-5 KT Business Centre
Padang Hiliran
21100 Kuala Terengganu
T. 09 6266630 F. 09 6265508
E1. meshengineers@gmail.com
E2. meshengineers@yahoo.com

PROJECT

PERMOHONAN PELAN KERANA MENDIRIKAN
STESEN MINYAK DAN 1 UNIT KEDAI
SERBANEKA 1 TINGKAT KEKAL DI ATAS
NO. LOT PT 35615 (HSM 16590)
DI ALOR KOLEK, MUKIM PULAU KERENGA,
DAERAH MARANG,
TERENGGANU DARUL IMAN.

DRAWING TITLE

TELECOMMUNICATION SYSTEM
SITE PLAN
- EXTERNAL UNDERGROUND PIPE ROUTING LAYOUT

SCALE	DESIGN	NAJIB	DRAWN	AFIQ
A3 1 : 200				
A1 1 : 100	CHECKED		DATE	JUNE 2023
	Ir. AMINNUDIN			
JOB No	DRAWING No	REVISION		
2007	MESH / 2007 / M&E / E / TM - 01			

CONSTRUCTION DRAWING