
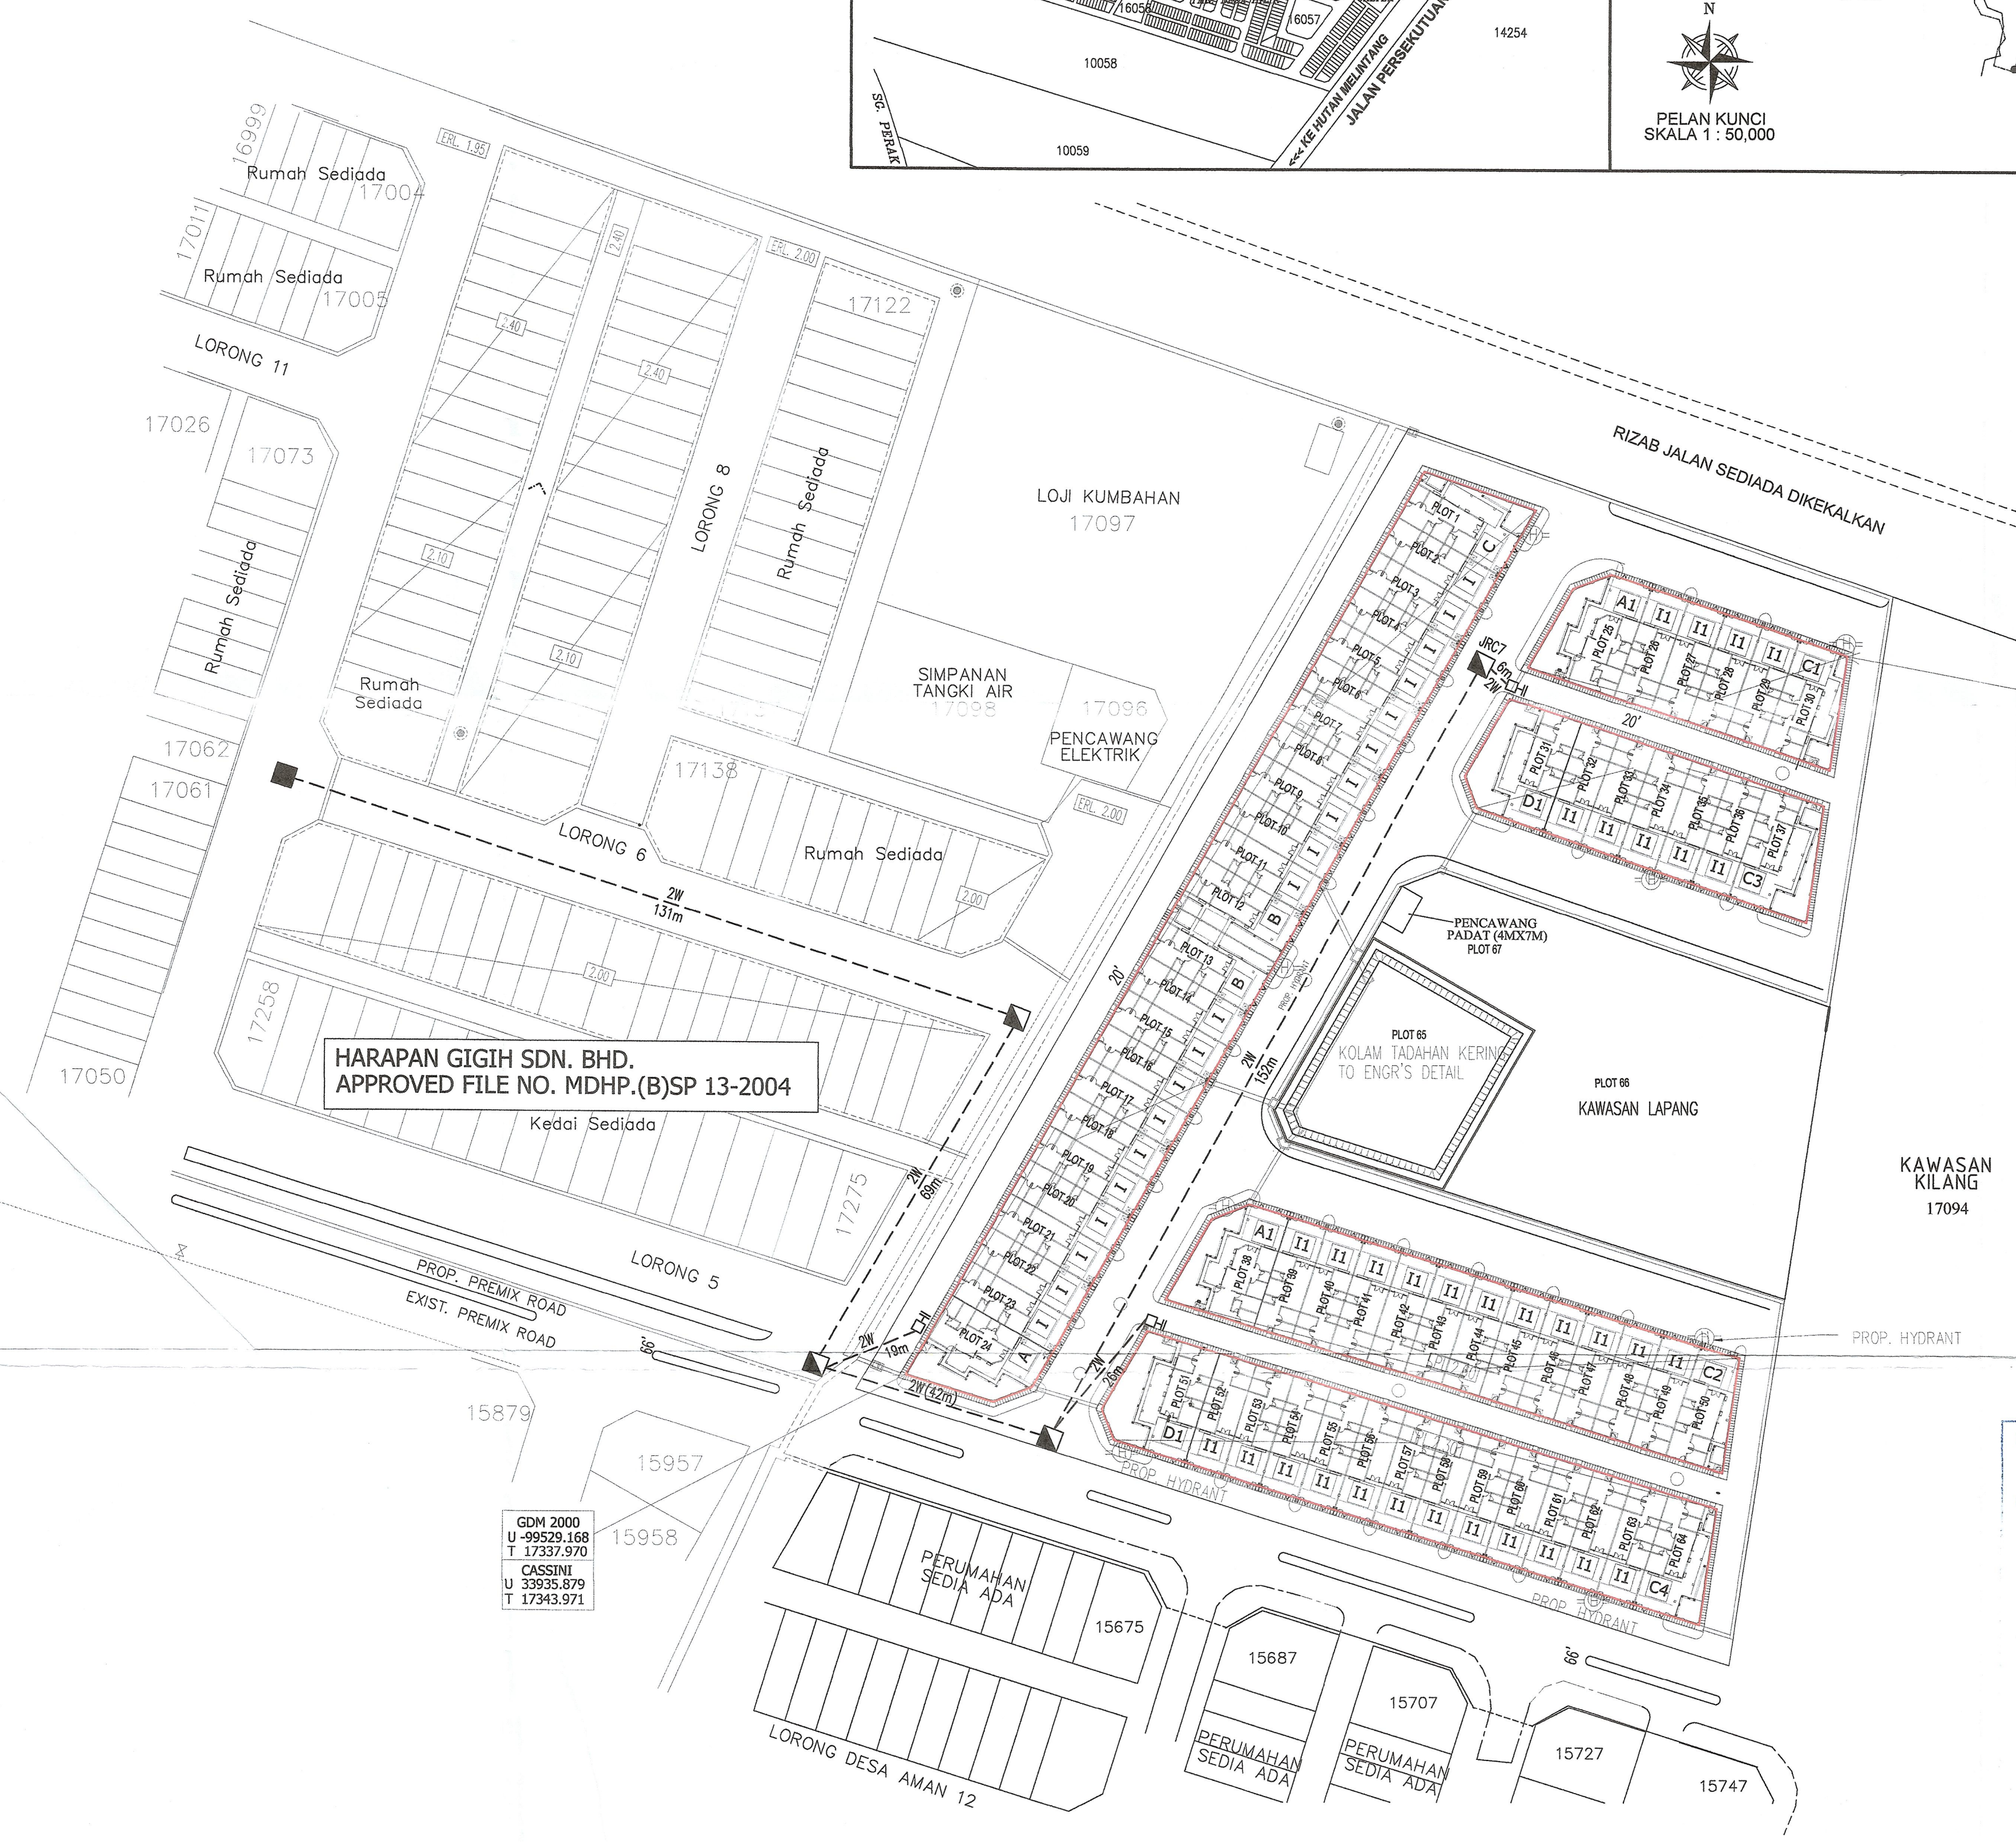


MUKIM DURIAN SEBATANG
DAERAH HILIR PERAK
SYIT : 909
SKALA 1 : 750

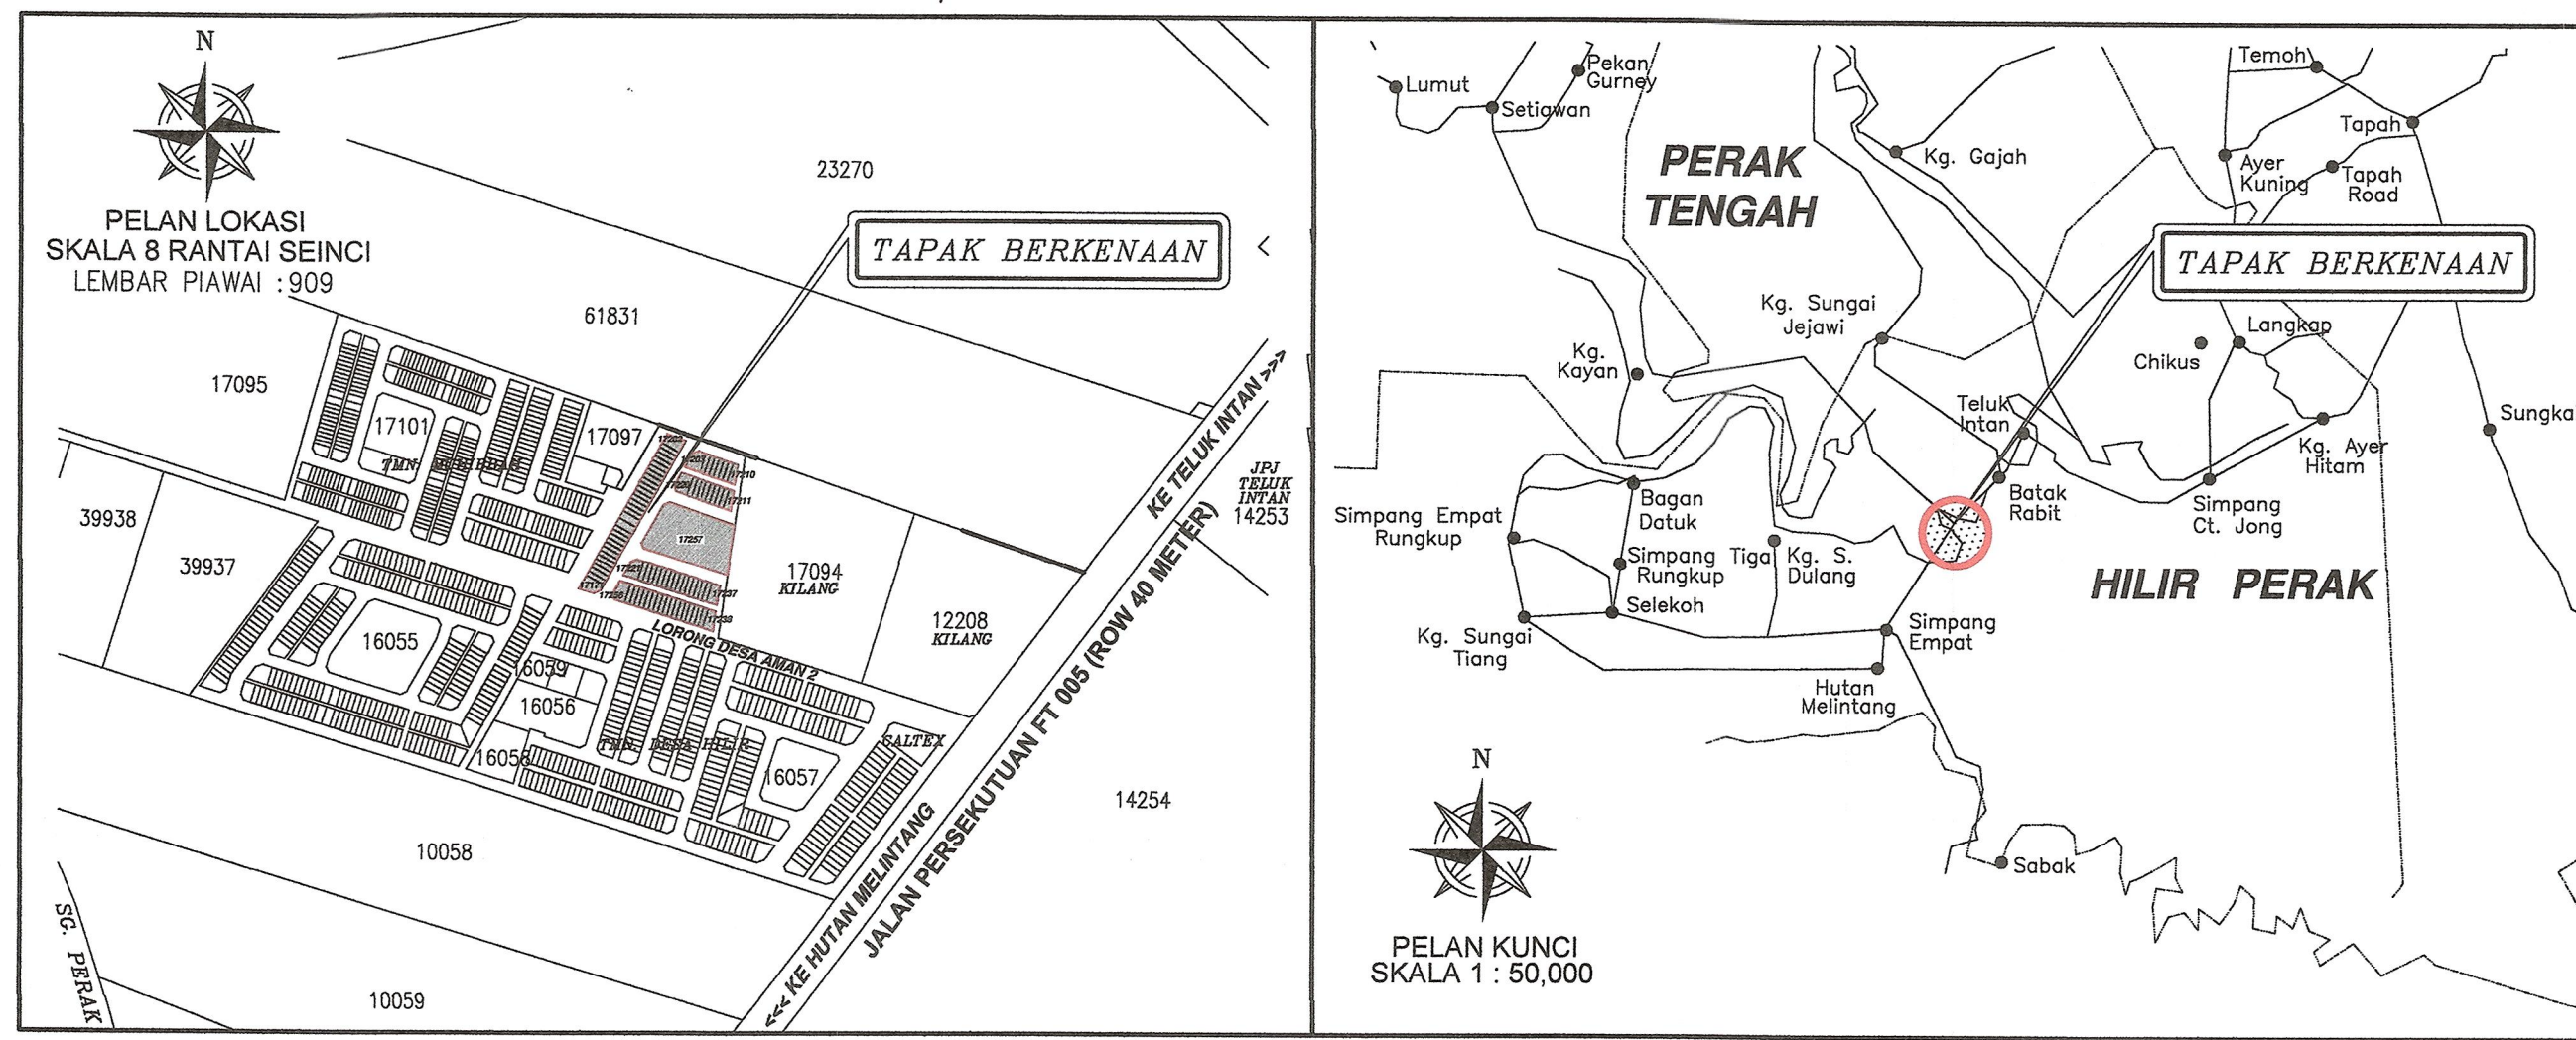

HARAPAN GIGIH SDN. BHD.
APPROVED FILE NO. MDHP.(B)SP 13-2004

GDM 2000
U -99405.321
T 17498.743
CASSINI
U 34059.726
T 17504.744

GDM 2000
U -99529.168
T 17337.970
CASSINI
U 33935.879
T 17343.971

PELAN LUARAN TELAH DISEMAK DAN DILULUSKAN
TELEKOM MALAYSIA

DISEMAK OLEH: *[Signature]*
Pegawai Teknik
Integrated Planning Perak
Network Development North
Network Development, IT & Network Technology
Area 4, Bangunan T4
Jalan Jelepong, 30020 IPOH.

DILULUSKAN OLEH: *[Signature]*
SYARIL BIN HASAN
Assistant Manager
Integrated Planning Perak
Network Development North
Network Development, IT & Network Technology
Area 4, Bangunan T4
Jalan Jelepong, 30020 IPOH.

DIKIRAN: *[Signature]*
MSE 2202/673/1111

- LEGEND
- PROPOSED JC9/C (M) TEL. MANHOLE
C/W HEAVY DUTY COVER
 - PROPOSED JRC7 (M) TEL. MANHOLE
C/W HEAVY DUTY COVER
 - PROPOSED 30"x18"x30" TEL. JOINTING PIT JB30
C/W HEAVY DUTY COVER AND STUMP
 - PROPOSED 2 NOS. 100mm PVC UNDERGROUND
DUCTS ROUTE
 - EXISTING TEL. MANHOLE

TITLE
KEY, LOCATION AND SITE PLAN
-EXTERNAL TELEPHONE LAYOUT

PROJECT
CADANGAN MEMBINA 64 UNIT RUMAH TERES
SATU TINGKAT DI ATAS PLOT 1 - PLOT 64
(LOT 17171 - LOT 17234), SEBAHAGIAN LOT
17171 HINGGA LOT 17256 DAN TANAH
KERAJAAN SELUAS 3454 EKAR,
TAMAN MUHIBBAH,
MUKIM DURIAN SEBATANG,
DAERAH HILIR PERAK,
PERAK DARUL RIDZUAN
UNTUK TETUAN :
GERGASI VENTURES SDN. BHD.

JURUTERA PERUNDING :
KYS PERUNDING KYS SDN. BHD.
(Company No. 1278815-T)
(MECHANICAL & ELECTRICAL CONSULTING ENGINEERS)
UNIT NO. A-3-1, (3RD FLOOR),
JALAN MEDAN IPOH 2,
BANGUNAN BARU MEDAN IPOH,
31400 IPOH, PERAK DARUL RIDZUAN.
TEL : 05-5483322 & 05-5483399
FAX : 05-5499250
E-MAIL ADDRESS : perundingkys@gmail.com

APPROVED
[Signature]
SYARIL BIN HASAN
19710
MALAYSIA

CHECKED : MR. GOH
SCALE : AS SHOWN
DRAWING NO. GV/22-64/T1
DRAWN : NUR ZULAIKHA
DATE : JULY 2022