
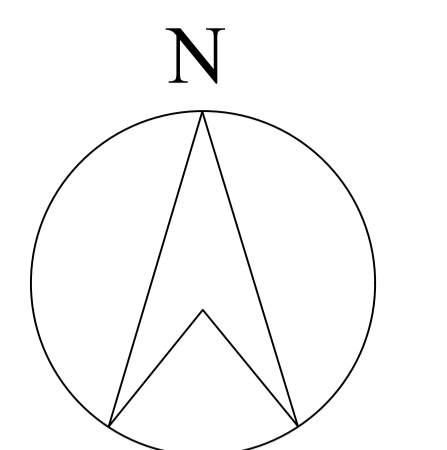


PETUNJUK	
PAIP AIR 100mm Ø CLMS (W)	
PAIP AIR SEDIA ADA	
PILI BOMBA (PENGLUARAN 2 HALA)	
INJAP PENYEKAT (SLUICE VALVE)	
INJAP PENCUCI (SCOUR VALVE)	
INJAP UDARA (AIR VALVE) WITH S-BEND	
ARAS TANAH DALAM METER (M)	

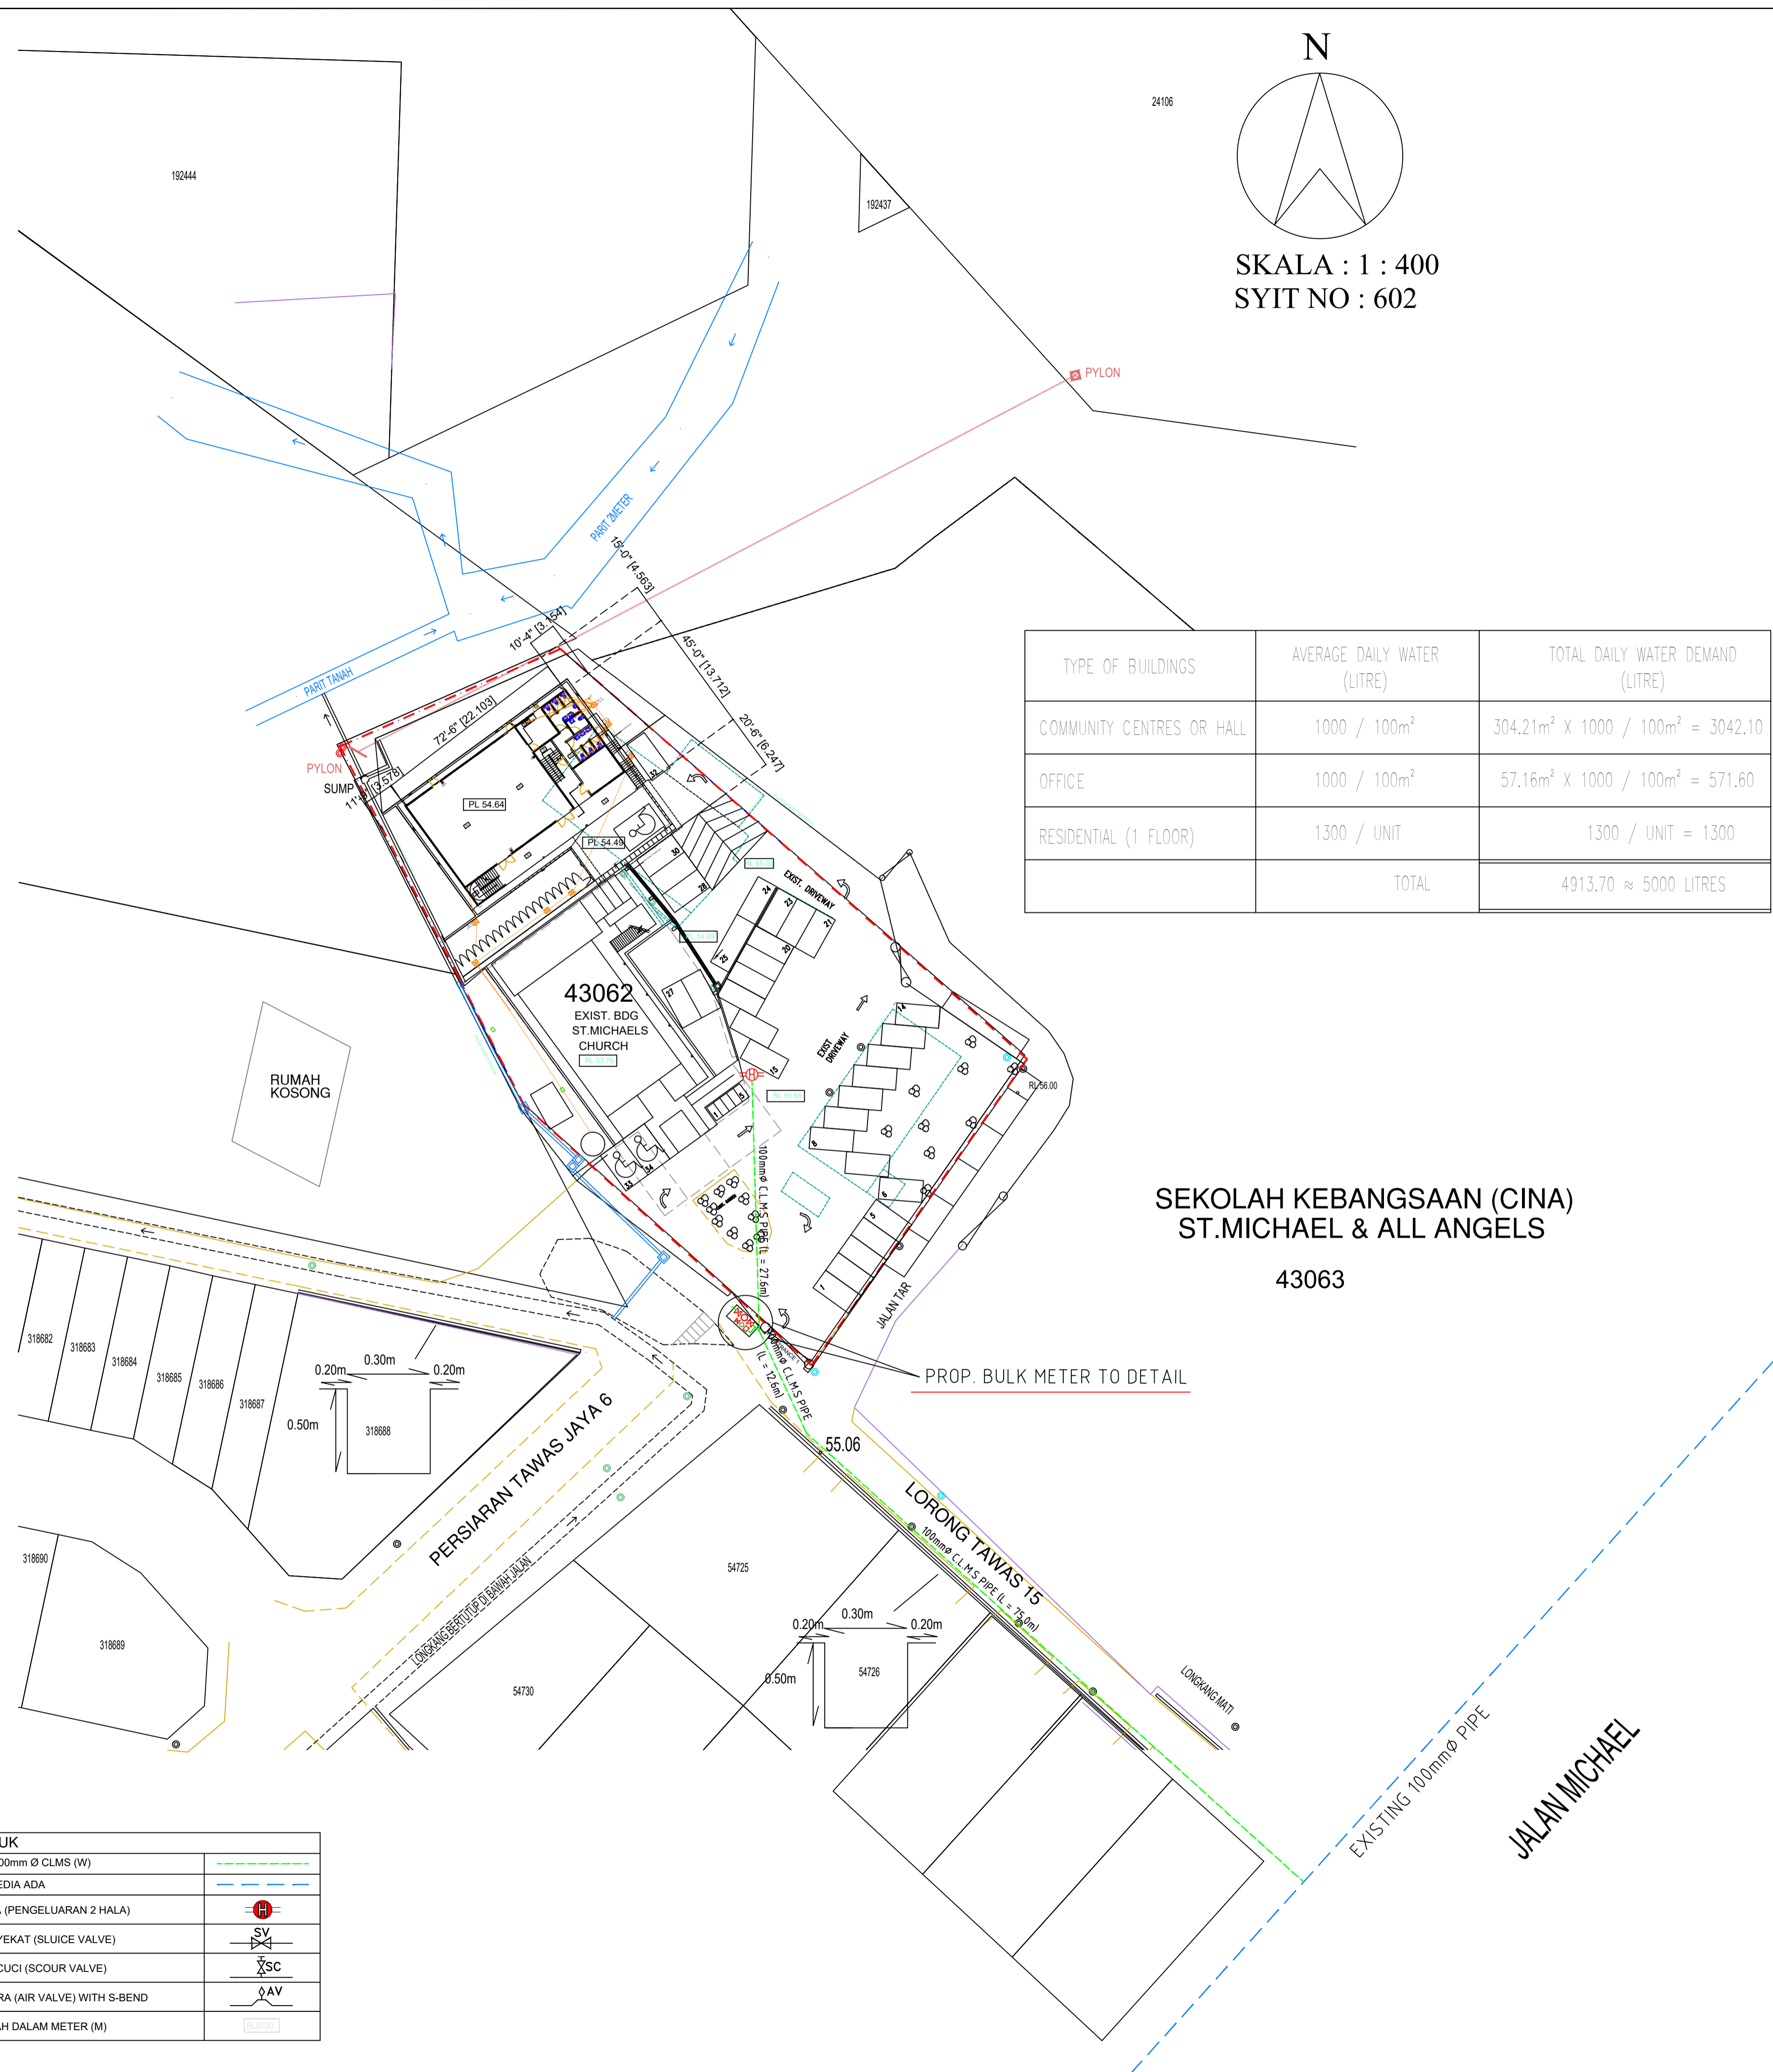

SKALA : 1 : 400  
SYIT NO : 602

TYPE OF BUILDINGS	AVERAGE DAILY WATER (LITRE)	TOTAL DAILY WATER DEMAND (LITRE)
COMMUNITY CENTRES OR HALL	1000 / 100m <sup>2</sup>	304.21m <sup>2</sup> X 1000 / 100m <sup>2</sup> = 3042.10
OFFICE	1000 / 100m <sup>2</sup>	57.16m <sup>2</sup> X 1000 / 100m <sup>2</sup> = 571.60
RESIDENTIAL (1 FLOOR)	1300 / UNIT	1300 / UNIT = 1300
	TOTAL	4913.70 ≈ 5000 LITRES

PROJEK:  
CADANGAN MEROBOK SEBUAH RUMAH PADERI 1-TINGKAT DAN MEMBINA 1 BLOK BANGUNAN 2 1/2 TINGKAT YANG MENGANDUNGI DEWAN SERBAGUNA, PEJABAT, BILIK MESYUARAT & 1 UNIT RUMAH PADERI DI ATAS LOT 43062, JALAN ST. MICHAEL, KAMPUNG TAWAS, 30010 IPOH, MUKIM ULU KINTA, DAERAH KINTA, PERAK UNTUK

SYNOD OF THE DIOCESE OF WEST MALAYSIA

PELAN BEKALAN AIR

KETERANGAN:  
SITE PLAN, KEY PLAN & LOCATION PLAN

PEMLIK TANAH :

SYNOD OF DIOCESE OF WEST MALAYSIA  
NAME : DR. CHONG SU-LIN (Diocesan Secretary)  
I.C. NO. : 800315-10-6678  
ADDRESS : WISMA ANGLICAN (THE SYNOD OF DIOCESE OF WEST MALAYSIA)  
NO. 16, JALAN PUDU LAMA, BUKIT BINTANG,  
50200 KUALA LUMPUR

TANDATANGAN JURUTERA:  
I HEREBY CERTIFY THAT THESE DETAILS ARE IN ACCORDANCE WITH THE WATER SUPPLY ENACTMENT AND BYE LAWS AND ACCEPT FULL RESPONSIBILITY FOR THE DESIGN AND SUPERVISION OF THE WORKS.

KN CONSULT SERVICES  
CONSULTING ENGINEER & PROJECT MANAGEMENT  
98, JALAN NG WENG HUP, TAMAN PERTAMA,  
30100 IPOH, PERAK DARUL RIDZUAN  
TEL / FAX : 05-526 6685

Ditulis	JASHNE
Disemak	C. SEGARAN
Skala	AS SHOWN
Tarikh	NOVEMBER 2025